



THE LOCATION, SIZE AND TYPE OF MATERIAL OF EXISTING UNDERGROUND UTILITIES INDICATED ON THE PLANS IS NOT REPRESENTED AS BEING ACCURATE, SUFFICIENT OR COMPLETE. IT SHALL BE THE CONTRACTOR'S RESPONSIBILITY TO DETERMINE THE ACTUAL LOCATION OF ALL SUCH FACILITIES, INCLUDING SERVICE CONNECTIONS TO UNDERGROUND UTILITIES. PRIOR TO CONSTRUCTION, THE CONTRACTOR SHALL NOTIFY THE UTILITY COMPANIES OF HIS OPERATIONAL PLANS AND SHALL OBTAIN FROM THE RESPECTIVE UTILITY COMPANIES DETAILED INFORMATION AND ASSISTANCE RELATIVE TO THE LOCATION OF THEIR FACILITIES AND THE WORKING SCHEDULE OF THE COMPANIES FOR REMOVAL OR ADJUSTMENT WHERE REQUIRED. IN THE EVENT AN UNEXPECTED UTILITY INTERFERENCE IS ENCOUNTERED DURING CONSTRUCTION, THE CONTRACTOR SHALL IMMEDIATELY NOTIFY THE UTILITY COMPANY OF JURISDICTION. THE ENGINEER SHALL ALSO BE IMMEDIATELY NOTIFIED. ANY SUCH MAINS AND SERVICES SHALL BE RESTORED TO SERVICE AT ONCE AND PAID FOR BY THE CONTRACTOR AT NO ADDITIONAL COST TO THE CONTRACT.

CALL J.U.L.I.E. FOR UTILITY INFORMATION AT 1-800-892-0123.

NOTE

ABANDONMENT AND/OR REMOVAL OF EXISTING RUNWAY OR TAXIWAY LIGHTING CABLES SHALL BE INCIDENTAL TO ITEM AR108158 1/C NO. 8, 5KV, U.G. CABLE IN U.D.

- LEGEND**
- EXISTING PAVEMENT
 - EXISTING ELECTRICAL CABLES
 - EXISTING ELECTRICAL DUCT
 - PROPOSED 1/C NO. 8, 5KV, U.G. CABLE IN U.D.
 - EXISTING STAKE MOUNTED TAXIWAY LIGHT
 - EXISTING BASE MOUNTED TAXIWAY LIGHT
 - EXISTING STAKE MOUNTED RUNWAY THRESHOLD LIGHT
 - EXISTING STAKE MOUNTED RUNWAY LIGHT
 - EXISTING BASE MOUNTED RUNWAY LIGHT
 - EXISTING TAXI GUIDANCE SIGN

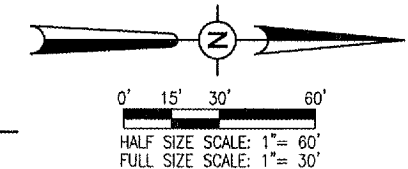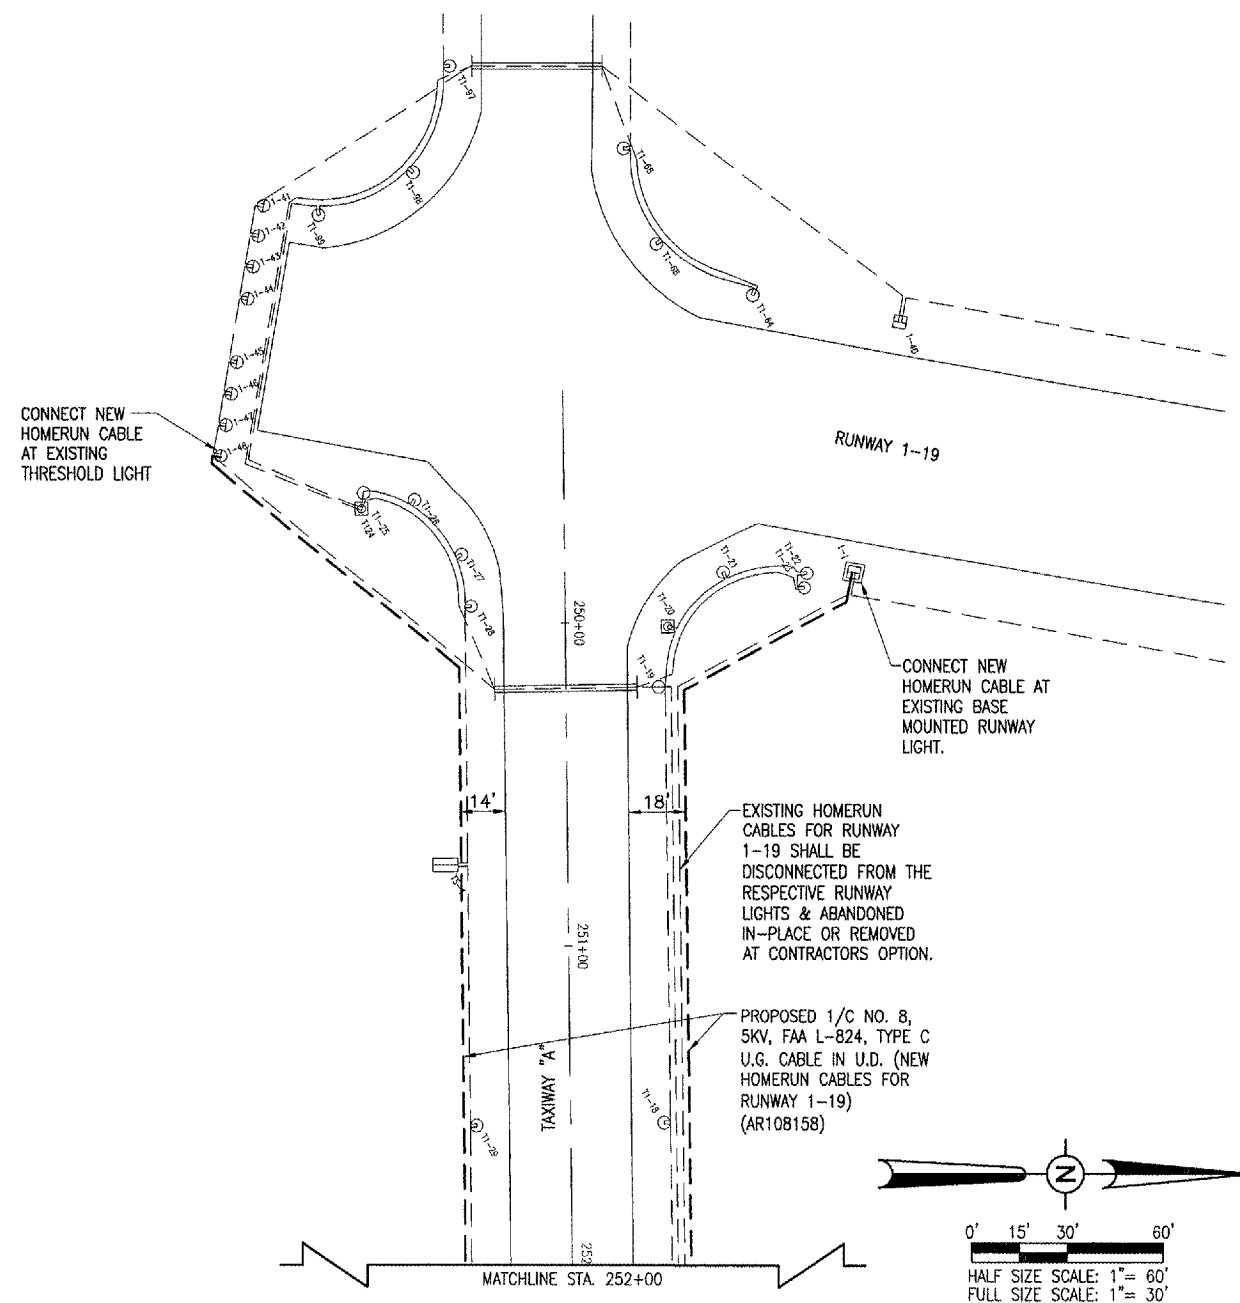

<p>BY</p>	<p>REVISION</p>	<p>DATE</p>	
<p>KEWANEE MUNICIPAL AIRPORT KEWANEE, HENRY COUNTY, ILLINOIS</p>			
<p>HEI Project No. 810-06MLID Drawing: R-142ELE.DWG Scale: 1"=30' Date: 04/28/06</p>		<p>LAYOUT: R.A.W. 08/02/05 DRAWN: B.A.K. 08/02/05 REVIEWED: C.A.H. 04/27/06</p>	
<p>HANSON Hanson Professional Services Inc. 3125 Dandy Trail, Suite 100 Indianapolis, Indiana 46214 Offices Nationwide</p>			
<p>CONSTRUCT VAULT</p>			
<p>PROPOSED ELECTRICAL PLAN TAXIWAY "A"</p>			
<p>8</p>		<p>of 27 sheets</p>	

IL. PROJ.: E2I-3586 A.I.P. PROJ.: 3-17-0058-B12