


DATE TIME USER


CONTRACT NO. 62877

(FOR CONTINUATION, SEE WEST HALF OF INTERCHANGE SHEET E8)

F.A. I. RTE.	SECTION	COUNTY	TOTAL SHEETS	SHEET NO.
290	0305302K-L-3	COOK	55	11
STA.	TO STA.			
FED. ROAD DIST. NO.	ILLINOIS	FED. AID PROJECT		

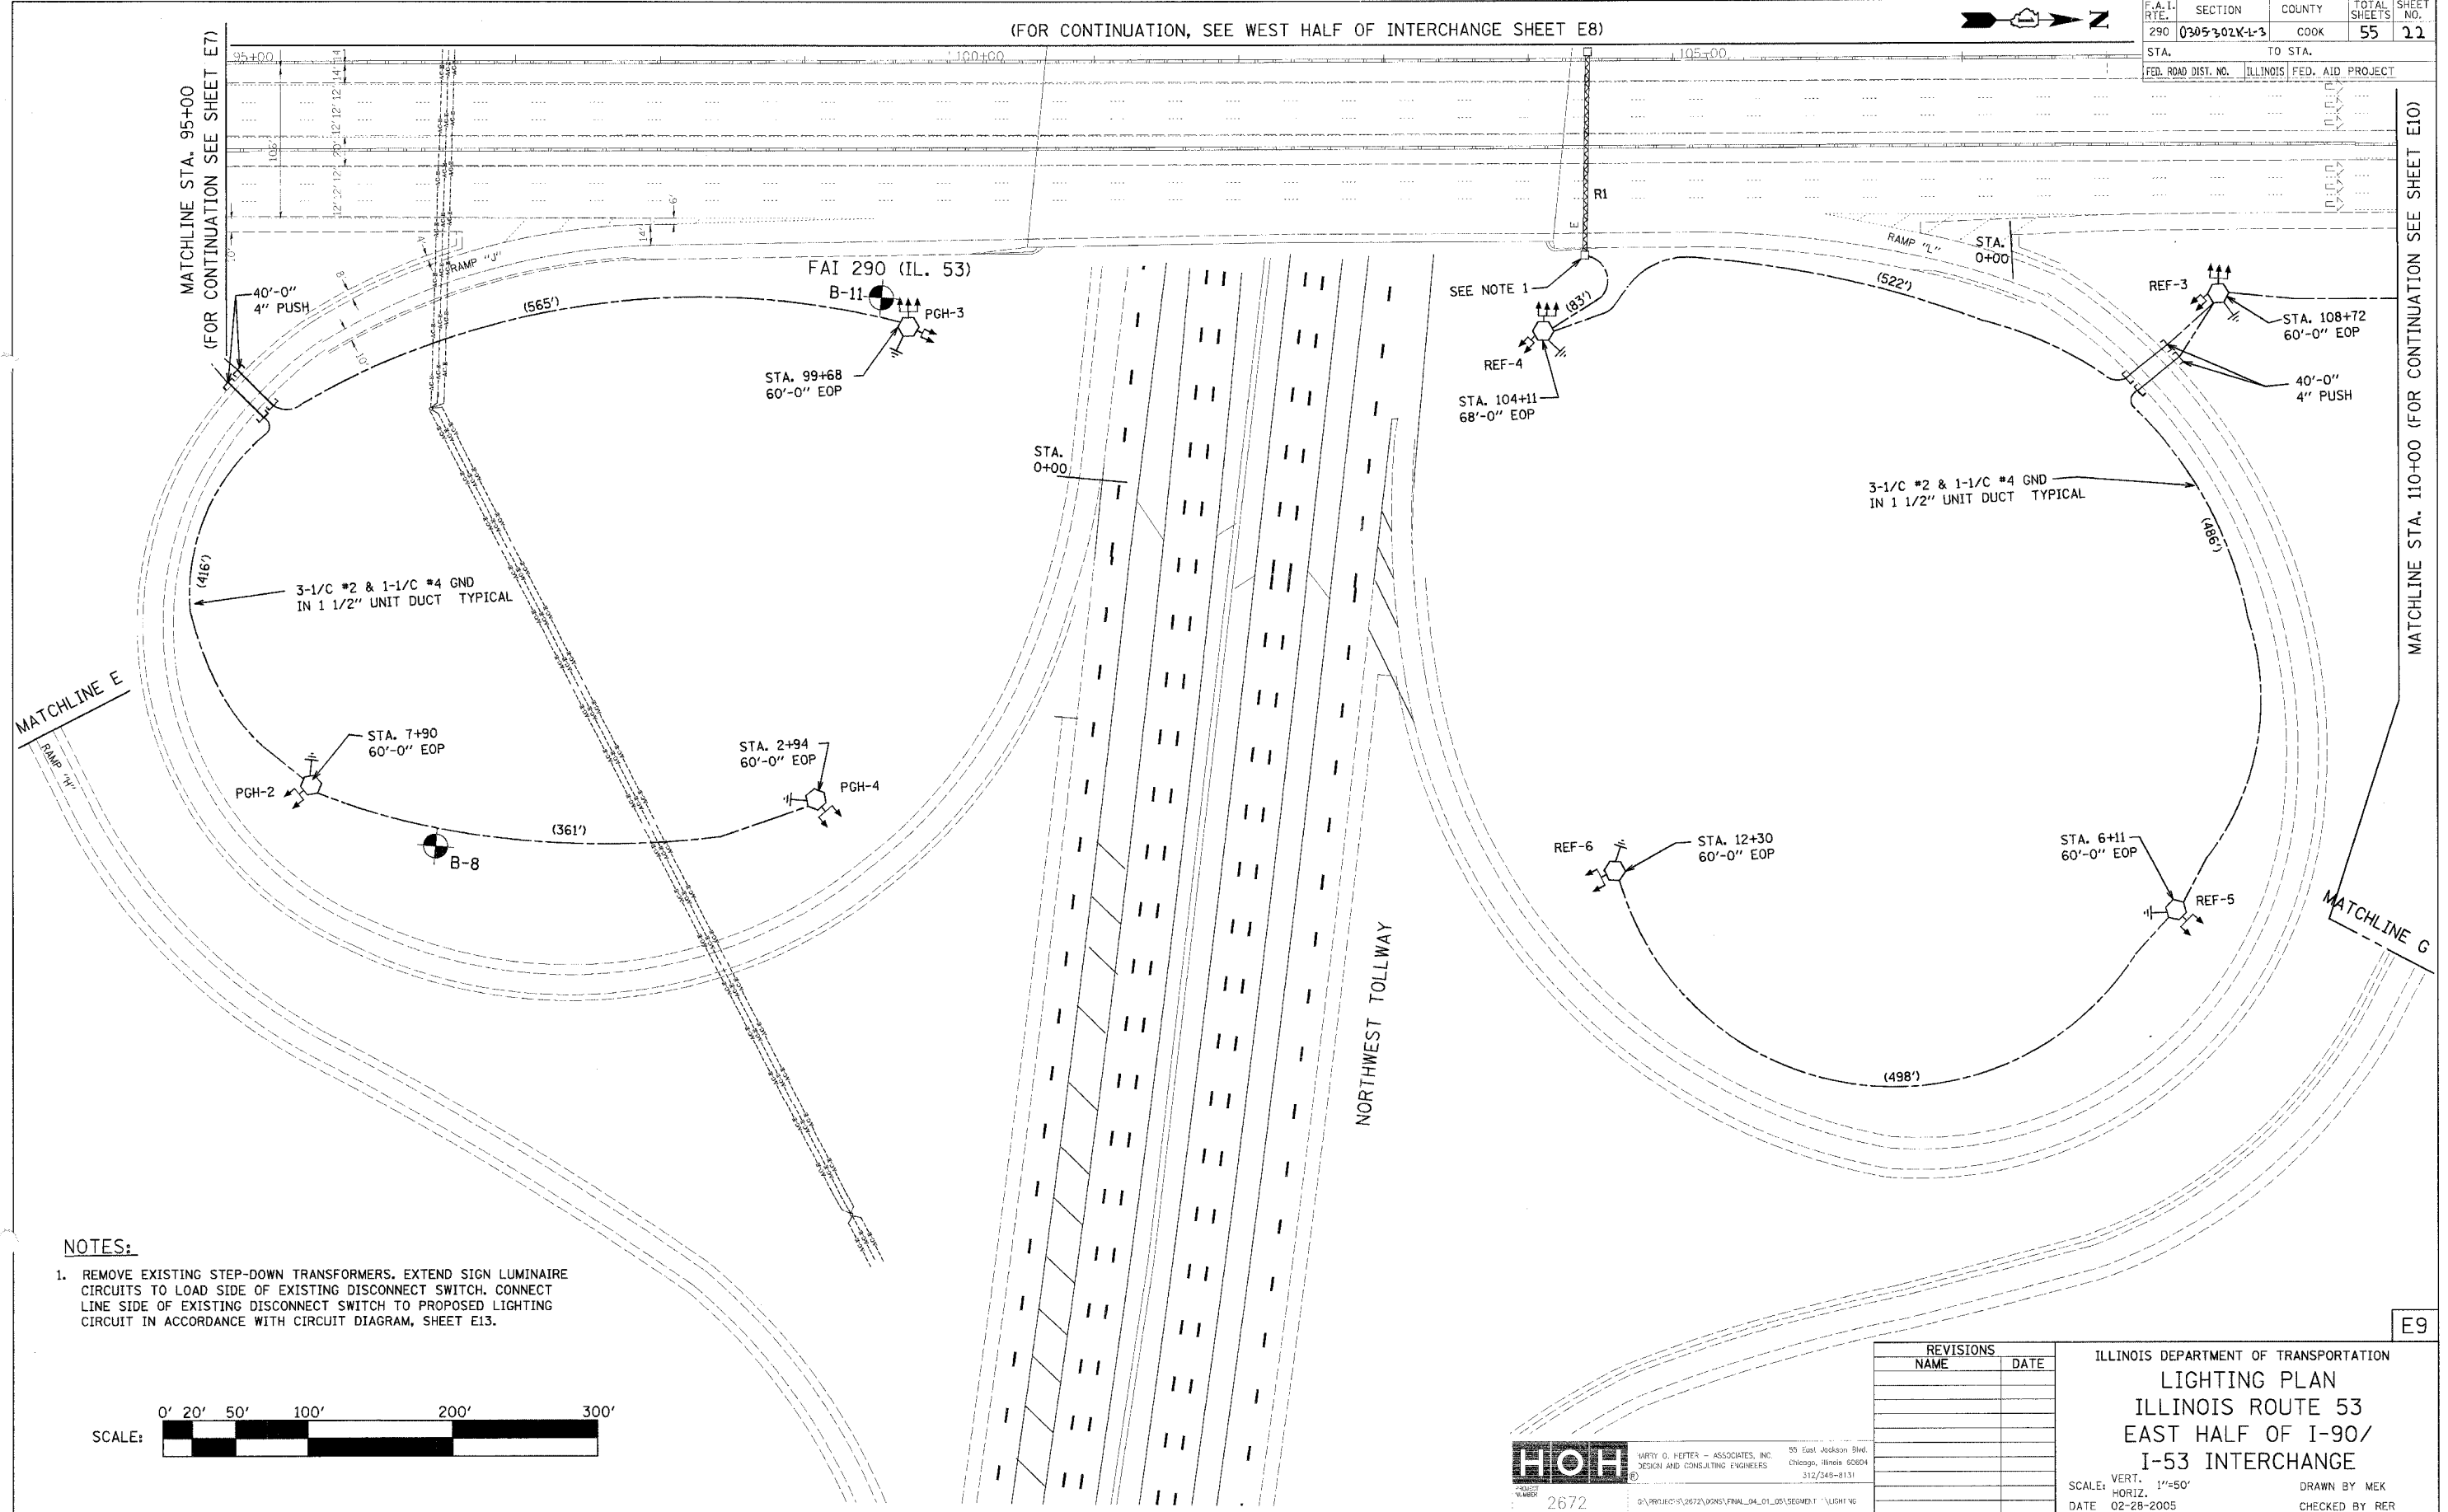

 - NOTES:**
1. REMOVE EXISTING STEP-DOWN TRANSFORMERS. EXTEND SIGN LUMINAIRE CIRCUITS TO LOAD SIDE OF EXISTING DISCONNECT SWITCH. CONNECT LINE SIDE OF EXISTING DISCONNECT SWITCH TO PROPOSED LIGHTING CIRCUIT IN ACCORDANCE WITH CIRCUIT DIAGRAM, SHEET E13.



PLOT DATE = 04/08/2005  
 FILE NAME = FILEL3  
 PLOT SCALE = 1/4"=50'  
 REFERENCE = REF#

**HOH**  
 HARRY O. HETTER - ASSOCIATES, INC.  
 DESIGN AND CONSULTING ENGINEERS  
 55 East Jackson Blvd.  
 Chicago, Illinois 60604  
 312/349-8131

REVISIONS	
NAME	DATE

ILLINOIS DEPARTMENT OF TRANSPORTATION  
**LIGHTING PLAN**  
 ILLINOIS ROUTE 53  
 EAST HALF OF I-90/  
 I-53 INTERCHANGE

SCALE: VERT. 1"=50'  
 HORIZ. 1"=50'  
 DATE 02-28-2005

DRAWN BY MEK  
 CHECKED BY RER

E9