

**DRAINAGE STRUCTURE TABLE STA. 61+50 TO STA. 66+50**


NO.	STA.	OFFSET	STRUCTURE TYPE/SIZE				FRAME & GRATE	RIM ELEV EP/FR	INVERT (N)	INVERT (S)	INVERT (E)	INVERT (W)
			MH	CB	INL	OTHER						
227	62+11	48.0' RT				PRC FES 12					788.15	
228	62+11	31.79' RT	A 4				24	788.94		785.95	785.95	
229	63+11	31.08' RT	A 4				24	789.58	785.64 EX	785.64 EX		

F.A.P. ROUTE	COUNTY SECTION	COUNTY	TOTAL SHTS.
336	99-00243-00-PV	KANE	268
CONTRACT NO.		UTILITY PLAN STA. 61+50 TO STA 66+50	
83782		F.H.W.A. REG.5 ILLINOIS PROJECT F-0336(C)	

KANE COUNTY CIRCUIT CLERK'S OFFICE


**PIPE TABLE STA. 61+50 TO STA. 66+50**

PIPE NO.	PIPE LOCATION		DESCRIPTION	DIA (IN)	L (FT)	S (%)	TRENCH BACKFILL	
	FROM STR #	TO STR #					L (FT)	VOL (CY)
S208	227	228	SS 1 RCCP IV	12	9	1.35	2	0.4
S209	228	EX	SS 1 RCCP IV	12	5	1.35	5	0.7

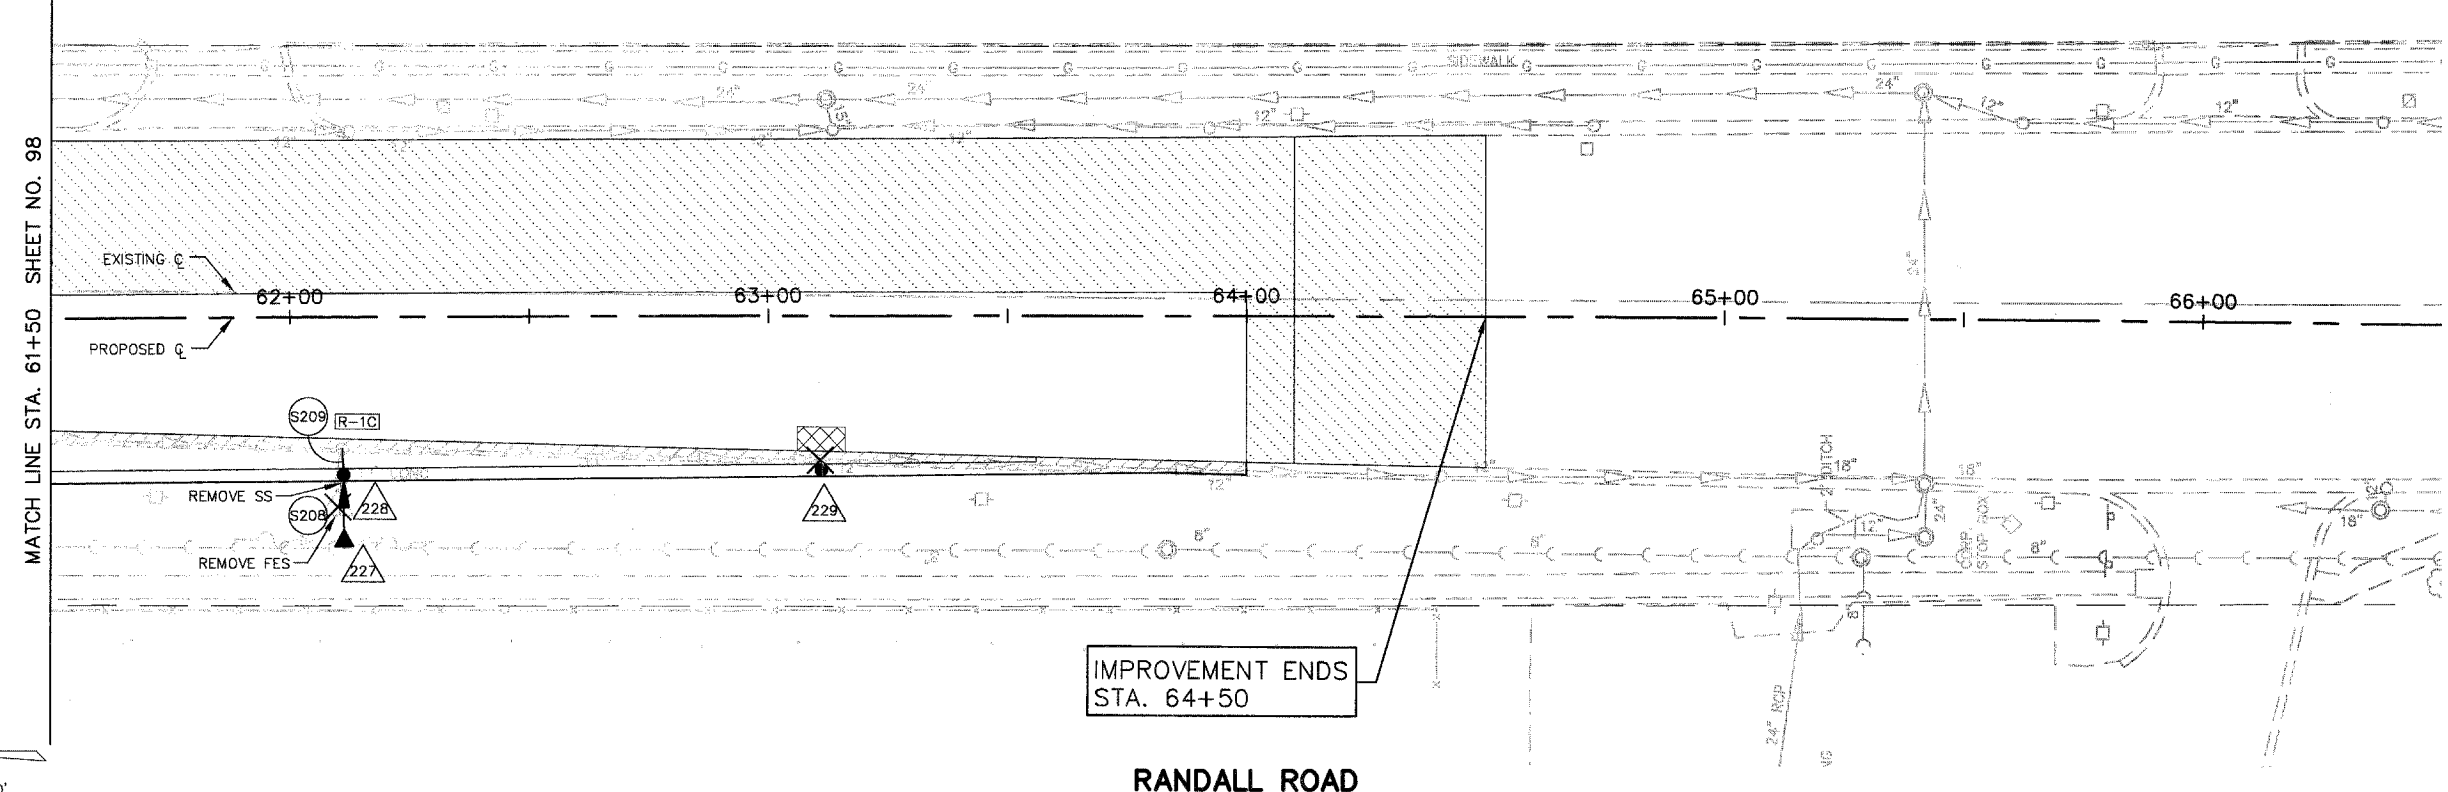

IMPROVEMENT ENDS STA. 64+50

SCALE: 1" = 20'

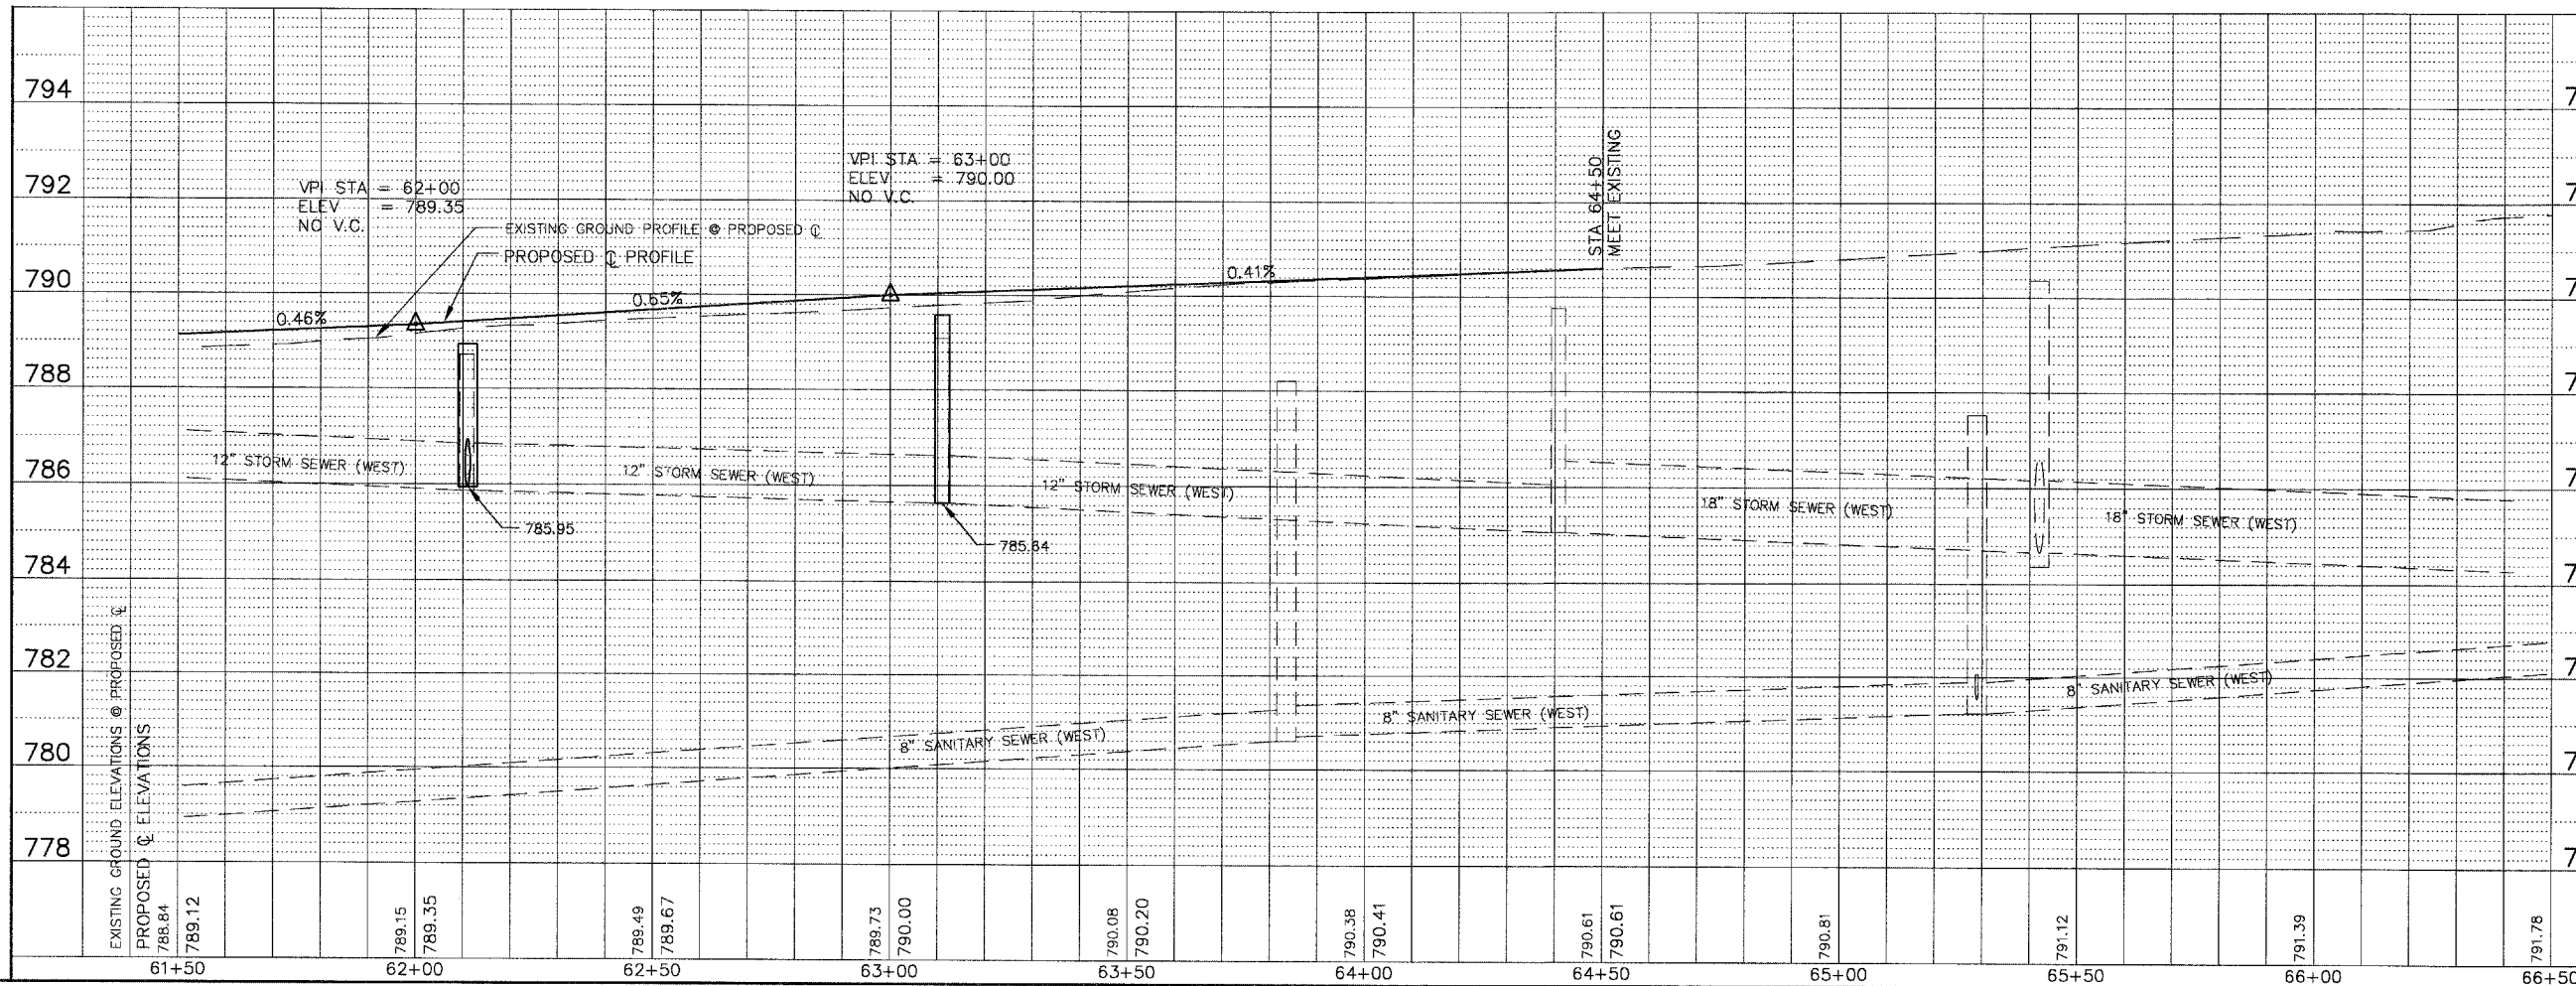

EXISTING GROUND ELEVATIONS @ PROPOSED C	788.84	789.12	789.15	789.35	789.49	789.67	789.73	790.00	790.08	790.20	790.38	790.41	790.61	790.61	790.81	791.12	791.39	791.78
PROPOSED C ELEVATIONS	789.12	789.12	789.15	789.35	789.49	789.67	789.73	790.00	790.08	790.20	790.38	790.41	790.61	790.61	790.81	791.12	791.39	791.78
	61+50	62+00	62+50	63+00	63+50	64+00	64+50	65+00	65+50	66+00	66+50							