


F.A. RTE.	SECTION	COUNTY	TOTAL SHEETS	SHEET NO.
	04-00001-00-PV	DEKALB	43	5
STA.	TO STA.			
FED. ROAD DIST. NO.	ILLINOIS	FED. AID PROJECT		

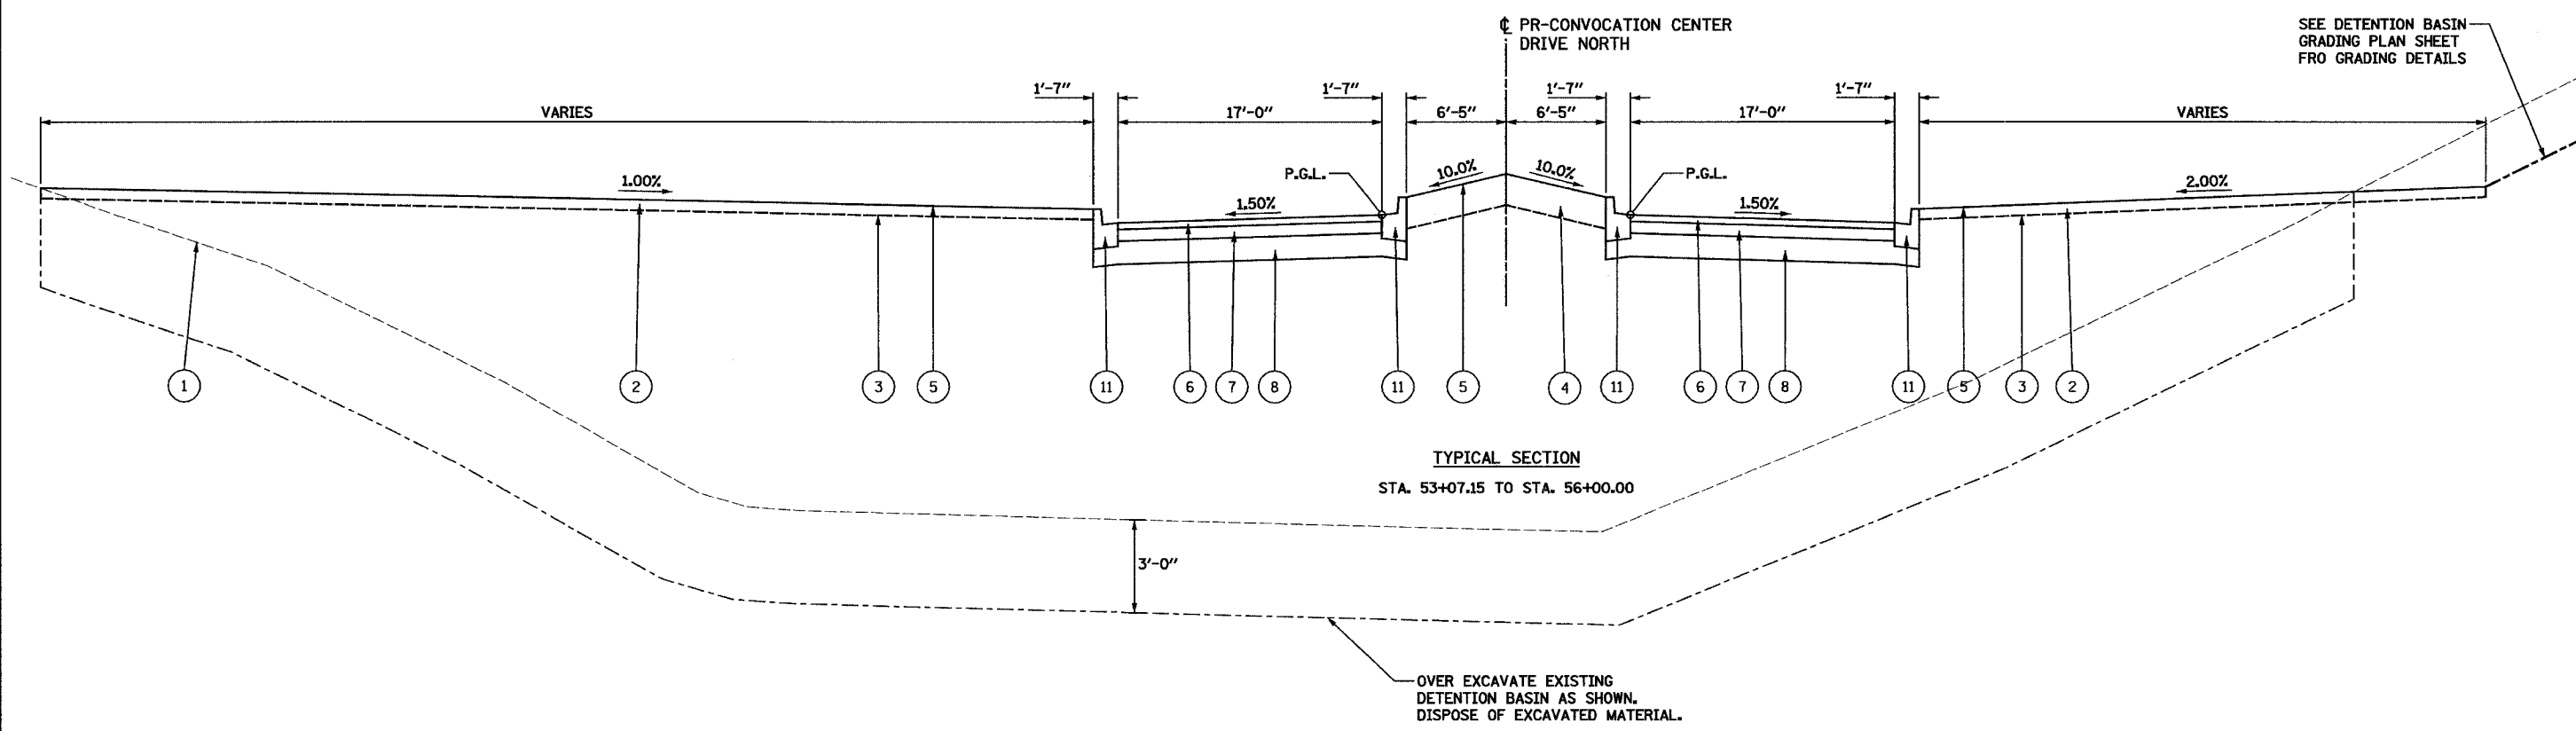

TYPICAL SECTION
STA. 53+07.15 TO STA. 56+00.00

SEE DETENTION BASIN
GRADING PLAN SHEET
FRO GRADING DETAILS

LEGEND	
① EXISTING GROUND LINE	⑦ PROPOSED BITUMINOUS CONCRETE BINDER COURSE, SUPERPAVE, IL-19.0, 4.5"
② PROPOSED GROUND LINE	⑧ PROPOSED SUB-BASE GRANULAR MATERIAL, TYPE B, 9"
③ PROPOSED TOPSOIL FURNISH AND PLACE, 4"	⑨ PROPOSED PORTLAND CEMENT CONCRETE SIDEWALK, 5"
④ PROPOSED TOPSOIL FURNISH AND PLACE, 12"	⑩ PROPOSED AGGREGATE BASE COURSE, TYPE A, 4"
⑤ PROPOSED SEEDING, CLASS 2	⑪ PROPOSED COMBINATION CONCRETE CURB AND GUTTER, TYPE B-6.12
⑥ PROPOSED BITUMINOUS CONCRETE SURFACE COURSE, SUPERPAVE, MIX "C", N50, 2.5"	⑫ PROPOSED LIGHT POLE AND BASE (SEE LIGHTING PLANS FOR LOCATIONS)

REVISIONS	
NAME	DATE

ILLINOIS DEPARTMENT OF TRANSPORTATION
SECTION 04-00001-00-PV
DEKALB COUNTY
NORTHERN ILLINOIS UNIVERSITY WEST ACCESS ROAD
**CONVOCAION CENTER DRIVE NORTH
TYPICAL SECTION**

SCALE: VERT. _____
HORIZ. _____
DATE 04/05/05

DRAWN BY RLA
CHECKED BY MGD

HANSON
 Hanson Professional Services Inc.
 Copyright Hanson Professional Services Inc. 2005

LAYOUT RLA 01/03/05 mmh
 DRAWN RLA 04/05/05 04/14/2005
 REVIEWED MGD 04/05/05 1:04:05 PM 1999 Civil Sheet 50271P.dgn