
 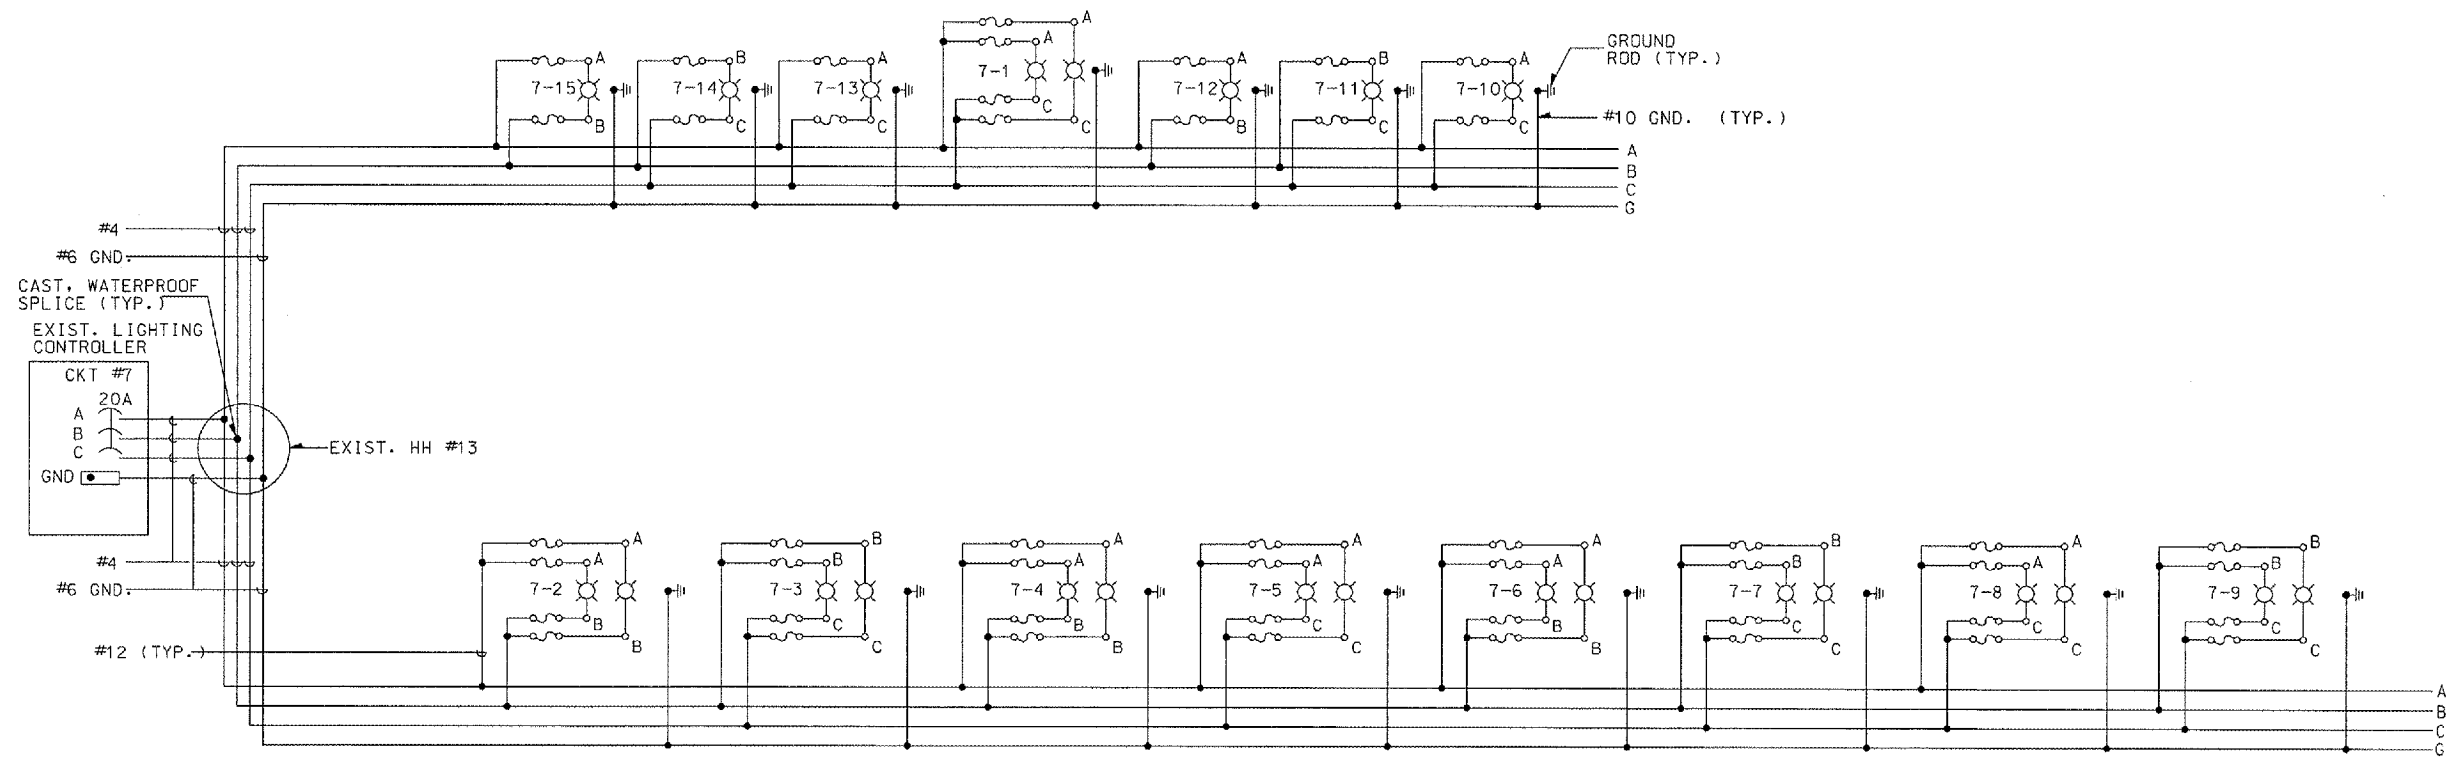


REVISIONS		
NUMBER	BY	DATE



LIGHTING CIRCUIT #7
ONE-LINE DIAGRAM

GREATER
Peoria
 REGIONAL
Airport

**CONSTRUCT, LIGHT & MARK
 WEST LONG TERM PARKING LOT**

CMT
 CRAWFORD, MURPHY & TILLY, INC.
 CONSULTING ENGINEERS

IL PROJECT NUMBER PIA-3385
FILE:
DESIGN BY: WDP
DRAWN BY: JSP
CHECKED BY: BWG
APPROVED BY: CET
DATE: JUNE 17, 2005
JOB No: 05061-03-00

05/26/2005 k:\peoria\05061\03\draw\sheet27_lighting_circuit_no7.dgn