


NOTE THAT NUMBER OF CABLES IN SPLICE MAY VARY


TYPICAL SPLICE DETAIL

N.T.S.

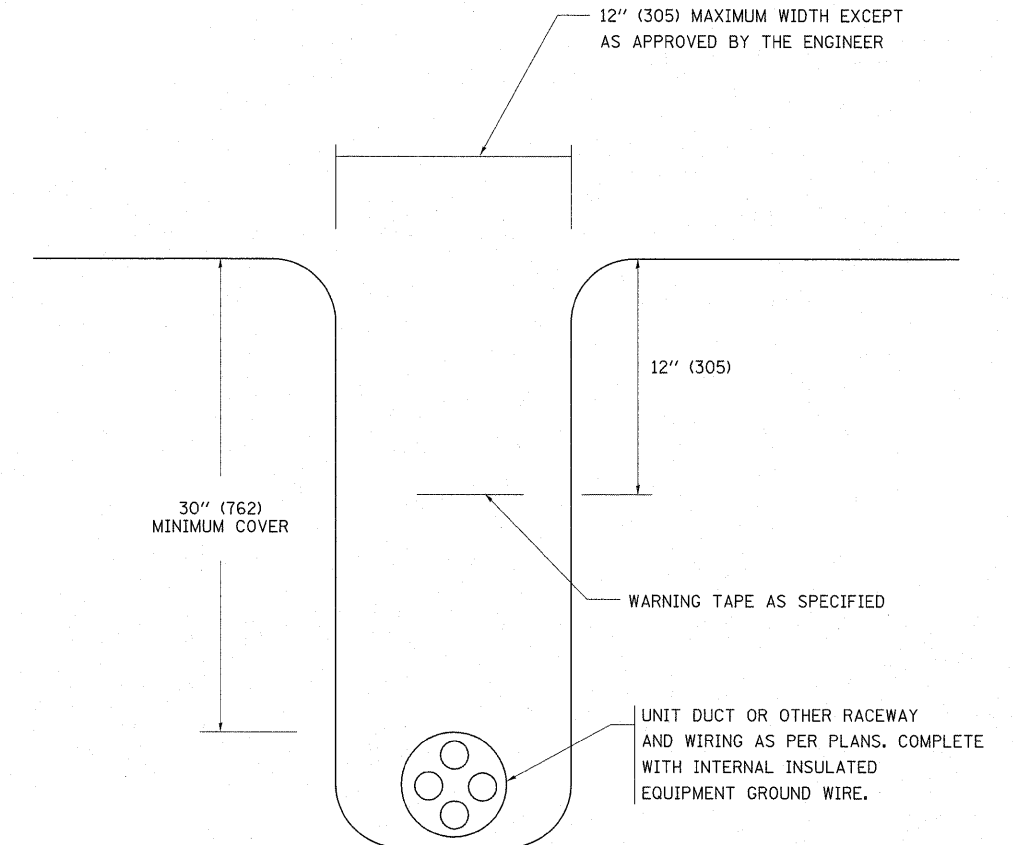

TYPICAL WIRING IN TRENCH DETAIL

N.T.S.

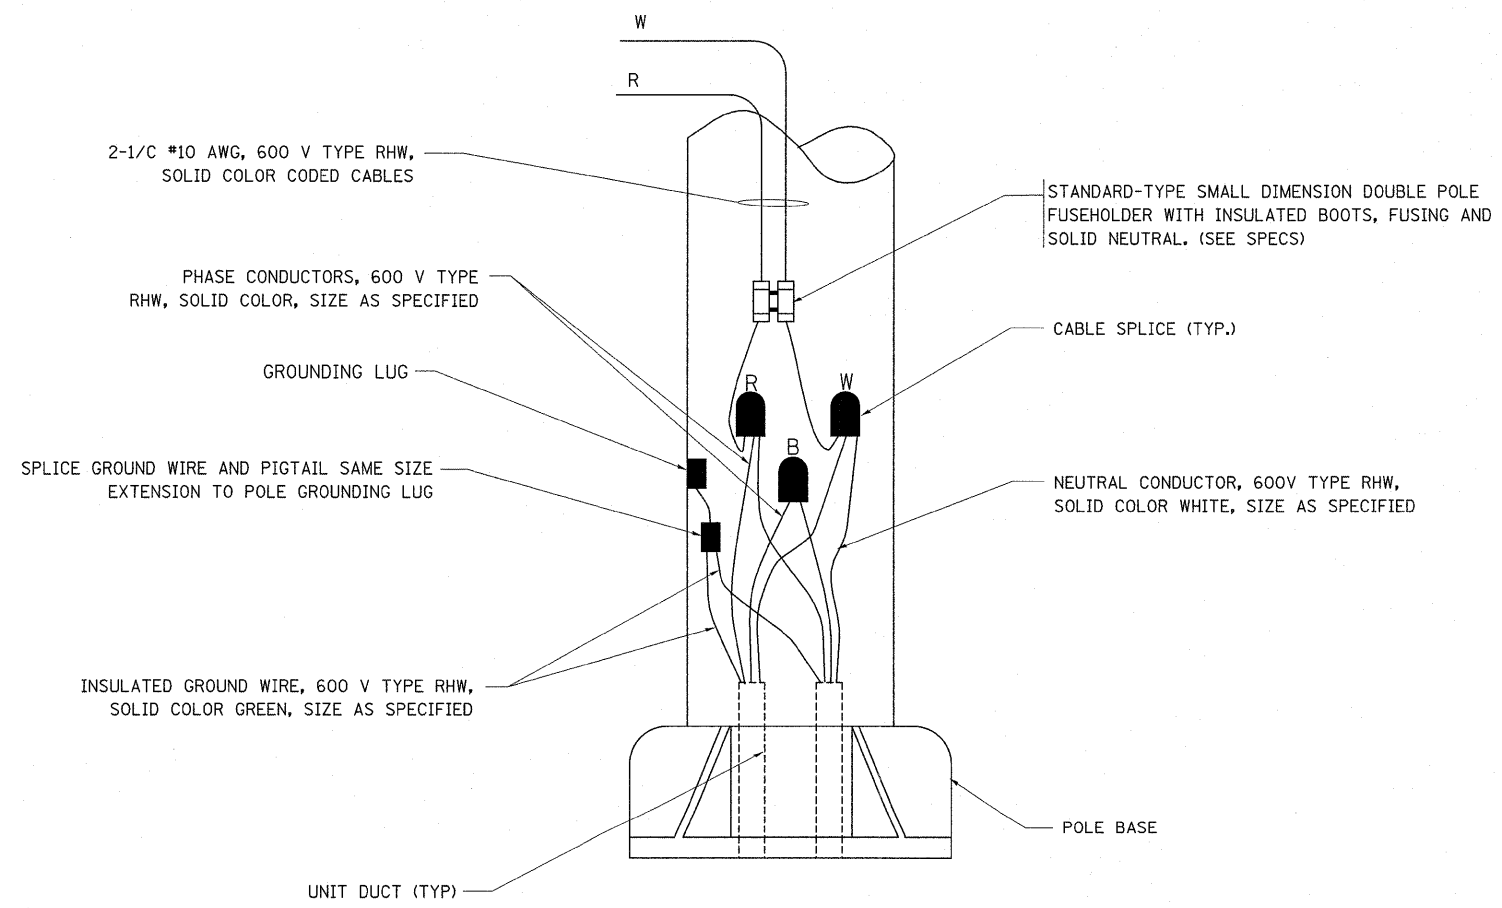

POLE WIRING DETAIL

N.T.S.

FILE NAME =	USER NAME = kellers	DESIGNED -	REVISED - 08-08-03	<b>STATE OF ILLINOIS DEPARTMENT OF TRANSPORTATION</b>	<b>MISC. ELECTRICAL DETAILS SHEET A</b>			F.A.P. RTE. 338	SECTION 7 HB-K-N	COUNTY COOK	TOTAL SHEETS 82	SHEET NO. 64
et:\pw_work\pwidot\kellers\0156262\Dist5	d.dgn	DRAWN -	REVISED -		SCALE: NONE	SHEET NO. 1 OF 1 SHEETS	STA. TO STA.	FED. ROAD DIST. NO. 1 (ILLINOIS) FED. AID PROJECT				
	PLOT SCALE = 50.0000 / IN.	CHECKED -	REVISED -		<b>BE-702</b>							
	PLOT DATE = 2/3/2011	DATE -	REVISED -		CONTRACT NO. 60K62							