


FOR INFORMATION ONLY

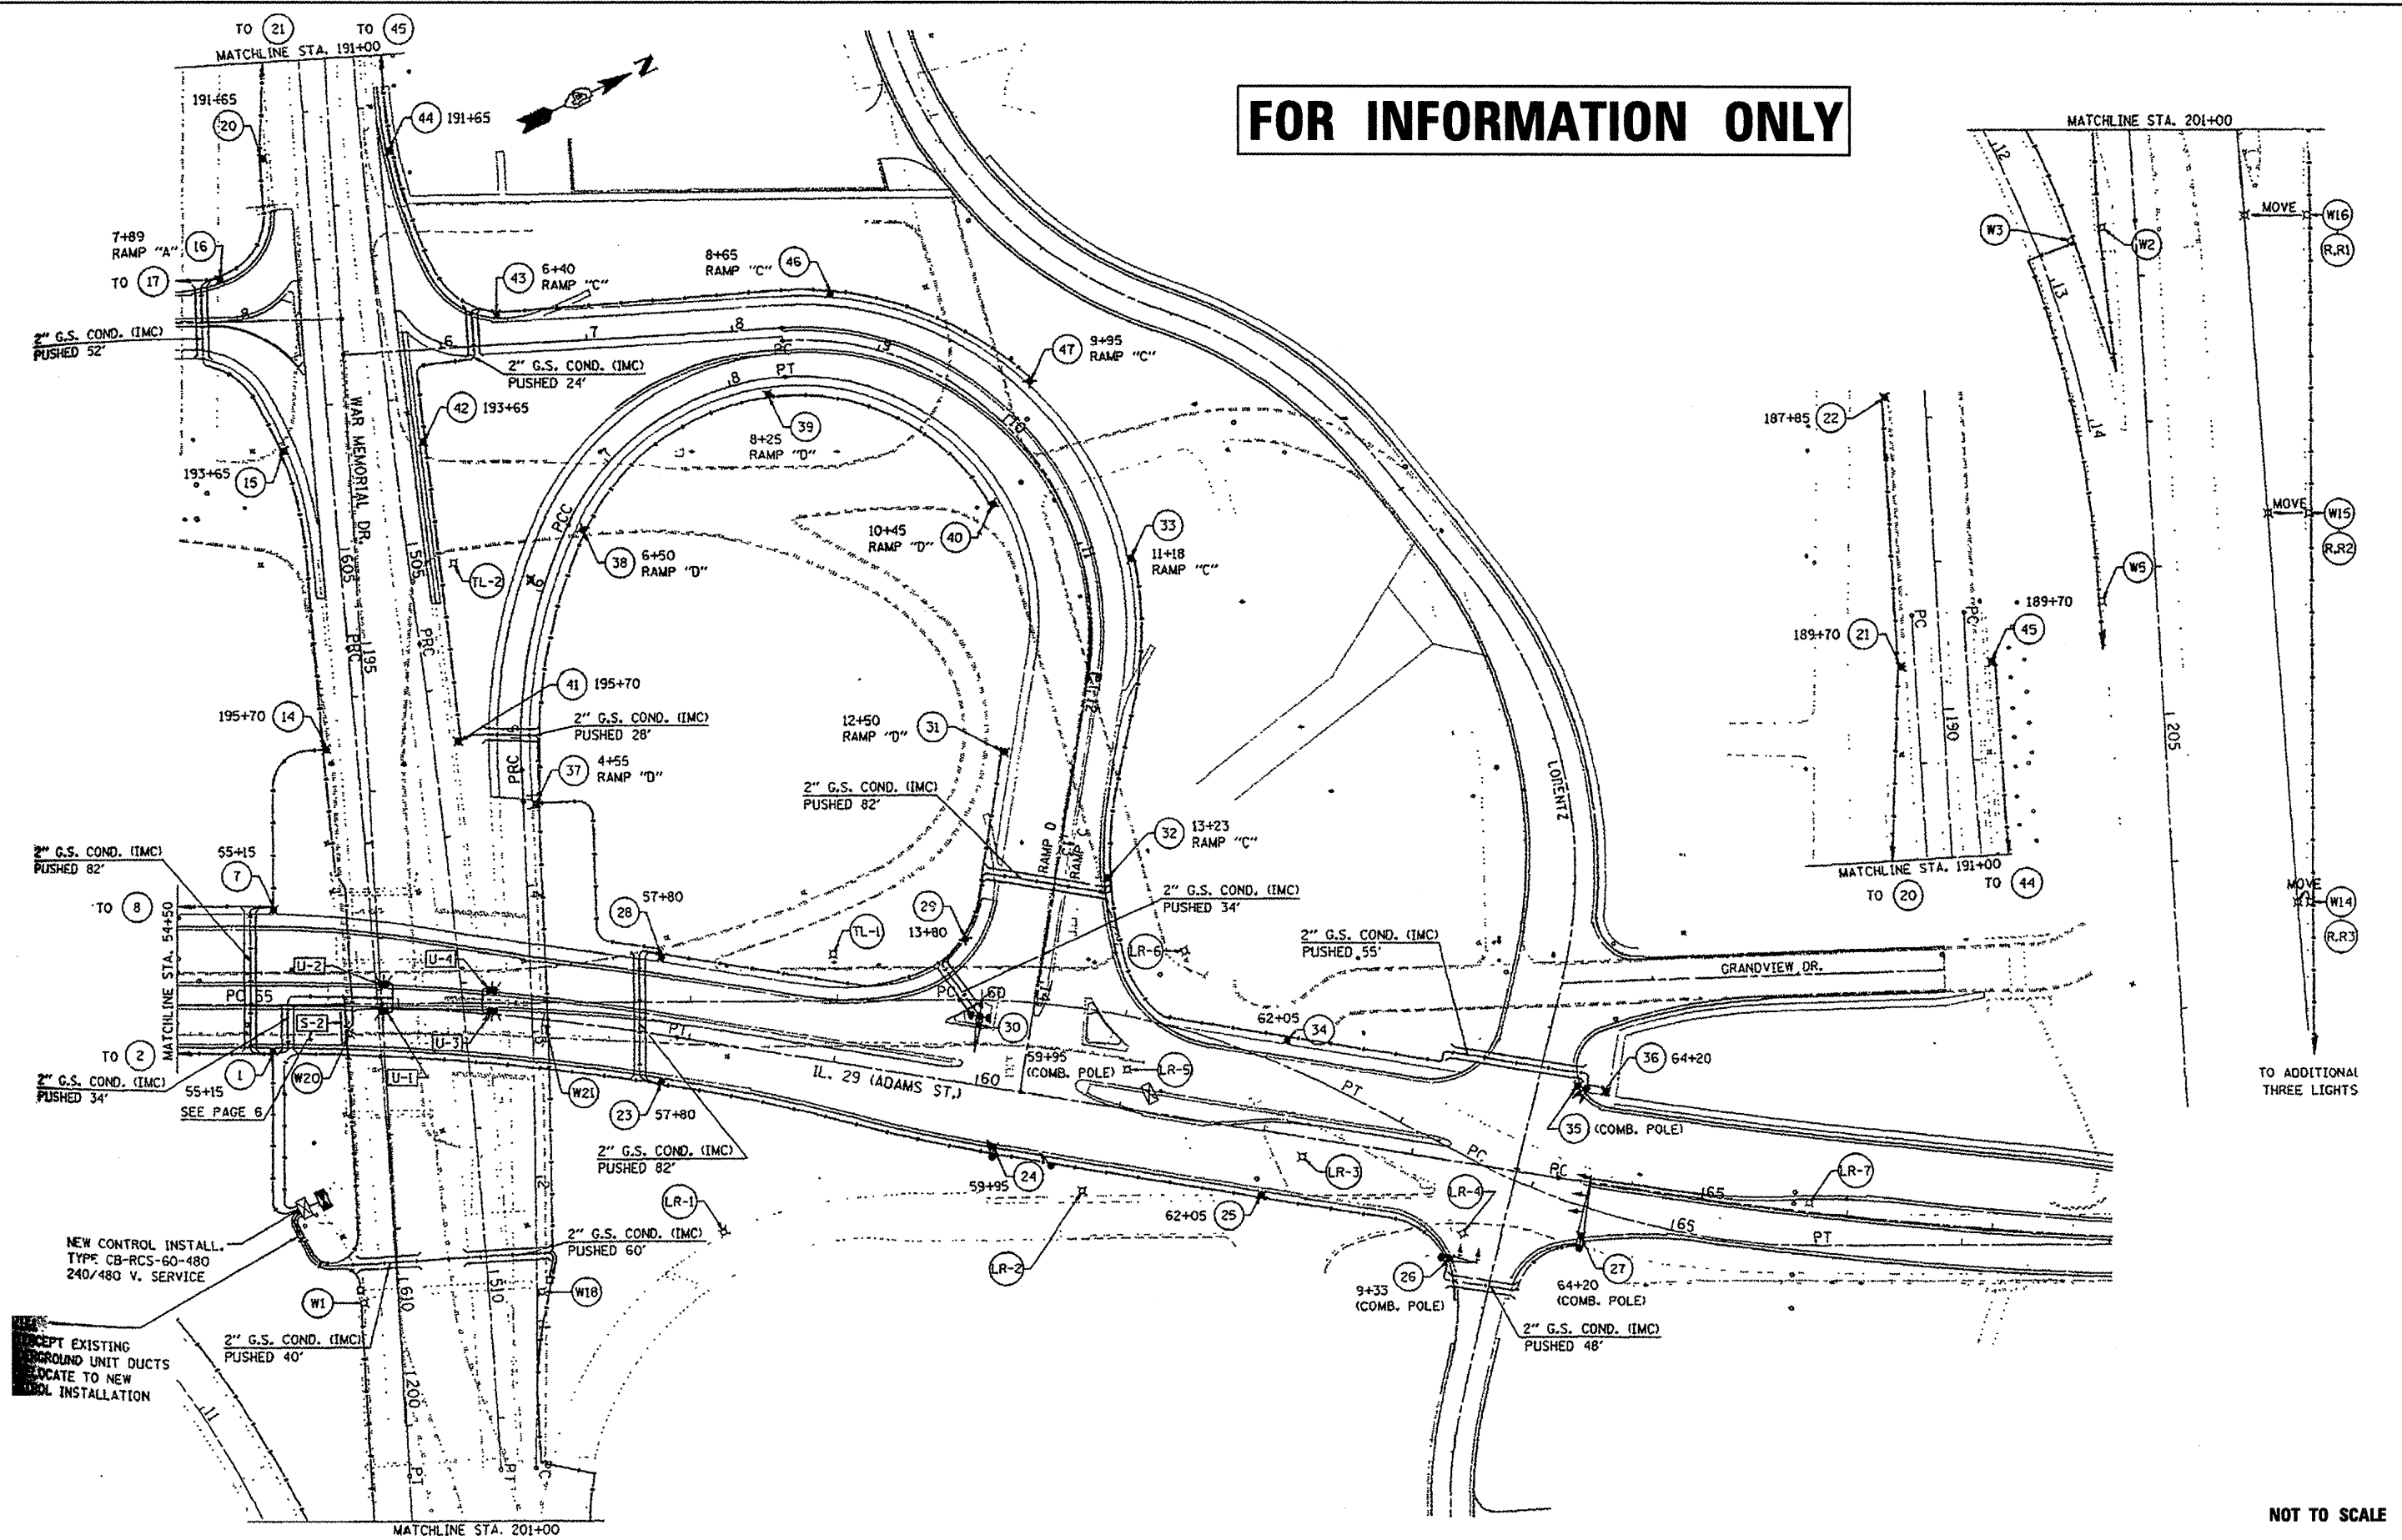

TO ADDITIONAL THREE LIGHTS

NOT TO SCALE

| | | | | | | | | | | | | |
|---|-----------------------|------------|-----------|---|--|-----------------|-------------------------------|--------------------------|---------------------------|--------------------|--|--|
| FILE NAME = 68992 - Overhead Lighting.dgn | USER NAME = hovejdar | DESIGNED - | REVISED - | STATE OF ILLINOIS DEPARTMENT OF TRANSPORTATION | EXISTING LIGHTING PLANS (CONTINUED) US 150 (WAR MEMORIAL DR.) & IL 29 (ADAMS ST.) | F.A.P. RTE. 317 | SECTION 14R | COUNTY PEORIA | TOTAL SHEETS 42 | SHEET NO. 19 | | |
| PLOT SCALE = 40,0000' / IN. | PLOT DATE = 3/23/2011 | DRAWN - | REVISED - | | | SCALE: _____ | SHEET NO. ____ OF ____ SHEETS | STA. _____ TO STA. _____ | ILLINOIS FED. AID PROJECT | | | |
| | | CHECKED - | REVISED - | | | | | | | CONTRACT NO. 68992 | | |
| | | DATE - | REVISED - | | | | | | | | | |