


NOTE: EXISTING WIRE INDICATED BY DASHED LINES.
NEW WIRING INDICATED WITH SOLID LINES.

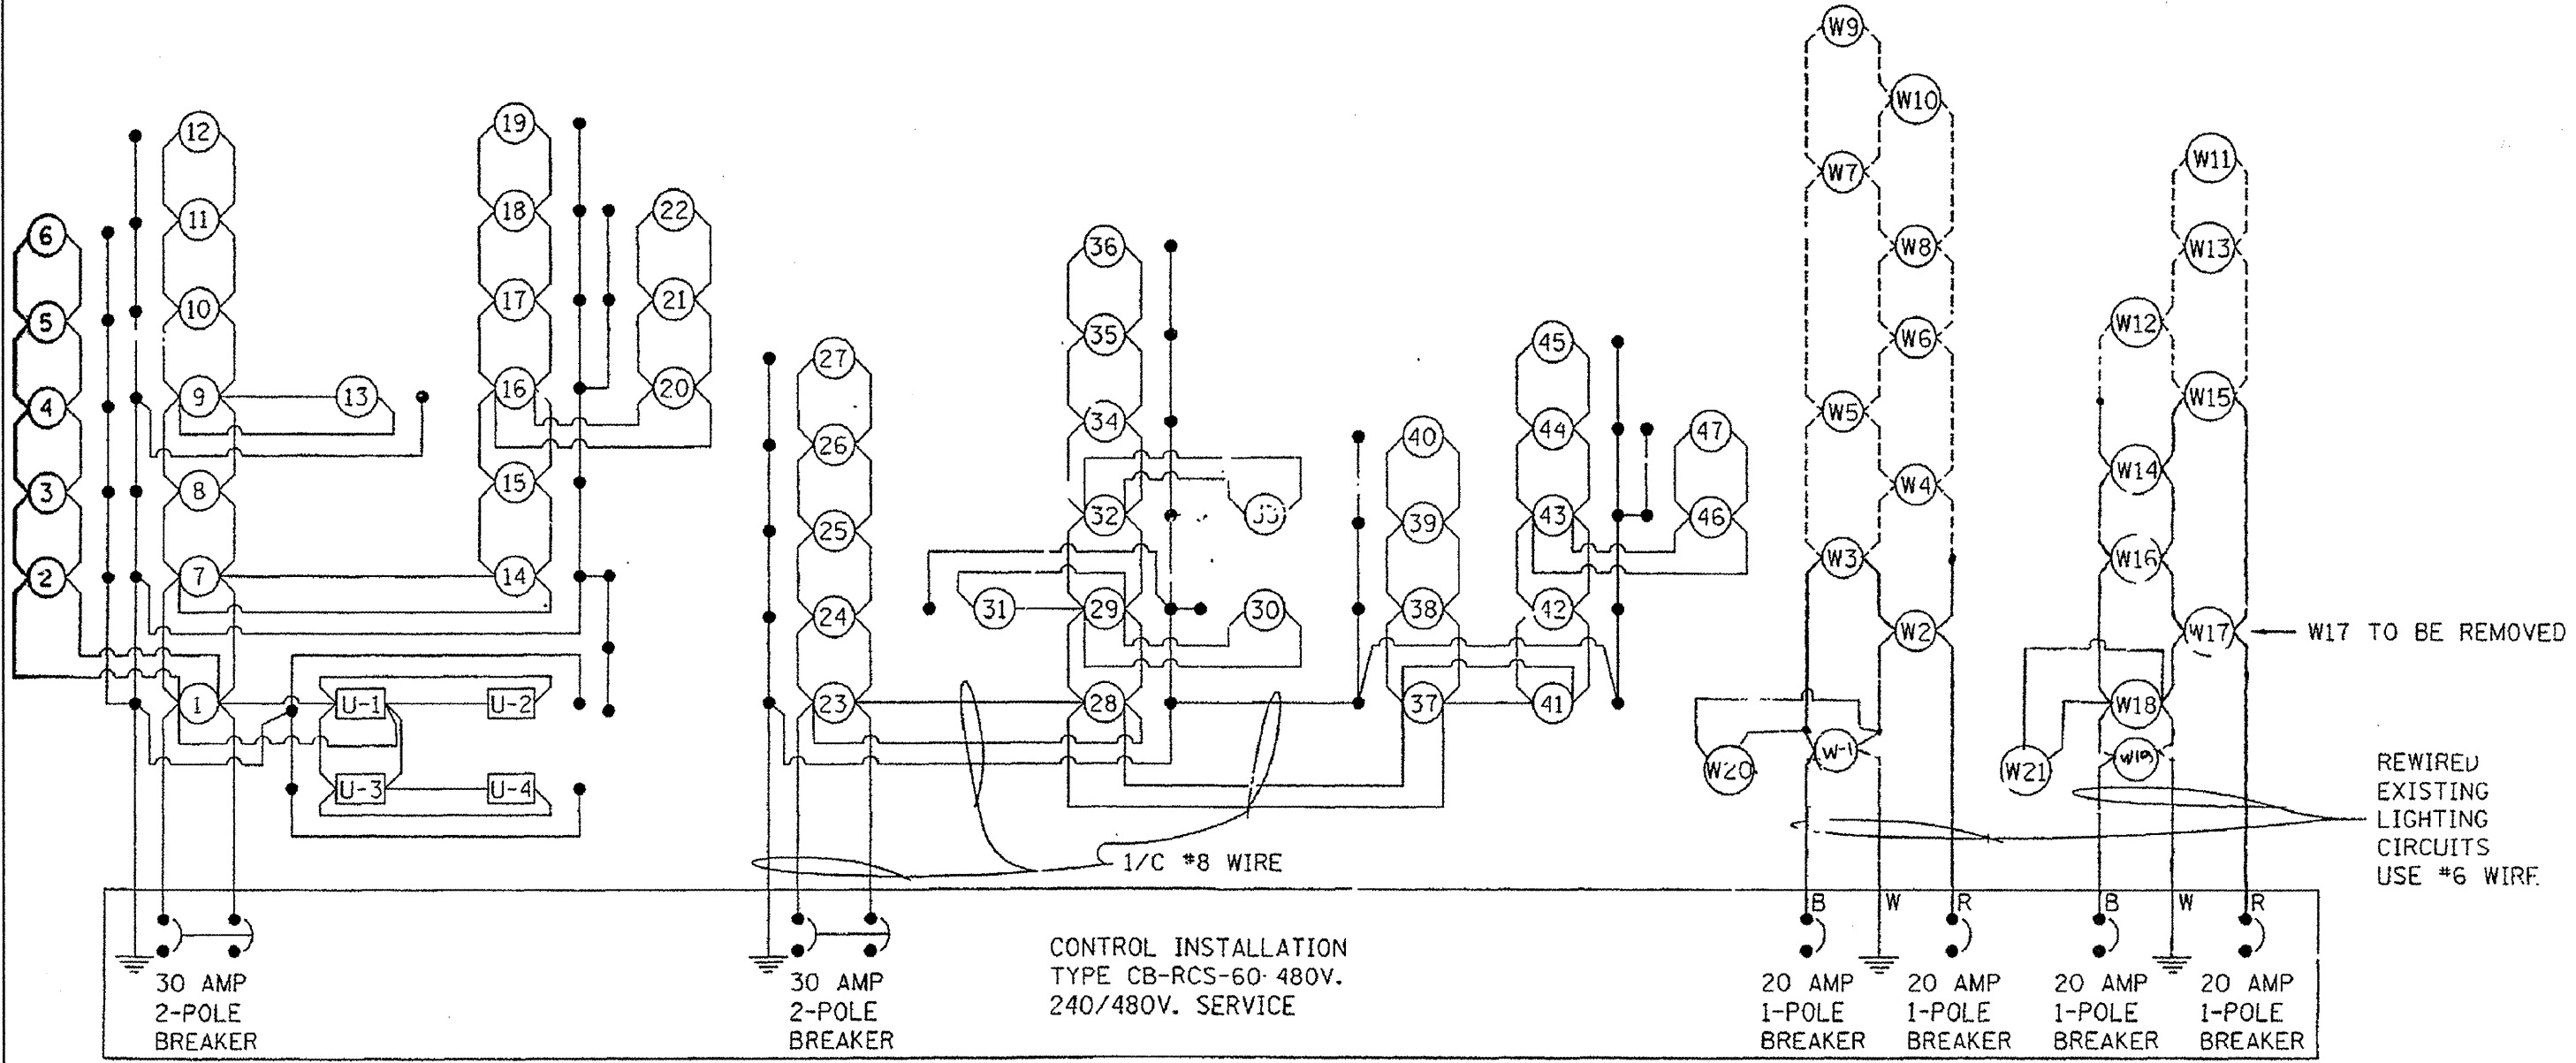

ALL UNDERGROUND CIRCUITS SHALL BE #10 WIRE UNLESS OTHERWISE NOTED.

FOR INFORMATION ONLY

NOT TO SCALE

FILE NAME = 68992 - Overhead Lighting.dgn	USER NAME = hwealder	DESIGNED -	REVISED -	STATE OF ILLINOIS DEPARTMENT OF TRANSPORTATION	EXISTING LIGHTING PLANS (CONTINUED) US 150 (WAR MEMORIAL DR.) & IL 29 (ADAMS ST.)		F.A.P. RTE.	SECTION	COUNTY	TOTAL SHEETS	SHEET NO.
	PLOT SCALE = 40,0000' / IN.	DRAWN -	REVISED -		SCALE: _____	SHEET NO. ____ OF ____ SHEETS	STA. _____ TO STA. _____	317	14R	PEORIA	42
PLOT DATE = 3/23/2011	DATE -	REVISD -	REVISD -				ILLINOIS FED. AID PROJECT CONTRACT NO. 68992				