


- EX TOE OF LEVEE
- REMOVAL LEGEND**
- PAVEMENT REM
  - PAVED SHLD REMOVAL
  - PAVED DITCH REMOVAL
  - REMOVAL LINEAR ITEMS (SEE CALLOUTS BELOW)
  - GUARDRAIL REMOV
  - CABLE ROAD GD REM
  - WOV W FENCE REMOV

- NOTES:**
1. SEE DRAINAGE PLANS FOR DRAINAGE REMOVALS.
  2. SEE LIGHTING PLANS FOR LIGHTING REMOVALS.
  3. SEE PLAT OF HIGHWAYS FOR FULL EXTENT OF USACE GENERAL PURPOSE LICENSE (GPL).
  4. SEE SCHEDULE OF QUANTITIES FOR SIGN REMOVAL PAY ITEMS AND QUANTITIES.

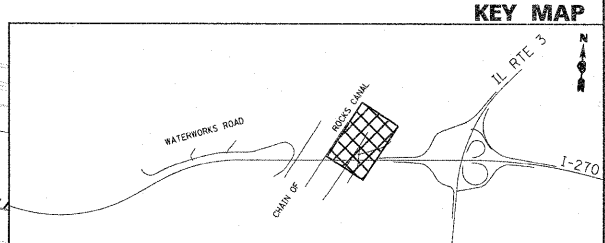

FILE NAME = D876A91-Sh1-Rem12.dgn

USER NAME = obtivan  
 DESIGNED - SJM  
 DRAWN - ML  
 CHECKED - SJM  
 DATE - 06-30-10

REVISED - 01-04-11  
 REVISED - 6/7/11 ADDENDUM  
 REVISED -  
 REVISED -

**STATE OF ILLINOIS  
 DEPARTMENT OF TRANSPORTATION**

**REMOVAL PLANS  
 CHAIN OF ROCKS LEVEE ROAD**

SCALE: 1" = 50' SHEET NO. 12 OF 12 SHEETS STA. 149+00 TO STA. 159+12.60

F.A.I. RTE.	SECTION	COUNTY	TOTAL SHEETS	SHEET NO.
270	60-13-1	MADISON	712	49
CONTRACT NO. 76A91				
ILLINOIS FED. AID PROJECT				