


CENTER LIGHTS	
POLE NO.	STATION
P41	1193+04.8
P42	1194+99.8
P43	1196+94.8
P44	1198+89.8
P45	1200+84.8
P46	1202+79.8
P47	1204+74.8

LEFT NAV LIGHTS	
NO.	STATION
N1 (180° RED)	1199+61.25
N3 (360° GREEN)	1201+78.00
N5 (180° RED)	1203+94.75

LEFT SIDE LIGHTS		
POLE NO.	STATION	OFFSET
P39	1190+72.2	44.50'

RIGHT NAV LIGHTS	
NO.	STATION
N2 (180° RED)	1199+04.75
N4 (360° GREEN)	1201+21.50
N6 (180° RED)	1203+38.25


RIGHT SIDE LIGHTS		
POLE NO.	STATION	OFFSET
P40	1191+37.5	50.50'

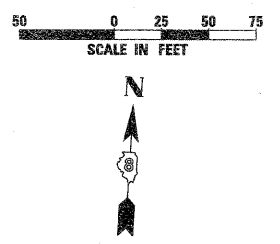

MATCH LINE WATERWORKS ROAD STA 433+08

MATCH LINE I-270 STA 1190+00

MATCH LINE STA 1205+00

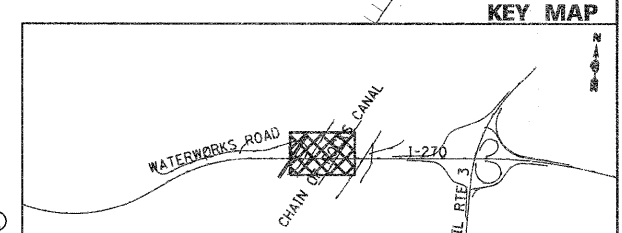

▲ PROPOSED LIGHTING LINE STYLE CHANGE

FILE NAME = #FILE#	USER NAME = #USER# PLOT SCALE = #SCALE# PLOT DATE = #DATE#	DESIGNED - FSM DRAWN - MNR CHECKED - AAB DATE - 3/18/11	REVISED - REVISED - REVISED - 6/7/11 ADDENDUM ▲ REVISED -	STATE OF ILLINOIS DEPARTMENT OF TRANSPORTATION	HIGHWAY LIGHTING PLANS INTERSTATE 270	FAI 270	SECTION 60-1B-1	COUNTY MADISON	TOTAL SHEETS 712	SHEET NO. 333
		SCALE: 1" = 50' SHEET NO. 5 OF 10 SHEETS STA. 1190+00 TO STA. 1205+00				CONTRACT NO. 76A91 <small>ILLINOIS FED. AID PROJECT</small>				