



RIGHT SIDE LIGHTS		
POLE NO.	STATION	OFFSET
P71	11233+64.9	20.00'
P73	11234+96.8	20.00'
P75	11236+29.2	20.00'
P77	11237+59.2	20.00'

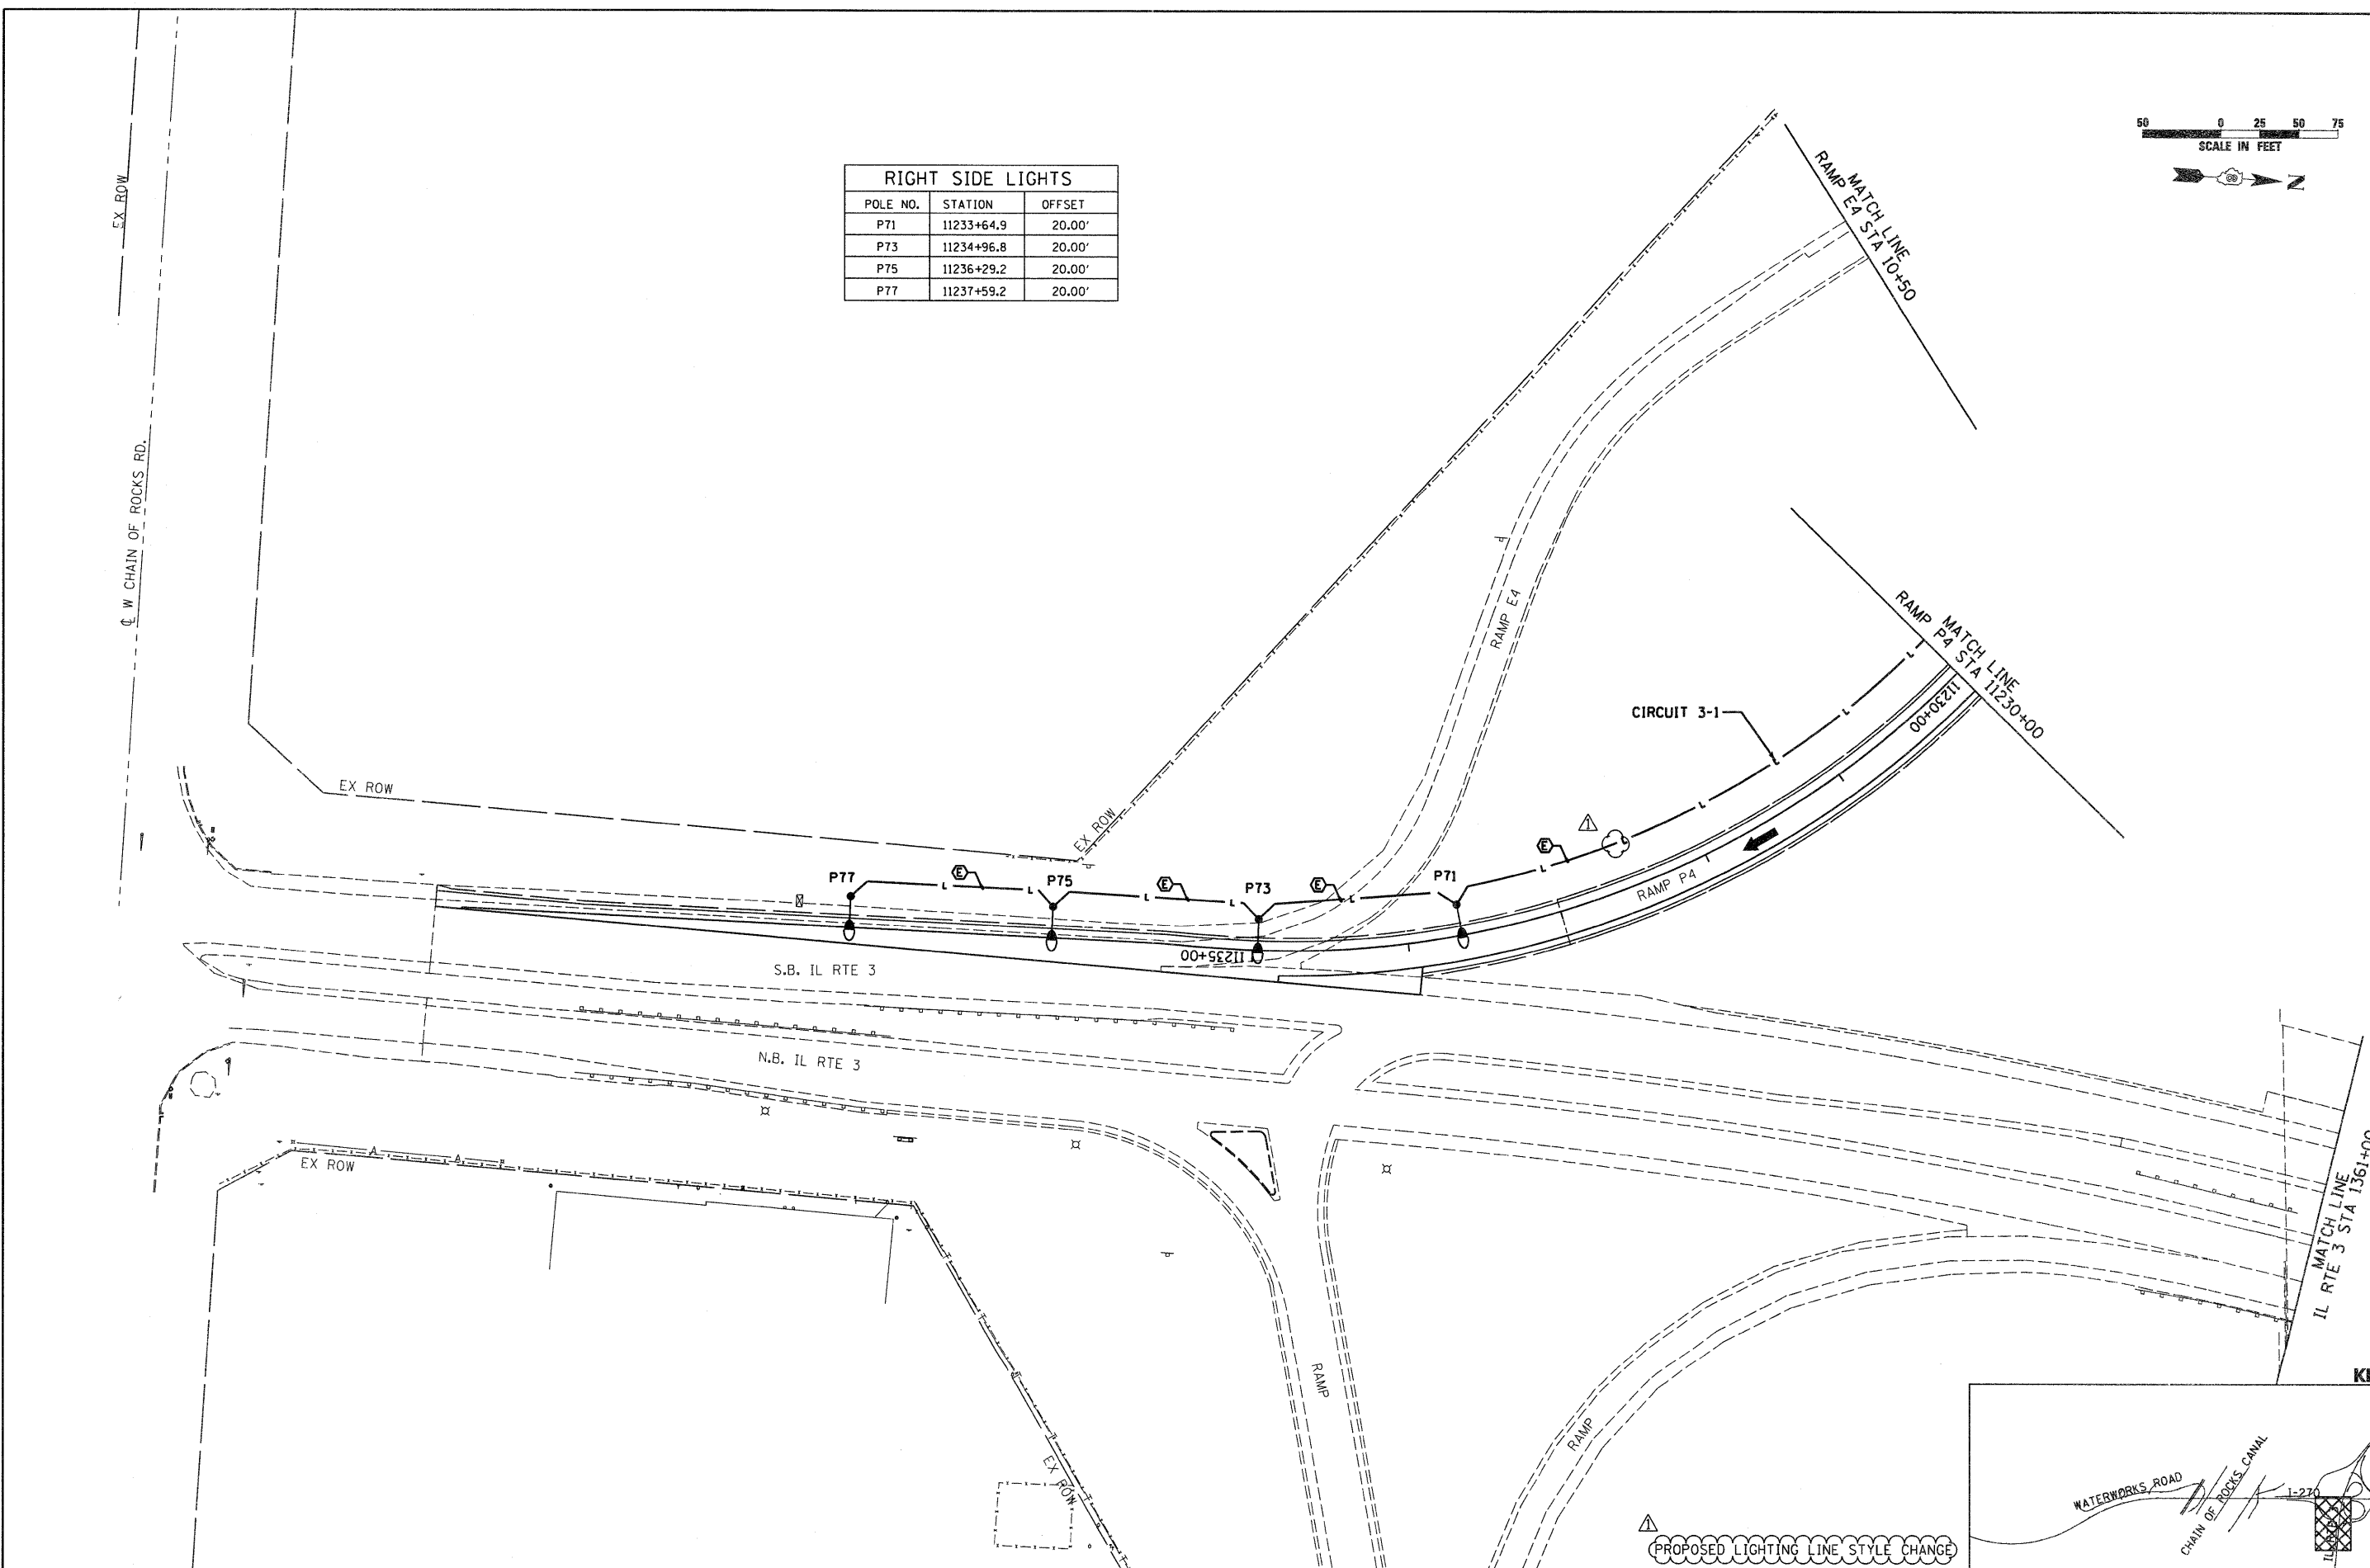

**KEY MAP**

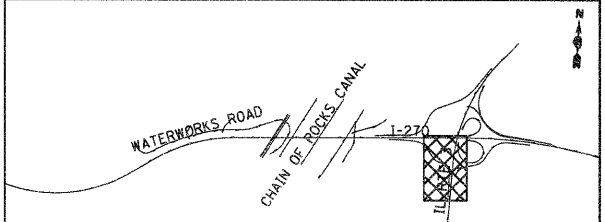

PROPOSED LIGHTING LINE STYLE CHANGE

FILE NAME =	USER NAME = #USER#	DESIGNED - FSM	REVISED -	<b>STATE OF ILLINOIS DEPARTMENT OF TRANSPORTATION</b>	<b>HIGHWAY LIGHTING PLANS IL RTE 3</b>	FA1	SECTION	COUNTY	TOTAL SHEETS	SHEET NO.	
#FILEL#	PLOT SCALE = #SCALE#	DRAWN - MNR	REVISED -			270	60-1B-1	MADISON	712	336	
	PLOT DATE = #DATE#	CHECKED - AAB	REVISED - 6/7/11 ADDENDUM			CONTRACT NO. 76A91					
		DATE - 3/18/11	REVISED -			ILLINOIS FED. AID PROJECT					
					SCALE: 1" = 50'	SHEET NO. 8 OF 10 SHEETS		STA. 1375+20 TO STA. 1361+00			