



RIGHT SIDE LIGHTS		
POLE NO.	STATION	OFFSET
P70	21165+25.6	20.00'

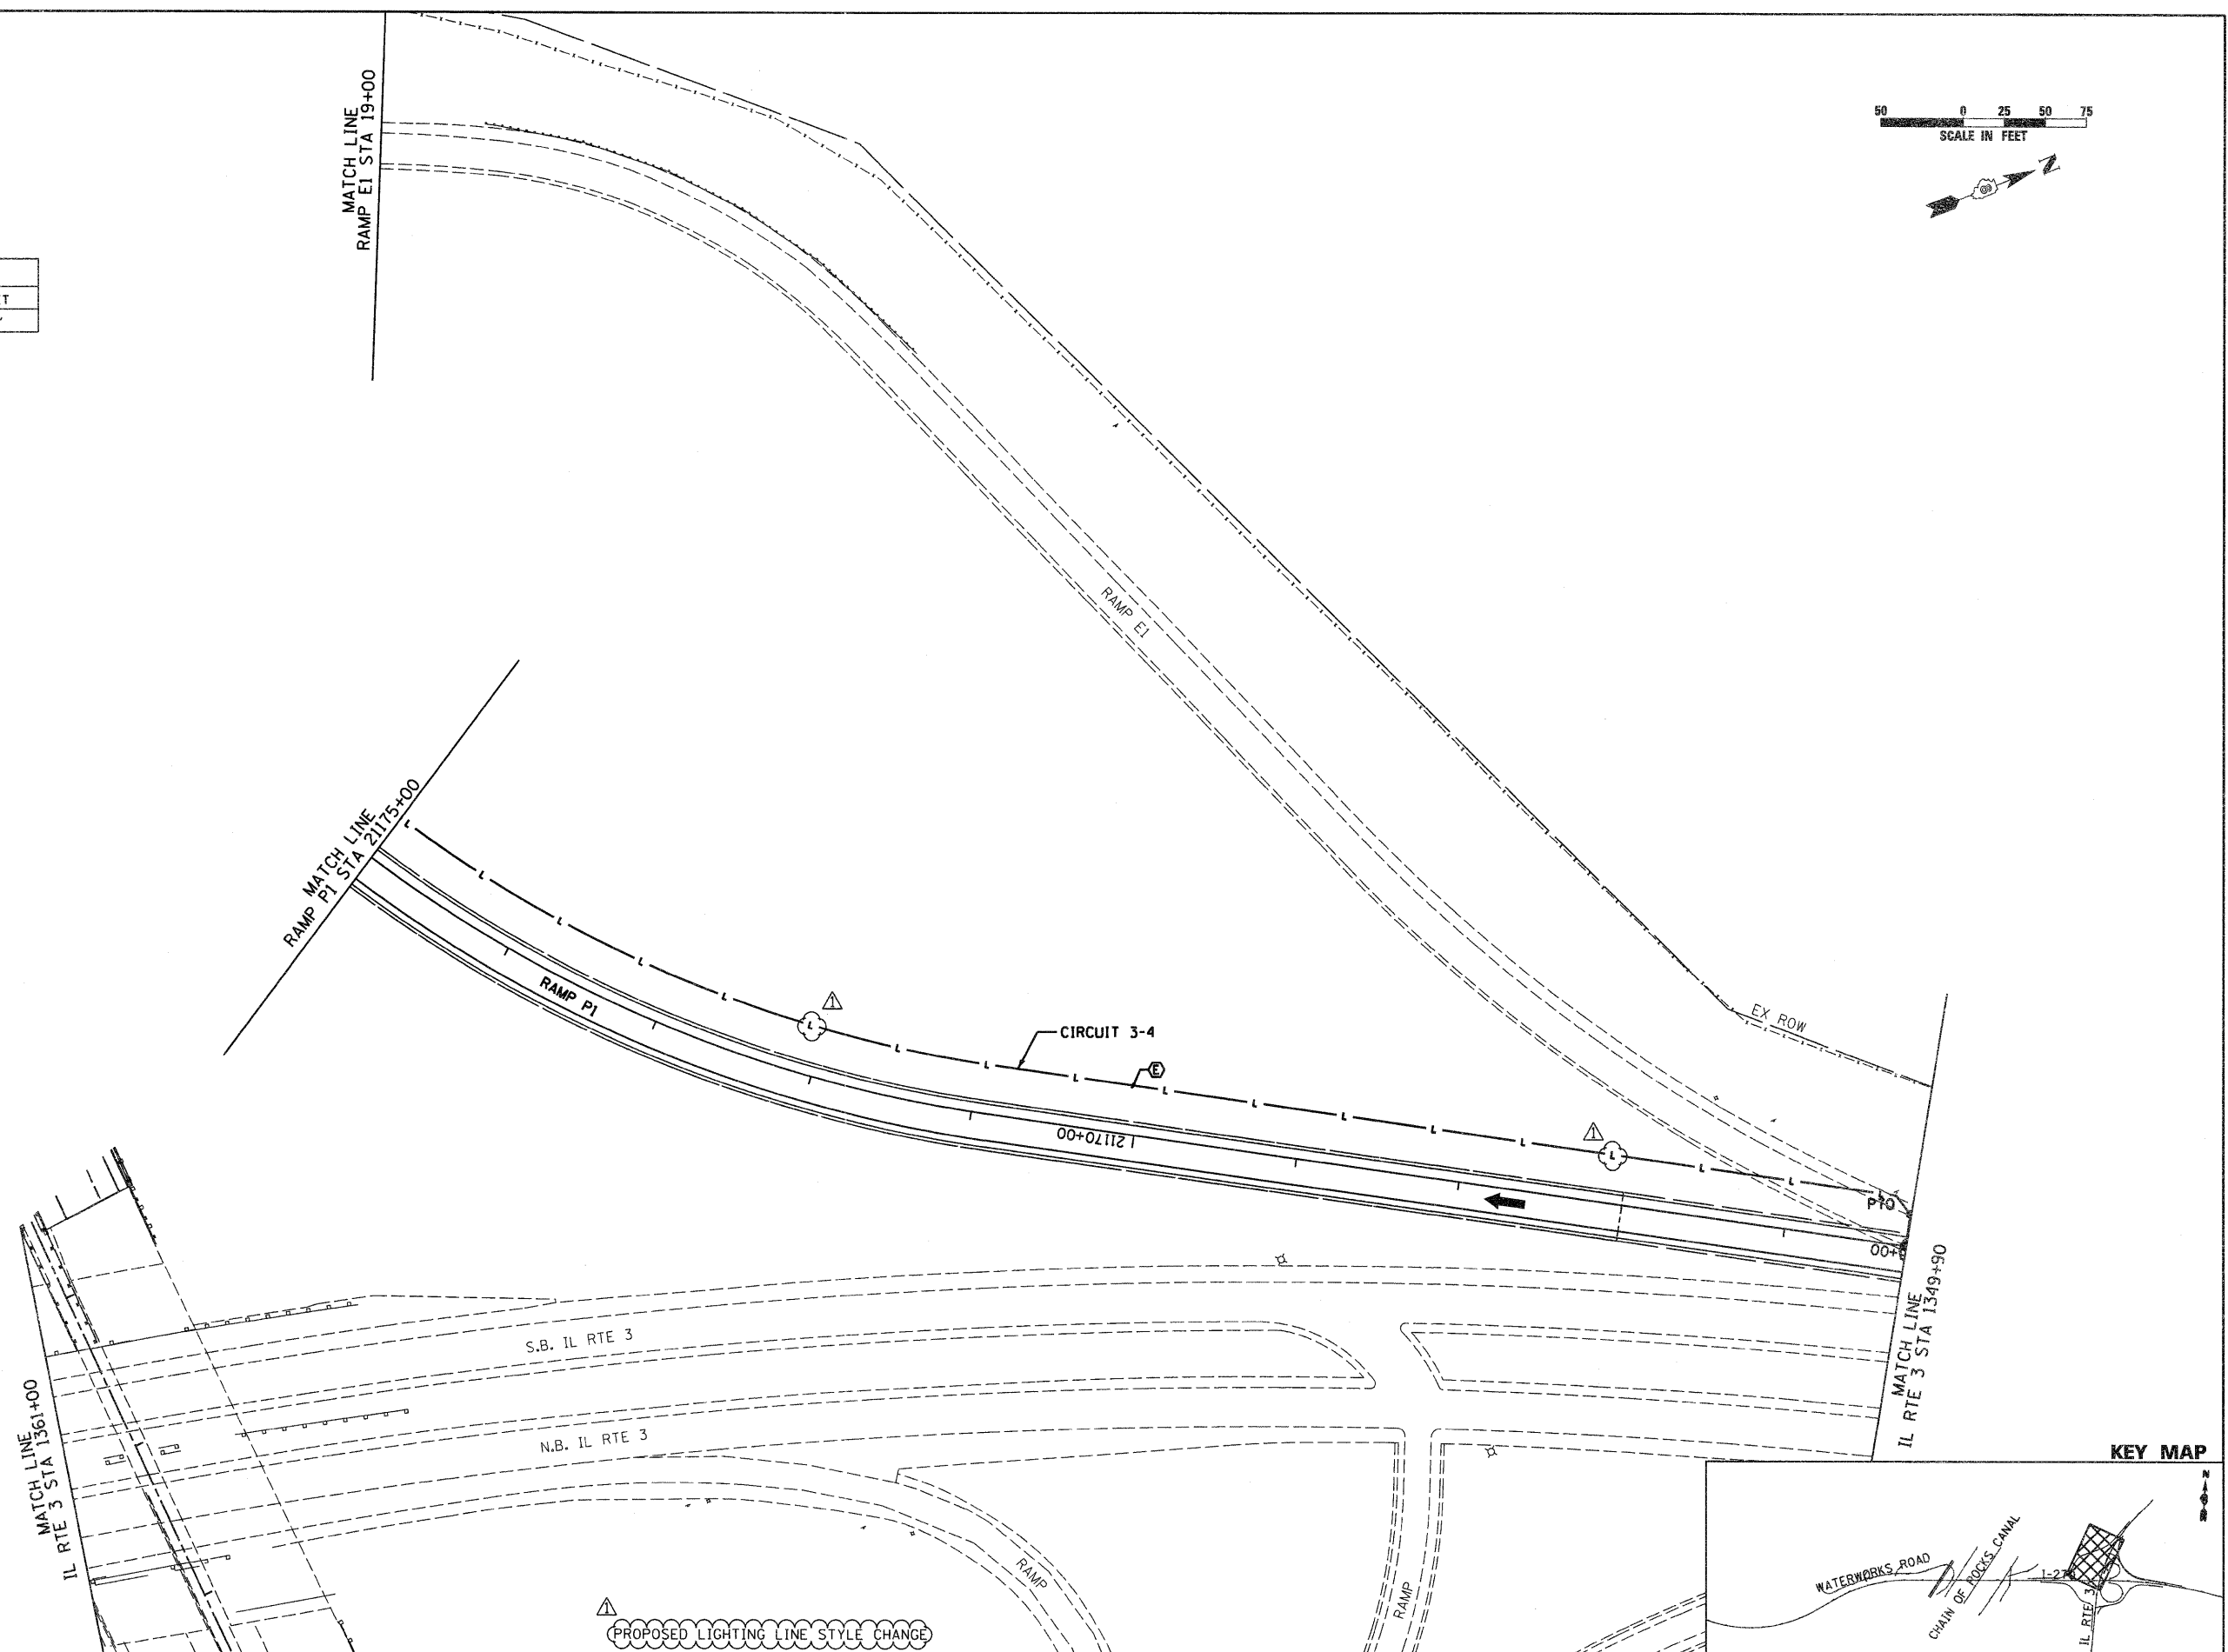

KEY MAP

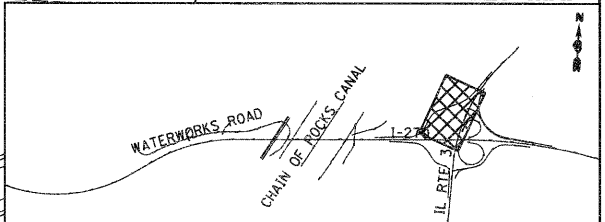

FILE NAME =	USER NAME = #USER#	DESIGNED - FSM	REVISED -	STATE OF ILLINOIS DEPARTMENT OF TRANSPORTATION	HIGHWAY LIGHTING PLANS IL RTE 3	FAI	SECTION	COUNTY	TOTAL SHEETS	SHEET NO.	
#FILE#		DRAWN - MNR	REVISED -			270	60-1B-1	MADISON	712	337	
	PLOT SCALE = #SCALE#	CHECKED - AAB	REVISED - 6/7/11 ADDENDUM			CONTRACT NO. 76A91					
	PLOT DATE = #DATE#	DATE - 3/18/11	REVISED -			ILLINOIS FED. AID PROJECT					
				SCALE: 1" = 50'		SHEET NO. 9 OF 10 SHEETS		STA. 1361+00 TO STA. 1349+90			