


NOTES:

1. SEE DRAWING ME-01 FOR ELECTRICAL SYMBOLS AND ABBREVIATIONS.
2. SEE DRAWING ES-01 FOR HIGH MAST TOWER FOUNDATION SCHEDULE.
3. COORDINATE ALL WORK WITH IDOT CONTRACT NOS. 76C49, 76C50, 76C51, 76C52, 76C53, 76C55, 76C75, AND 76C76.
4. THE TRANSITION FOR THE LIGHTING CIRCUIT FROM GRADE INTO THE PARAPET WALL SHALL BE DONE ACCORDING TO THE OPEN ABUTMENT CONDUIT DETAIL SHOWN ON DRAWING LGT002B.
5. THE LOCATIONS OF THE PROPOSED CABLES, CONDUITS AND SLEEVES SHOW ON THIS DRAWING ARE DIAGRAMMATIC ONLY. IT IS THE CONTRACTOR'S RESPONSIBILITY TO COORDINATE ALL WORK WITH OTHER CONCURRENT IDOT CONTRACTS SO THAT THE PROPOSED CABLES, CONDUITS AND SLEEVES SHOWN ON THIS DRAWING ARE INSTALLED IN A LOCATION THAT DOES NOT INTERFERE OR CONFLICT WITH EXISTING UTILITIES AND WORK DONE IN OTHER CONCURRENT IDOT CONTRACTS.

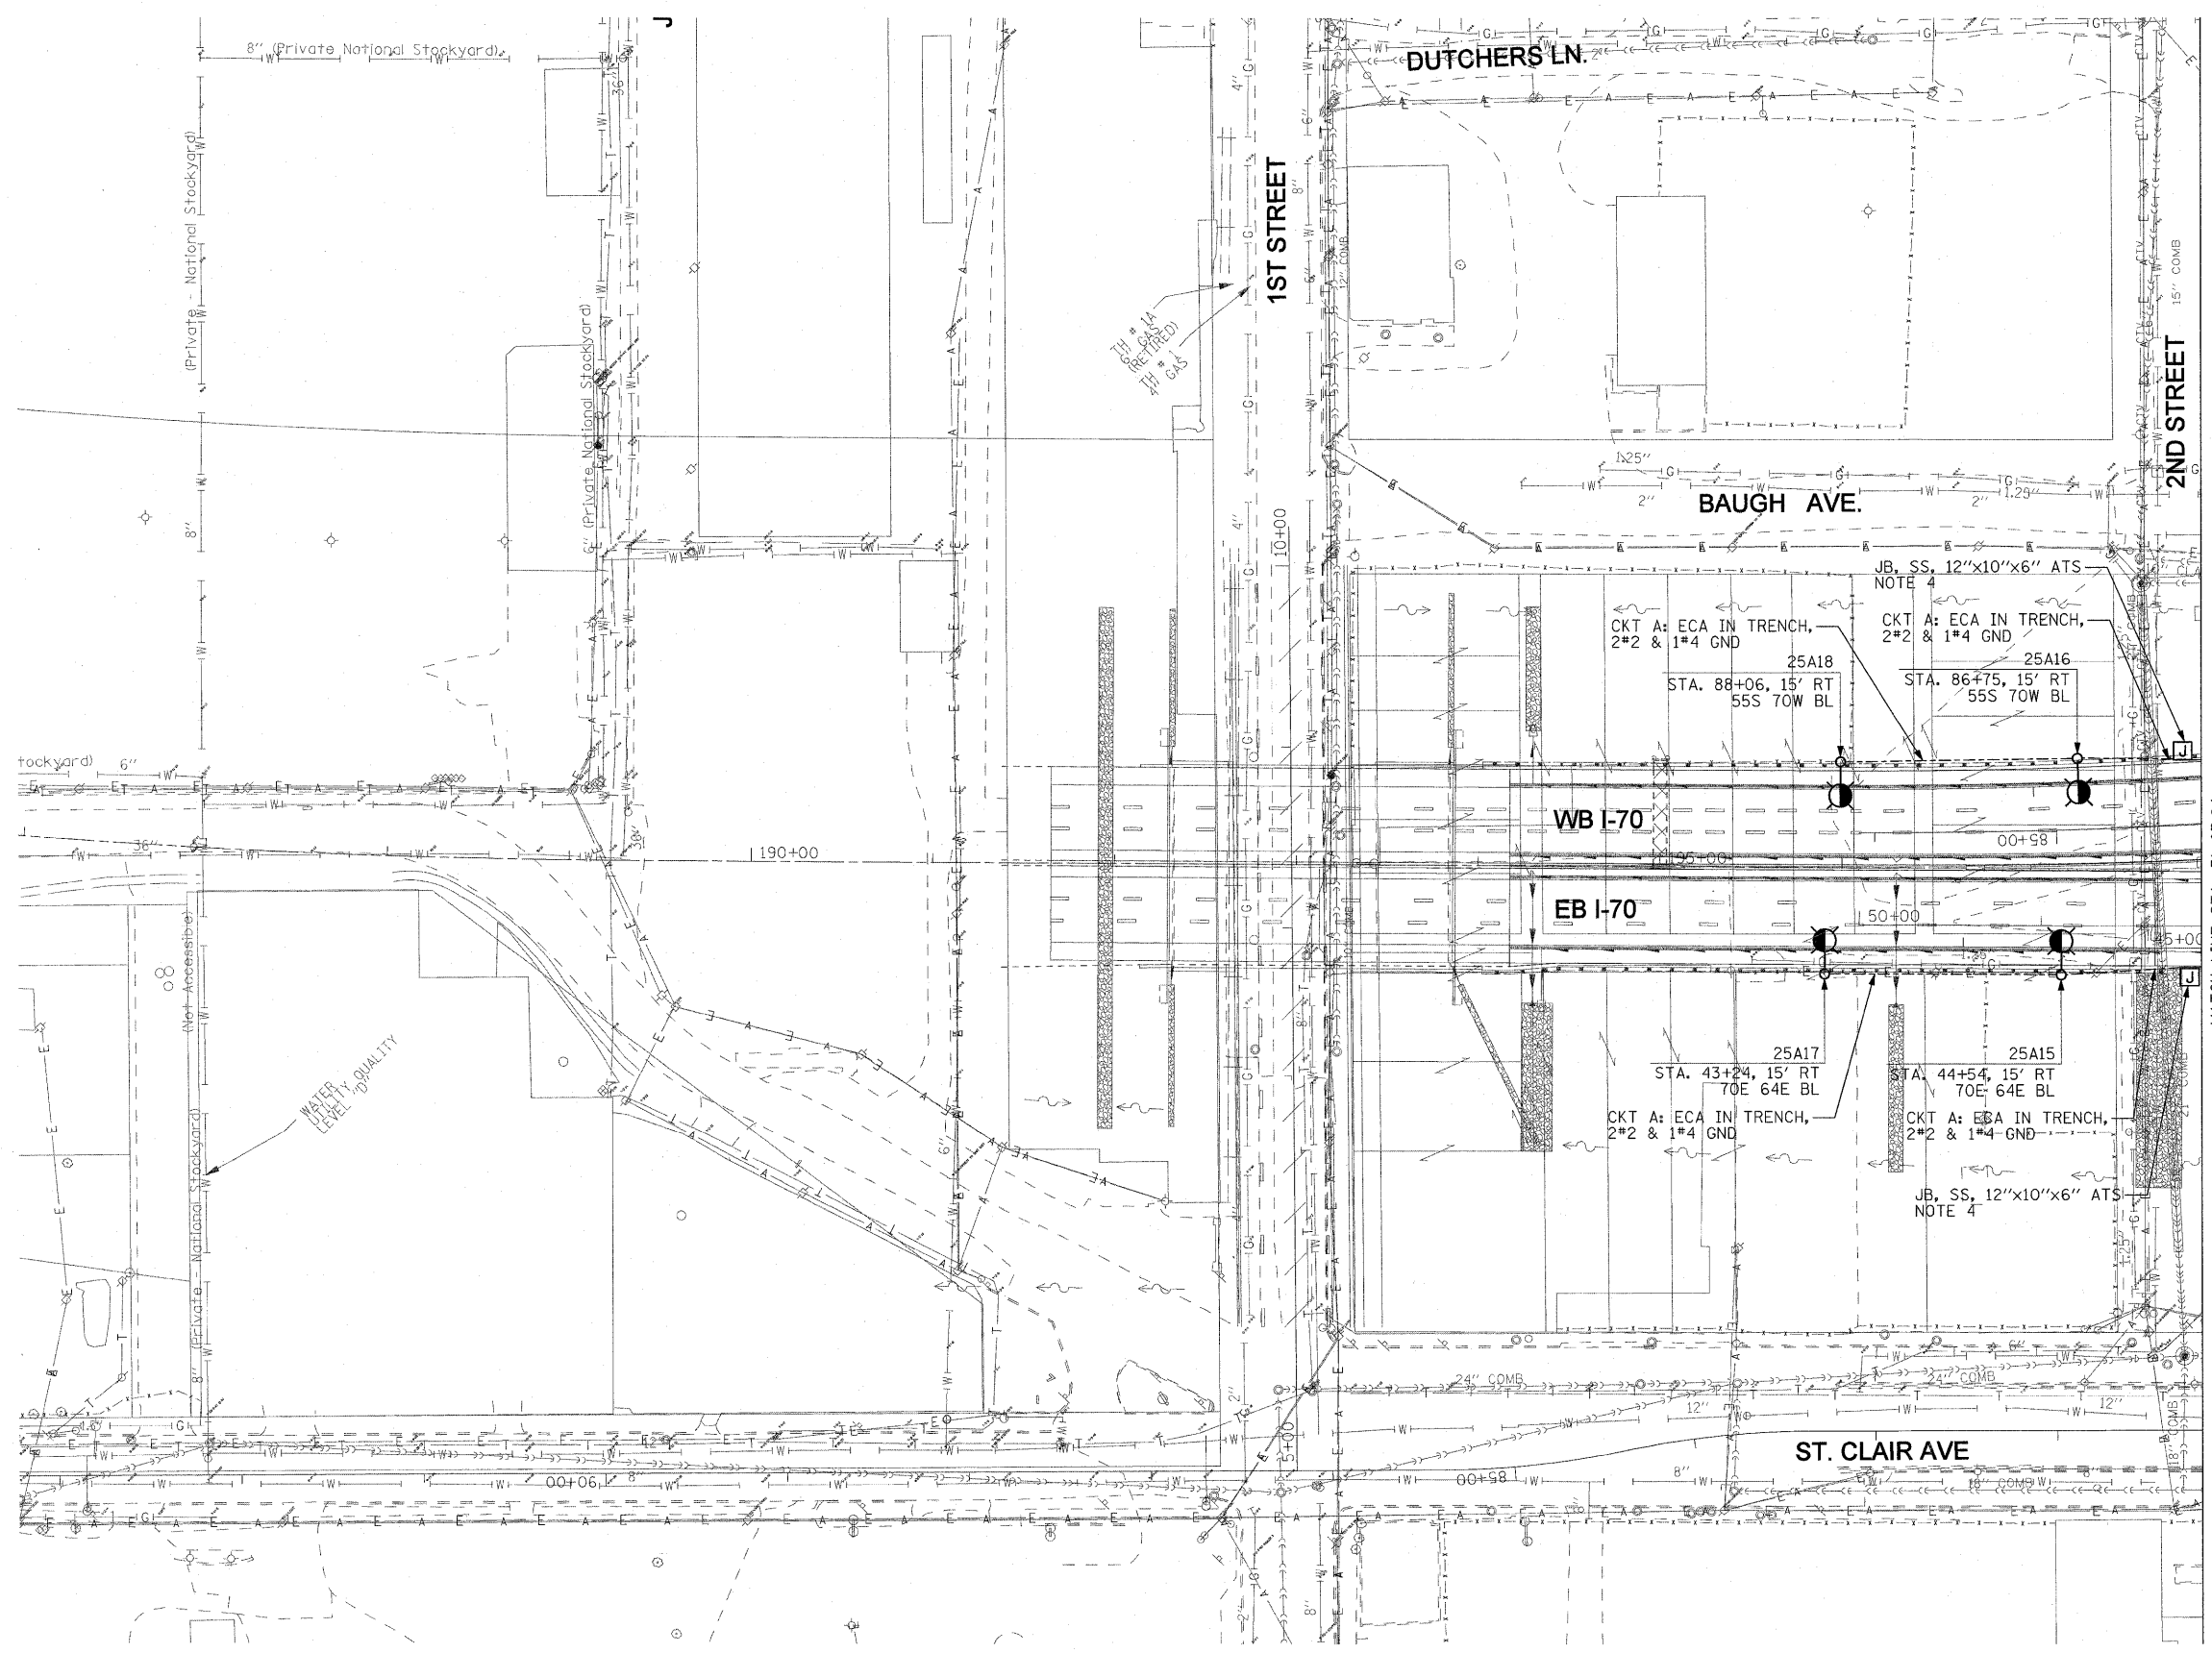

FILE NAME =	USER NAME = lents	DESIGNED - WDS	REVISED -	STATE OF ILLINOIS DEPARTMENT OF TRANSPORTATION	LIGHTING PLANS PROPOSED WORK	F.A.I. RTE.	SECTION	COUNTY	TOTAL SHEETS	SHEET NO.	
#FILE#	PLOT SCALE = 50.0001' / IN.	DRAWN - TL	REVISED -			55/64	82-1L	ST. CLAIR	60	46	
	PLOT DATE = 1/3/2011	CHECKED - JPC	REVISED -			CONTRACT NO. 76C54					
		DATE - JANUARY 4, 2011	REVISED -			FED. ROAD DIST. NO. ILLINOIS FED. AID PROJECT					
				SCALE: 1"=50'		SHEET NO. 1 OF 8 SHEETS		STA. TO STA. 51+87.84			

RL-01