


**Massie & Massie
Associates**

1210 S. 5th Street, Springfield, IL 62703 217-544-3210
421 West Main Street, Decatur, IL 62522 217-424-0792

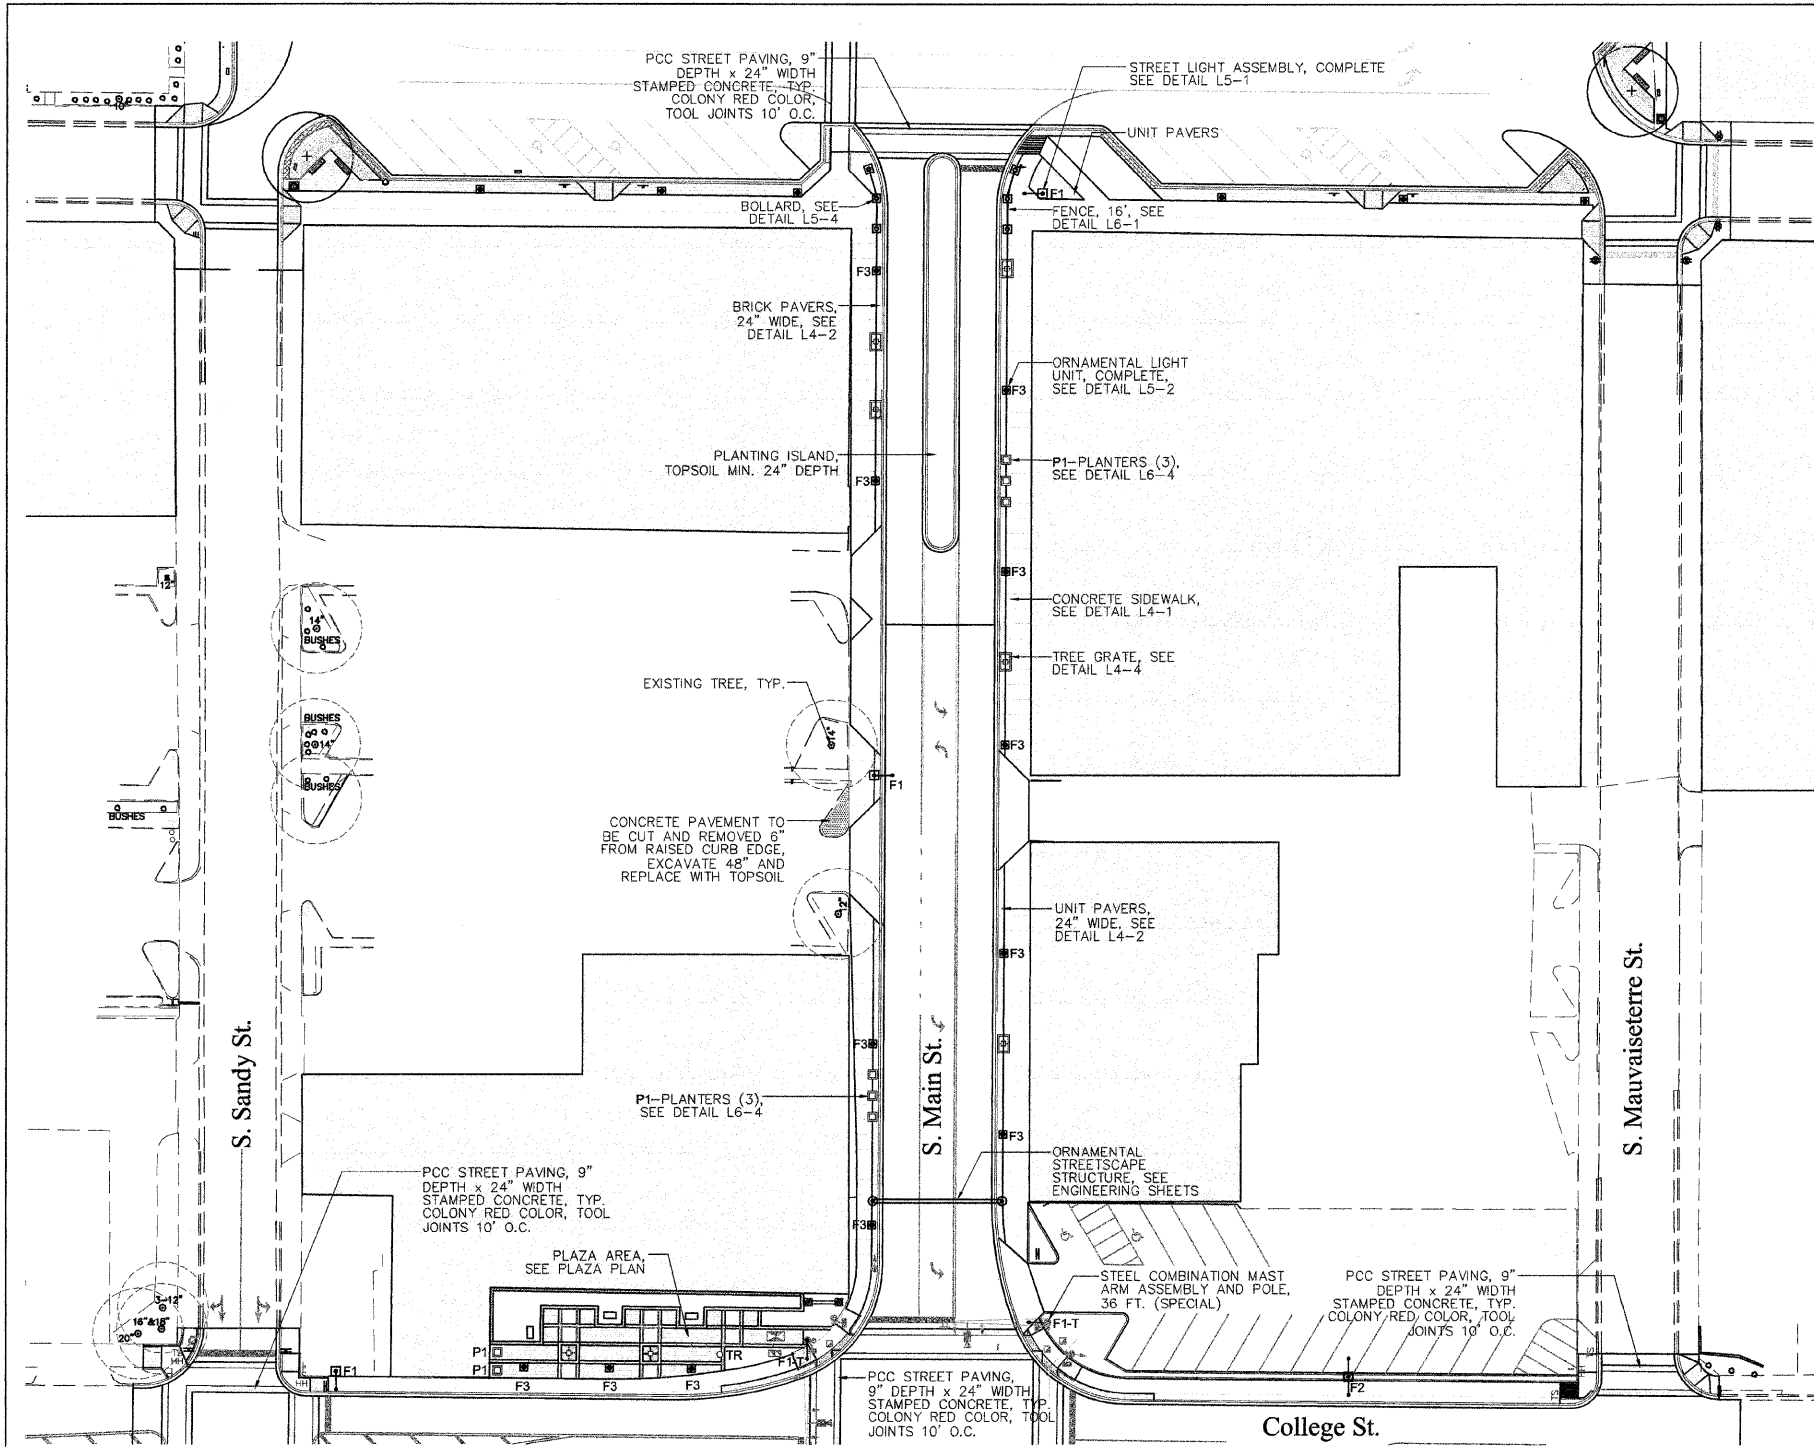


SITE FURNISHING AND MATERIAL SCHEDULE

Symbol	Label	Qty	Description	Finish	Color
F1	STREET LIGHTING ASSEMBLY COMPLETE, TYPE F1	3	SEE ELECTRICAL SHEETS FOR LUMINAIRE SCHEDULE AND PRODUCT INFORMATION		
F1-T	STEEL COMBINATION MAST ARM ASSEMBLY AND POLE, 36 FT. (SPECIAL)	2	SEE ELECTRICAL SHEETS FOR LUMINAIRE SCHEDULE AND PRODUCT INFORMATION		
F2	STREET LIGHTING ASSEMBLY COMPLETE, TYPE F2	1	SEE ELECTRICAL SHEETS FOR LUMINAIRE SCHEDULE AND PRODUCT INFORMATION		
F3	ORNAMENTAL LIGHT UNIT COMPLETE	12	SEE ELECTRICAL SHEETS FOR LUMINAIRE SCHEDULE AND PRODUCT INFORMATION		
B	BOLLARD	6	CAST ALUMINUM, 16" DIA. BASE, 58 1/2" HEIGHT	POWDER COAT	BLACK
F	ORNAMENTAL FENCE	32'	4' HIGH STEEL FENCE WITH DECORATIVE RING INSERTS	POWDER COAT	BLACK
TR	TRASH RECEPTACLE	1	STEEL, 36 GALLON WITH FORMED LID	POWDER COAT	BLACK
P1	PLANTER	8	REINFORCED PRECAST CONCRETE, 36" SQUARE, 36" HEIGHT	RECYCLED GLASS, WEATHERSTONE FINISH	CHARCOAL GLASS, GRAY MATRIX
TG	TREE GRATE RECTANGULAR	5	36"x60" TREE GRATE IN TWO SECTIONS 1/2" MAX. OPENINGS FOR ADA COMPLIANCE, 18" TREE OPENING	UNFINISHED	NATURAL
TG	TREE GRATE SQUARE	2	60"x60" TREE GRATE IN TWO SECTIONS 1/2" MAX. OPENINGS FOR ADA COMPLIANCE, 18" TREE OPENING	UNFINISHED	NATURAL
BP	BRICK PAVERS		HOLLAND PREMIER PAVER 4" X 8" X 2 3/4"	STANDARD	HERITAGE BROWN
PC	PCC PAVING 9" STAMPED CONCRETE		STAMPED AND COLORED CONCRETE	SEALANT AND ANTI-SKID AGENT	COLONY RED W/ CHARCOAL RELEASE

CONCRETE SCORING AND FINISHING:

- All scoring to be tooled, no saw cutting.
- Score concrete sidewalk 5'x5'. Start grid pattern at corner crosswalks in line with top of crosswalk ramp. Subsequent scoring to be 5' O.C. until approximately 20' of midblock alley or corner crosswalk. Joints between this distance should be spaced equally, approximately 5' O.C.
- Concrete sidewalks to have medium-broom finish perpendicular to building face (pedestrian traffic flow).
- Expansion joints to be located at corner crosswalk locations. Subsequent expansion joints to be maximum 30' O.C.

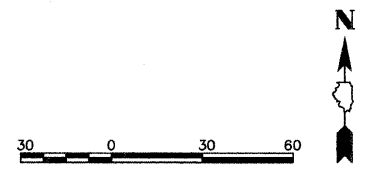

FILE NAME =	USER NAME =	DESIGNED -- SM	REVISED --
\$FILEL\$		DRAWN -- NFB	REVISED --
	PLOT SCALE = 1" = 30'	CHECKED -- SM	REVISED --
	PLOT DATE = 2-8-2011	DATE -- 2-8-2011	REVISED --

STATE OF ILLINOIS
DEPARTMENT OF TRANSPORTATION

CITY OF JACKSONVILLE DOWNTOWN MAIN STREET IMPROVEMENTS	
MATERIAL PLAN - MAIN ST. NORTH OF COLLEGE	
SCALE: 1"=30'	SHEET NO. -- OF -- SHEETS
STA. _____	TO STA. _____

F.A. RTE.	SECTION	COUNTY	TOTAL SHEETS	SHEET NO.
N/A	10-00121-01-PV	MORGAN	77	44
CONTRACT NO. 93547				
FED. ROAD DIST. NO. -- ILLINOIS FED. AID PROJECT				