
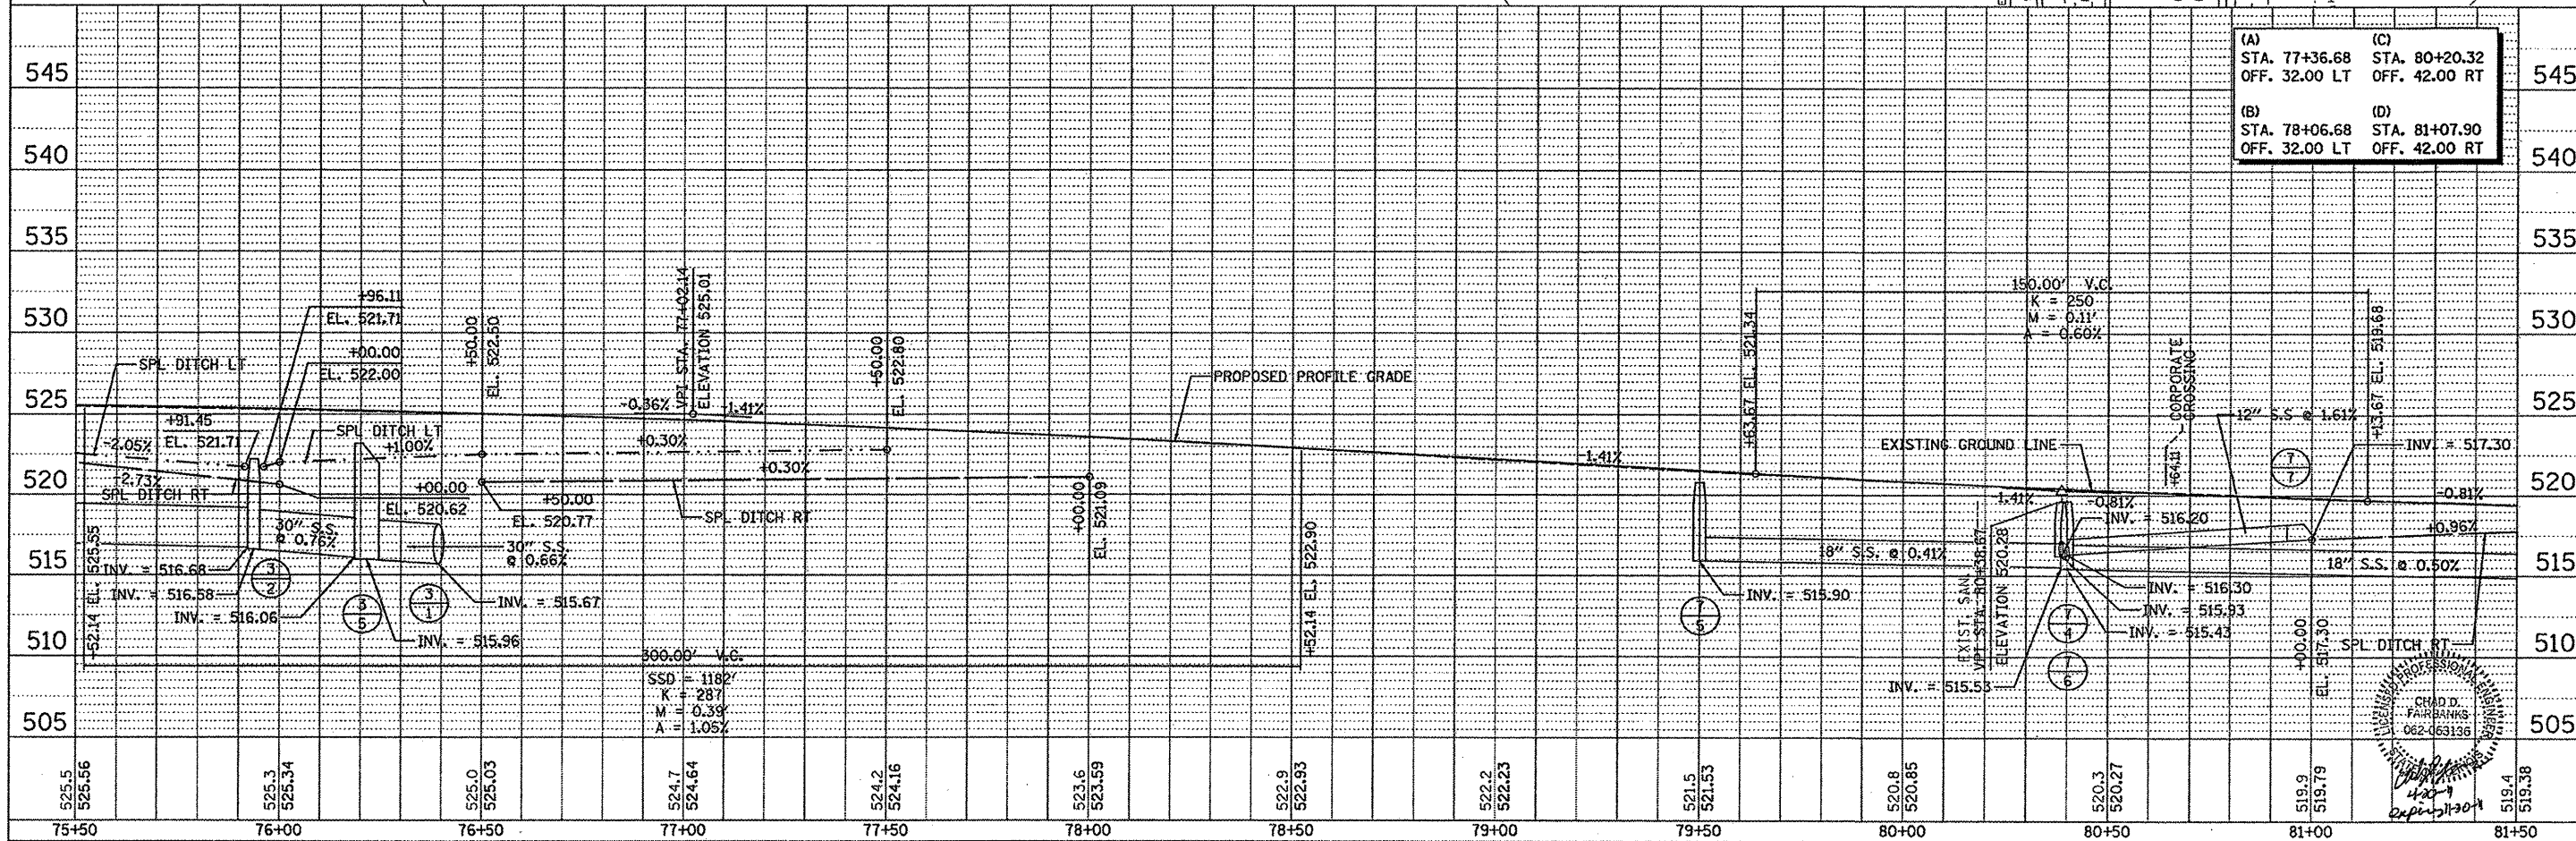
 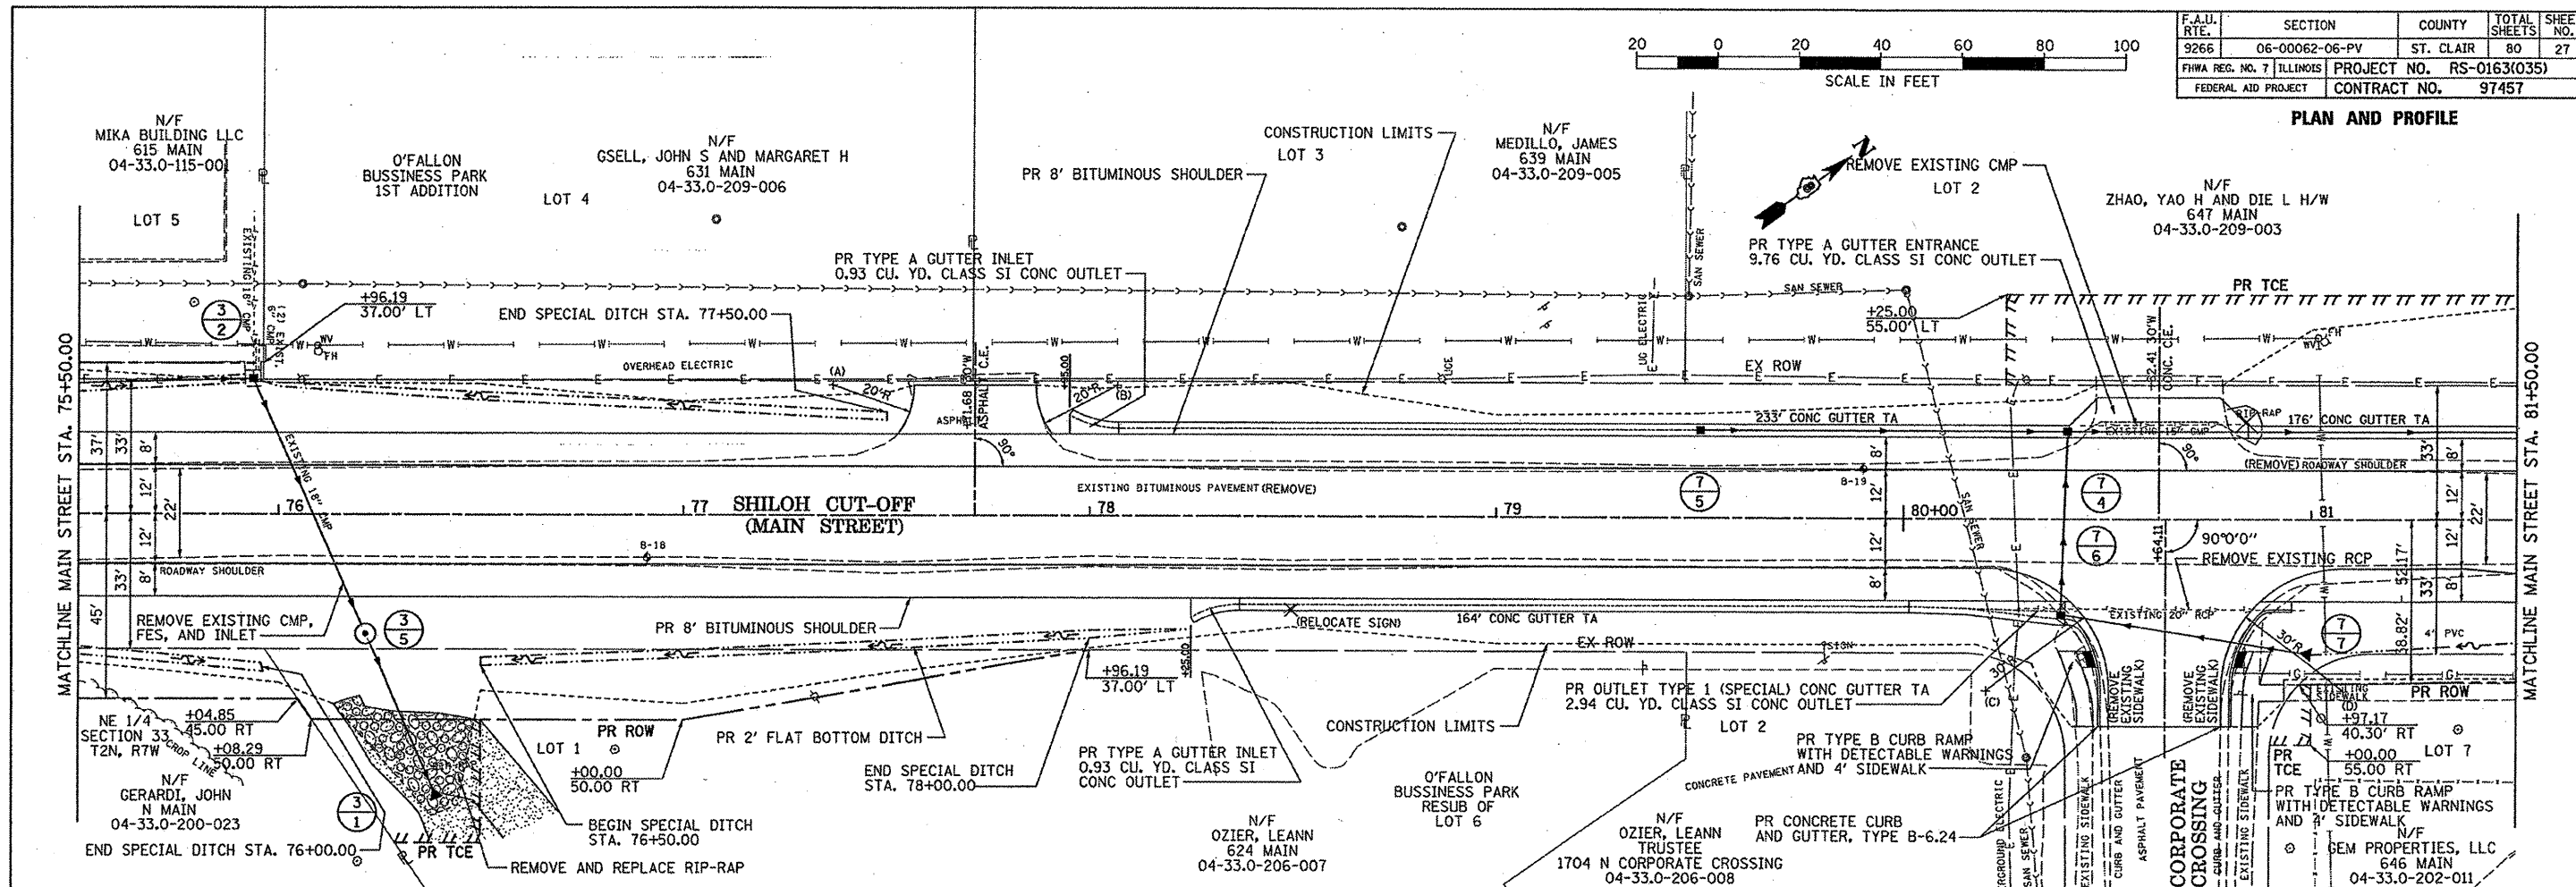


F.A.I. RITE	SECTION	COUNTY	TOTAL SHEETS	SHEET NO.
9266	06-00062-06-PV	ST. CLAIR	80	27
FHWA REG. NO. 7	ILLINOIS PROJECT NO.	RS-0163035)		
FEDERAL AID PROJECT	CONTRACT NO.		97457	

**PLAN AND PROFILE**



CHAD D. FARBER  
 PROFESSIONAL ENGINEER  
 062-463136  
 4-27-20  
 2021-11-30