

F.A.S. RTE.	SECTION	COUNTY	TOTAL SHEETS	SHEET NO.
	21-00062-04-SW	MONROE	14	1
ILLINOIS			CONTRACT NO. 97775	

STATE OF ILLINOIS
DEPARTMENT OF TRANSPORTATION
PLANS FOR PROPOSED
FEDERAL AID HIGHWAY

ITEP FUNDING

FAS 850 - COUNTRY CLUB LANE - C.H. 2
FAU 9322 - HH ROAD AND FAP 312 - IL RTE 3
NORTH WATERLOO PEDESTRIAN CROSSING
SECTION 21-00062-04-SW
PROJECT NO. NU63(081)
COUNTY OF MONROE
JOB NO. C-98-065-22




LOCATION OF SECTION INDICATED THUS:

- INDEX OF SHEETS
- COVER SHEET
 - GENERAL NOTES, COMMITMENTS AND HIGHWAY STANDARDS
 - SUMMARY OF QUANTITIES
 - TYPICAL SECTIONS
 - SCHEDULE OF QUANTITIES
 - PLAN AND PROFILE
 - PAVEMENT MARKING PLAN
 - 8-9. ADA DETAILS
 - TRAFFIC SIGNAL GENERAL NOTES, SUMMARY OF QUANTITIES, & DETAILS
 - TRAFFIC SIGNAL PLAN
 - TRAFFIC SIGNAL CABLE DIAGRAM
 - TRAFFIC SIGNAL PEDESTRIAN PUSH-BUTTON DETAIL
 - UTILITIES**

STRUCTURE NUMBERS
NONE

SCALES
PLAN 1" = 50'
PROFILE 1" = 25'

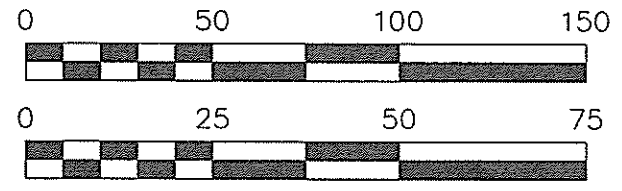

DESIGN CLASSIFICATION

ROAD NAME = IL RT 3/ HH RD/ COUNTRY CLUB LANE
RD CLASS. = PRINCIPAL ARTERIAL/MAJOR COLLECTOR/MAJOR COLLECTOR
2019 ADT = 25000 VPD/ 3000 VPD/ 4600 VPD
DESIGN SPEED: 50 MPH/40 MPH/35 MPH
POSTED SPEED: 45 MPH/35 MPH/ 30 MPH

UTILITIES

CALL J.U.L.I.E. BEFORE YOU DIG
800-892-0123

ELECTRIC:

CITY OF WATERLOO
WATERLOO, IL 62298
(618) 939-8600

MONROE COUNTY ELECTRIC CO-OP
WATERLOO, IL 62298
(618) 939-7171

TELEPHONE:

HARRISONVILLE TELEPHONE COMPANY
WATERLOO, ILLINOIS 62298
(618) 939-6112

GAS:

AMEREN ILLINOIS
BELLEVILLE, ILLINOIS 62221
(618) 236-4372


CITY OF WATERLOO
WATERLOO, IL 62298
(618) 939-8600

WATER:

CITY OF WATERLOO
WATERLOO, IL 62298
(618) 939-8600

CABLE TV:

CHARTER COMMUNICATIONS
MARYVILLE, IL 62062
(618) 345-8003

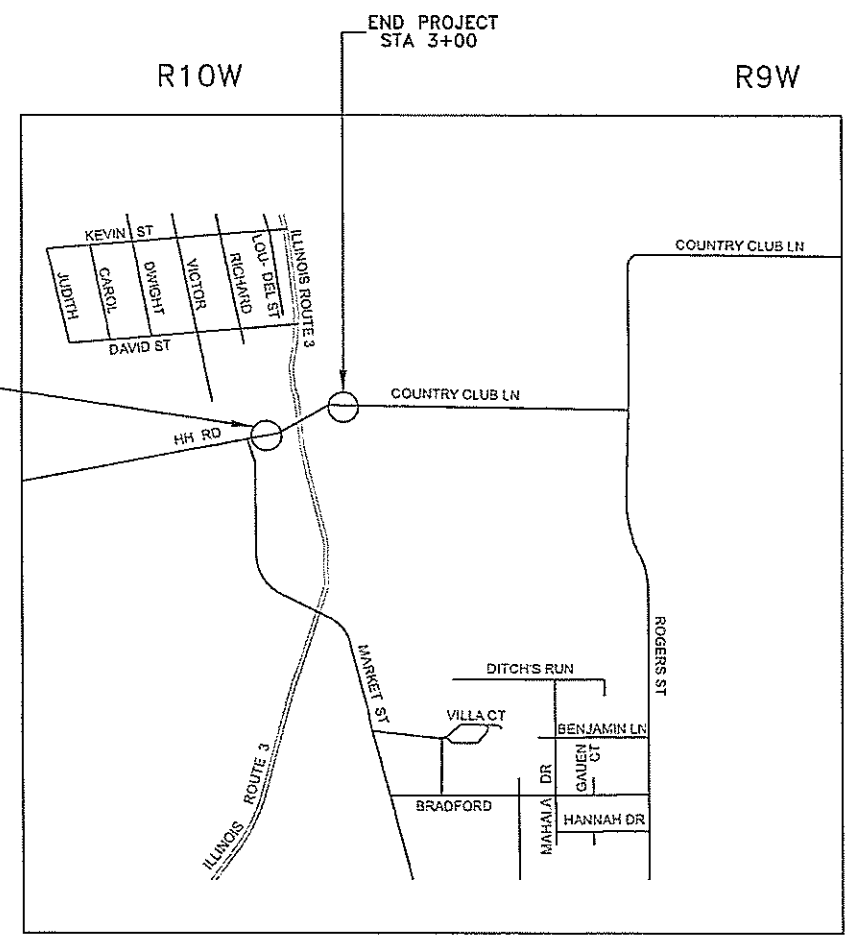

LOCATION MAP

GROSS LENGTH = 600.00 FEET = 0.114 MILES
NET LENGTH = 600.00 FEET = 0.114 MILES

DRAWN BY CASEY L. CARNAHAN DATE 03/24/2022
CHECKED BY AARON W. REITZER DATE 03/24/2022

DESIGN CERTIFICATION
REGISTERED PROFESSIONAL
These plans were prepared by me or a full time member of my staff under my personal supervision.

County Engineer Date 3-25-22
Illinois Registered Professional Engineer No. 055382
Expiration Date: 11/30/23

STATE OF ILLINOIS
DEPARTMENT OF TRANSPORTATION
APPROVED March 25 20 22

Monroe County Engineer
Monroe County Highway Department

Passed 3/30 20 22

District 8 Engineer
Local Roads and Streets


Released for Bid Based on Limited Review 3/30 20 22

Region 5 Engineer

PRINTED BY THE AUTHORITY
OF THE STATE OF ILLINOIS

DRAWING FILE: S:\NORTH WATERLOO PEDESTRIAN CROSSING\COVER

Revised 6/6/2022

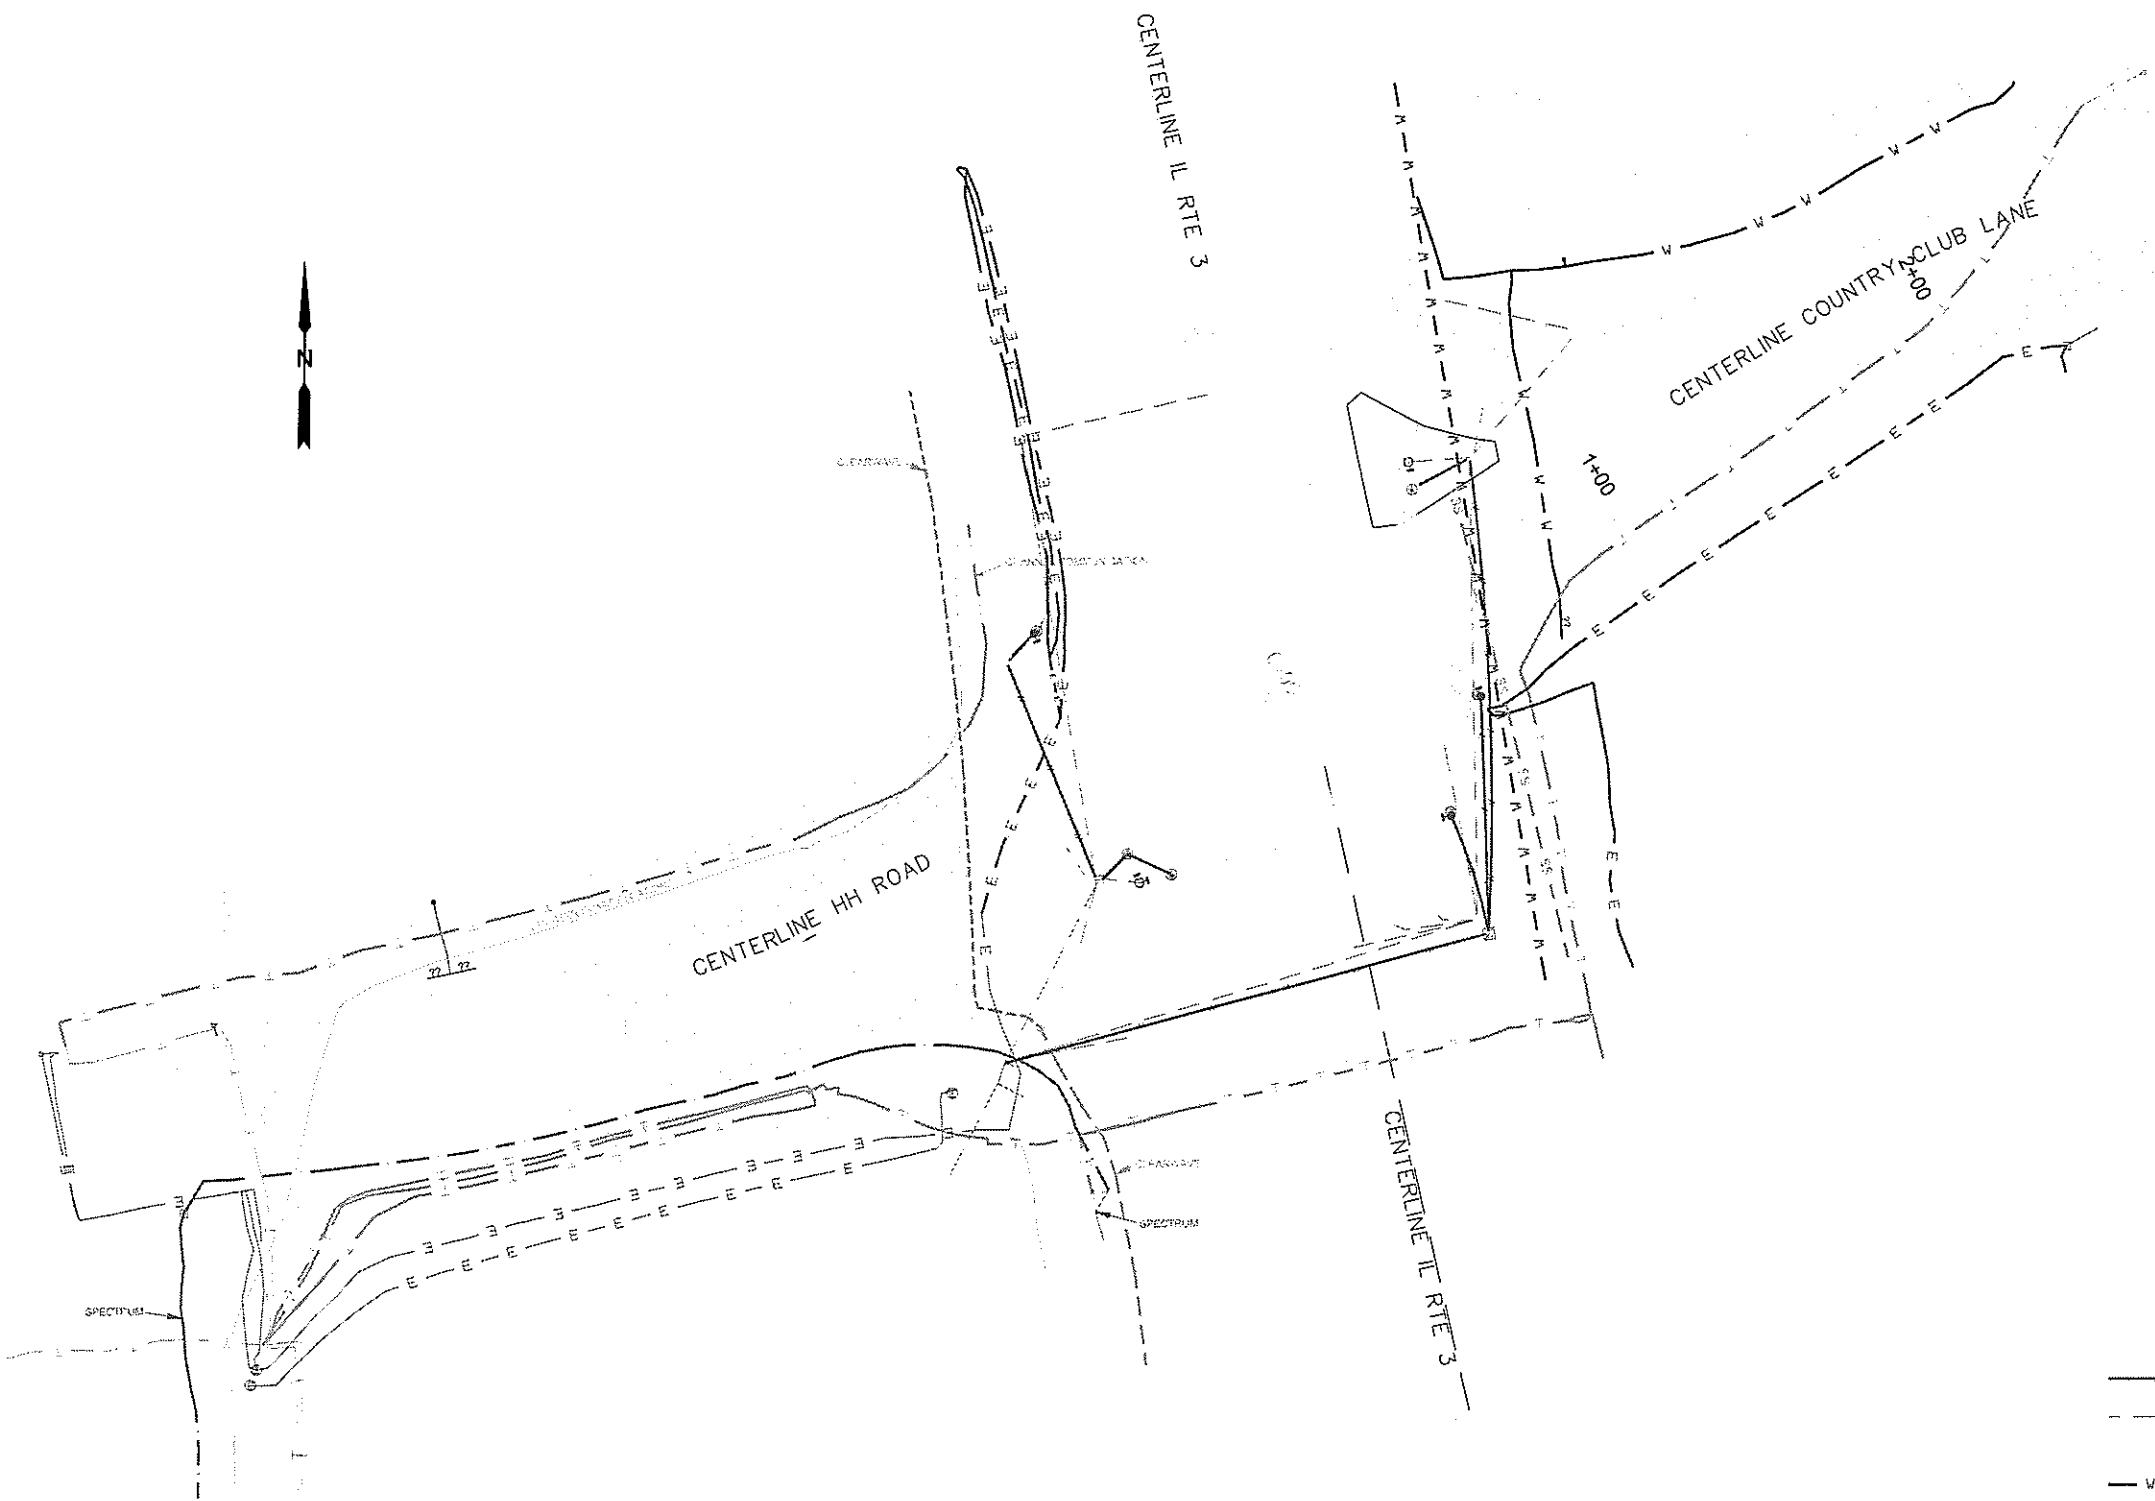

- 1- PROPOSED PEDESTRIAN SIGNAL
- ⊕ PROPOSED PED. PUSHBUTTON BASE
- PROPOSED SIGNAL CONDUIT
- - - - - EXISTING SIGNAL CONDUIT
- W — W — W — W — W — W — W — W — AMEREN GAS LINE
- E — E — E — E — E — E — E — E — MONROE COUNTY ELECTRIC
- - - - - HARRISONVILLE TELEPHONE COMPANY
- - - - - CLEARWAVE COMMUNICATIONS
- - - - - CHARTER COMMUNICATIONS
- - - - - SPECTRUM CABLE
- - - - - CHANNEL COMMUNICATIONS
- - - - - CITY OF WATERLOO SANITARY SEWER

Added 6/6/2022

USER NAME *	DESIGNED -	REVISED -	MONROE COUNTY HIGHWAY DEPARTMENT	UTILITIES				F.A. RTE.	SECTION	COUNTY	TOTAL SHEETS	SHEET NO.
PLOT SCALE *	DRAWN -	REVISED -		SCALE: SHEET OF SHEETS STA. TO STA.				21-00062-04-SW	MONROE	14	14	
PLOT DATE *	CHECKED -	REVISED -						CONTRACT NO. 97775				
	DATE -	REVISED -						ILLINOIS FED. AID PROJECT				