 



MATCHLINE STA. 610+00

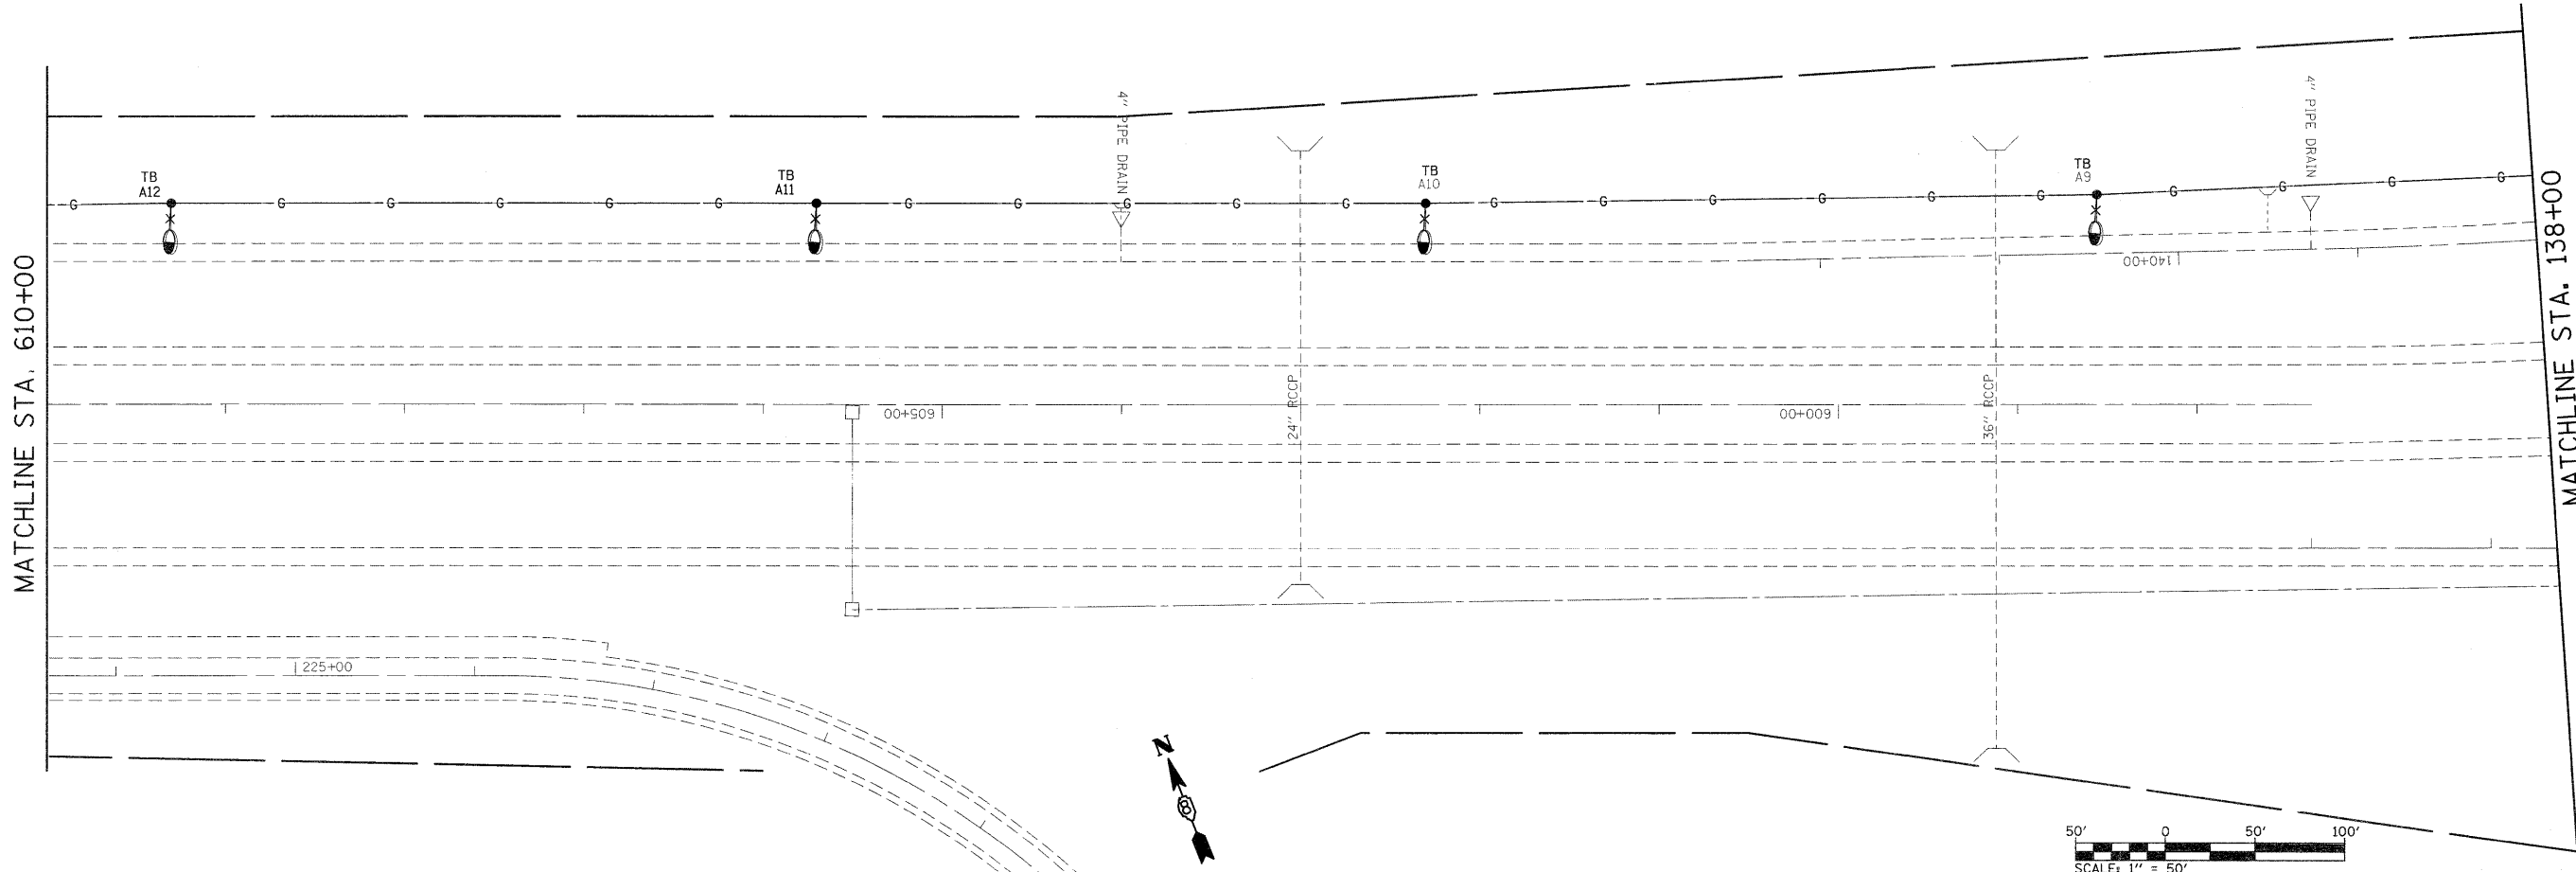

MATCHLINE STA. 610+00

MATCHLINE STA. 138+00

FILE NAME =	USER NAME = prestone	DESIGNED -	REVISED -	<b>STATE OF ILLINOIS DEPARTMENT OF TRANSPORTATION</b>	<b>CONTROLLERS #1 &amp; #3 SHTS. 1A &amp; 1B OF 7 LIGHTING PLAN</b>	F.A.I. RTE.	SECTION	COUNTY	TOTAL SHEETS	SHEET NO.	
c:\pwork\pwork\prestone\dms65337\d878c09-shit-light.dgn		DRAWN -	REVISED -			255	DIST. 8 LIGHT POLE 2009-1	*	146	42	
PLOT SCALE = 50.0000' / IN.		CHECKED -	REVISED -			CONTRACT NO. <b>76C09</b>					
PLOT DATE = 6/8/2010		DATE -	REVISED -			FED. ROAD DIST. NO. - ILLINOIS FED. AID PROJECT					