 



MATCHLINE STA. 345+00

SEE SHT. 4A/6  
MATCHLINE STA. 25+00

MATCHLINE STA. 332+00  
SEE SHT. 5A/6

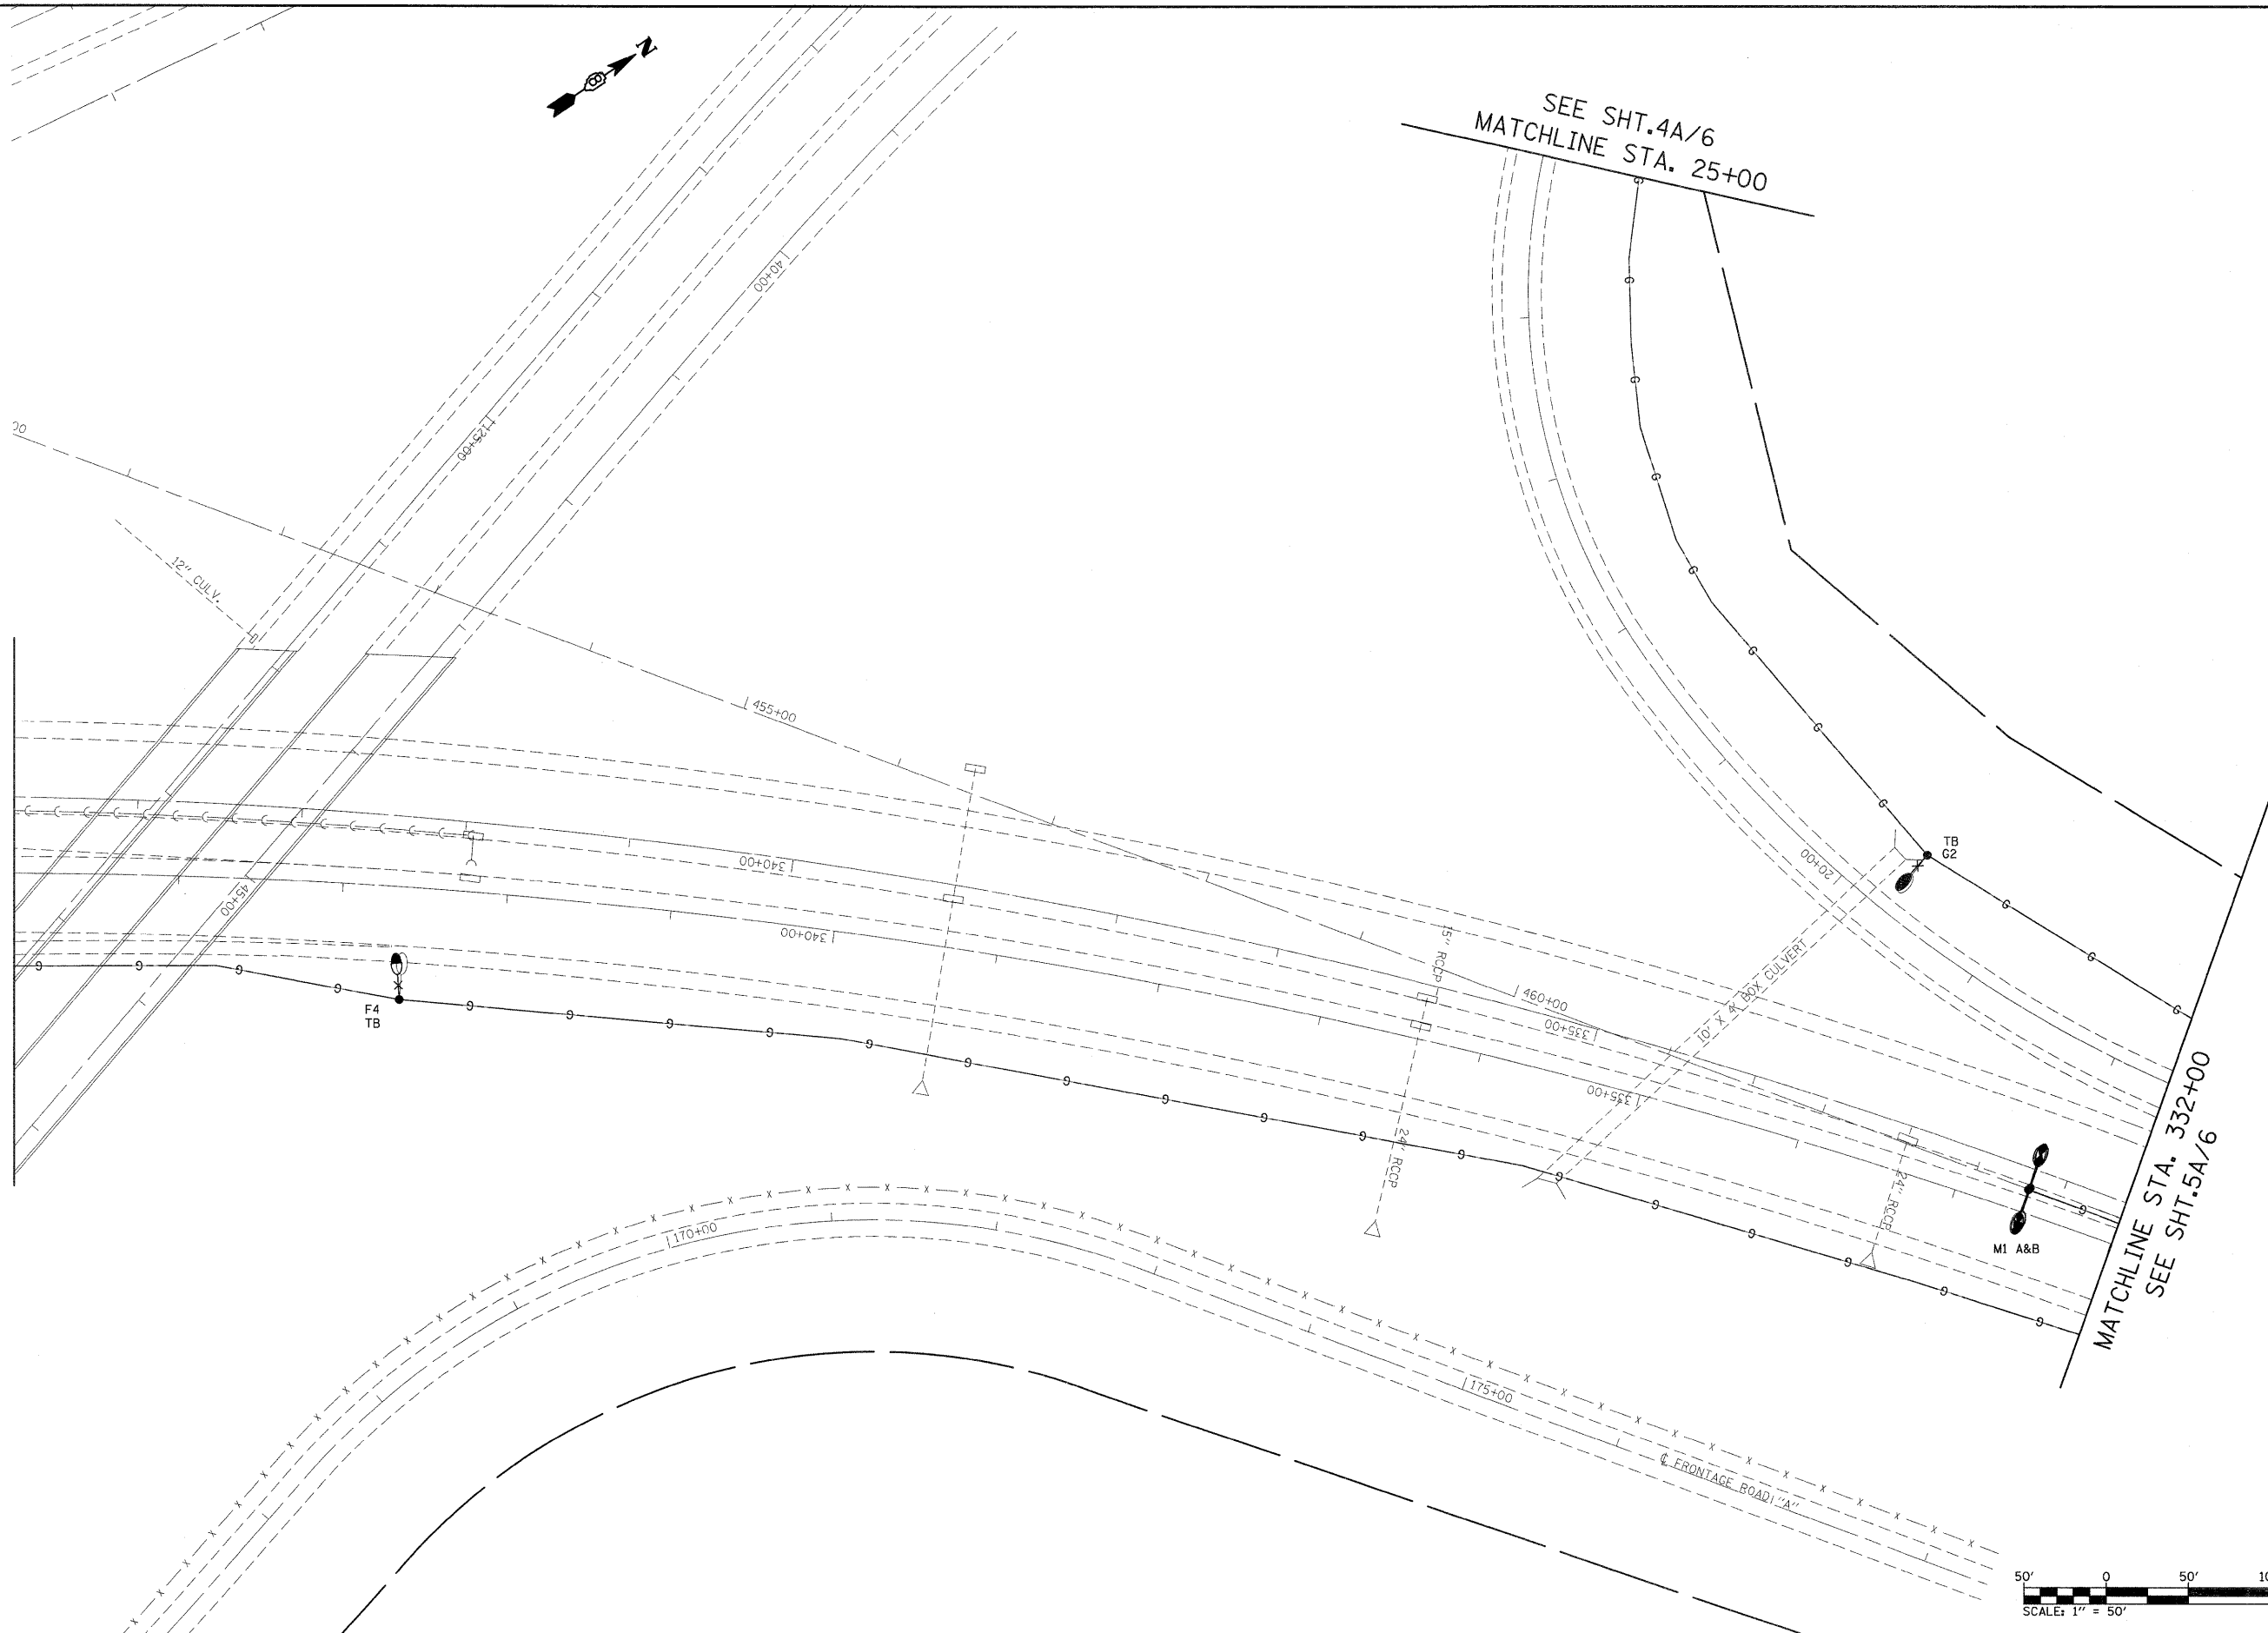

FILE NAME =	USER NAME = prestonme	DESIGNED -	REVISD -
c:\pw\work\pwidot\prestonme\dms65337\d875c09-sh-t-light.dgn		DRAWN -	REVISD -
	PLOT SCALE = 50.0000' / IN.	CHECKED -	REVISD -
	PLOT DATE = 6/8/2010	DATE -	REVISD -

**STATE OF ILLINOIS  
DEPARTMENT OF TRANSPORTATION**

**CONTROLLER #6 SHT. 3 OF 6  
LIGHTING PLAN**

SCALE: \_\_\_\_\_ SHEET NO. \_\_\_\_\_ OF \_\_\_\_\_ SHEETS STA. \_\_\_\_\_ TO STA. \_\_\_\_\_

F.A.J. RTE.	SECTION	COUNTY	TOTAL SHEETS	SHEET NO.
255 DIST. 8 LIGHT POLE 2009-			146	55
FED. ROAD DIST. NO. ILLINOIS FED. AID PROJECT			CONTRACT NO. 76C09	

MADISON, MONROE & ST. CLAIR