
 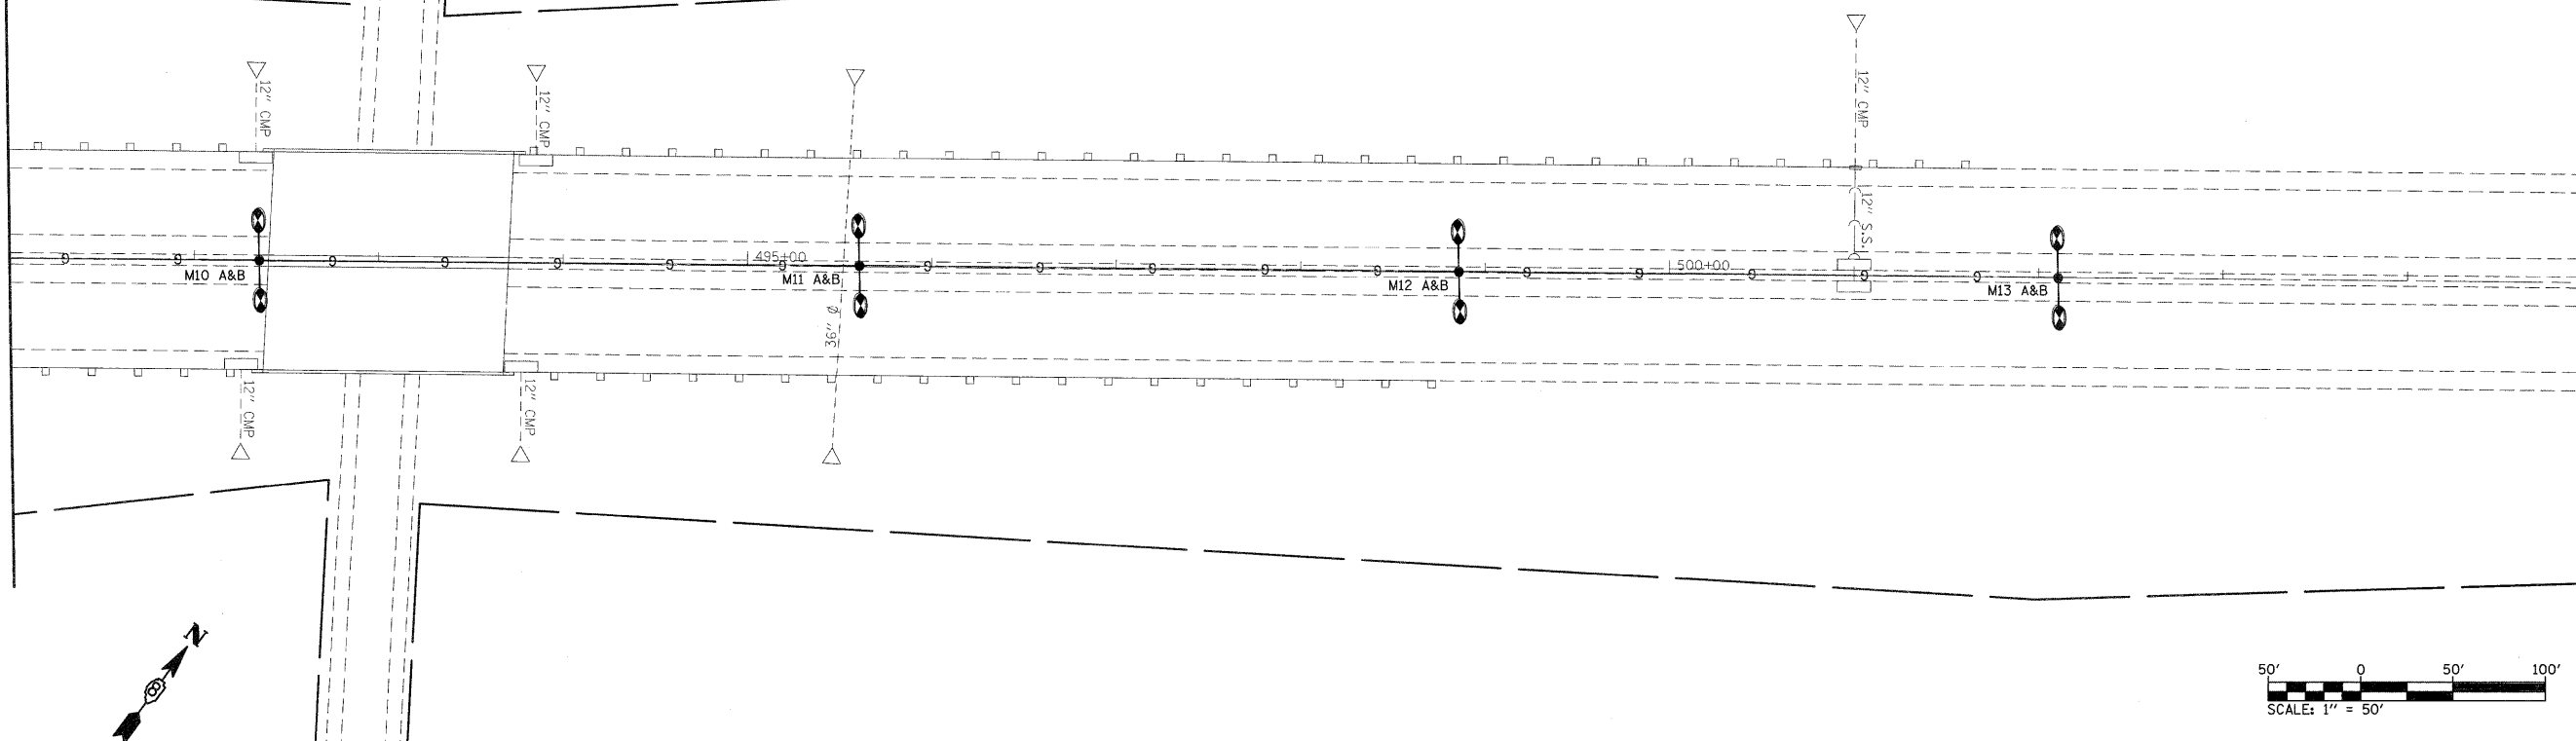


MATCHLINE STA. 491+00

EXISTING R.O.W.



FILE NAME = c:\pw\work\p\dot\prestonme\des65337\4876c09-shr-light.dgn

USER NAME = prestonme
 DRAWN -
 CHECKED -
 PLOT SCALE = 50.0000' / IN.
 PLOT DATE = 6/8/2010

DESIGNED -
 DRAWN -
 CHECKED -
 DATE -

REVISED -
 REVISED -
 REVISED -
 REVISED -

**STATE OF ILLINOIS
 DEPARTMENT OF TRANSPORTATION**

**CONTROLLER #6 SHT. 6 OF 6
 LIGHTING PLAN**

SCALE: _____ SHEET NO. _____ OF _____ SHEETS STA. _____ TO STA. _____

F.A.I. RTE.	SECTION	COUNTY	TOTAL SHEETS	SHEET NO.
255	DIST. 8 LIGHT POLE 2009-1		146	58
FED. ROAD DIST. NO. - ILLINOIS FED. AID PROJECT			CONTRACT NO. 76C09	