



ROUTE NO.	SECTION	CITY	TOTAL SHEETS	SHEET NO.
	05-00001-00-RP	OREANA	46	9
FED. ROAD DIST. NO.	ILLINOIS	PROJECT	RFP-0913 (001)	
CONTRACT NUMBER 95537				

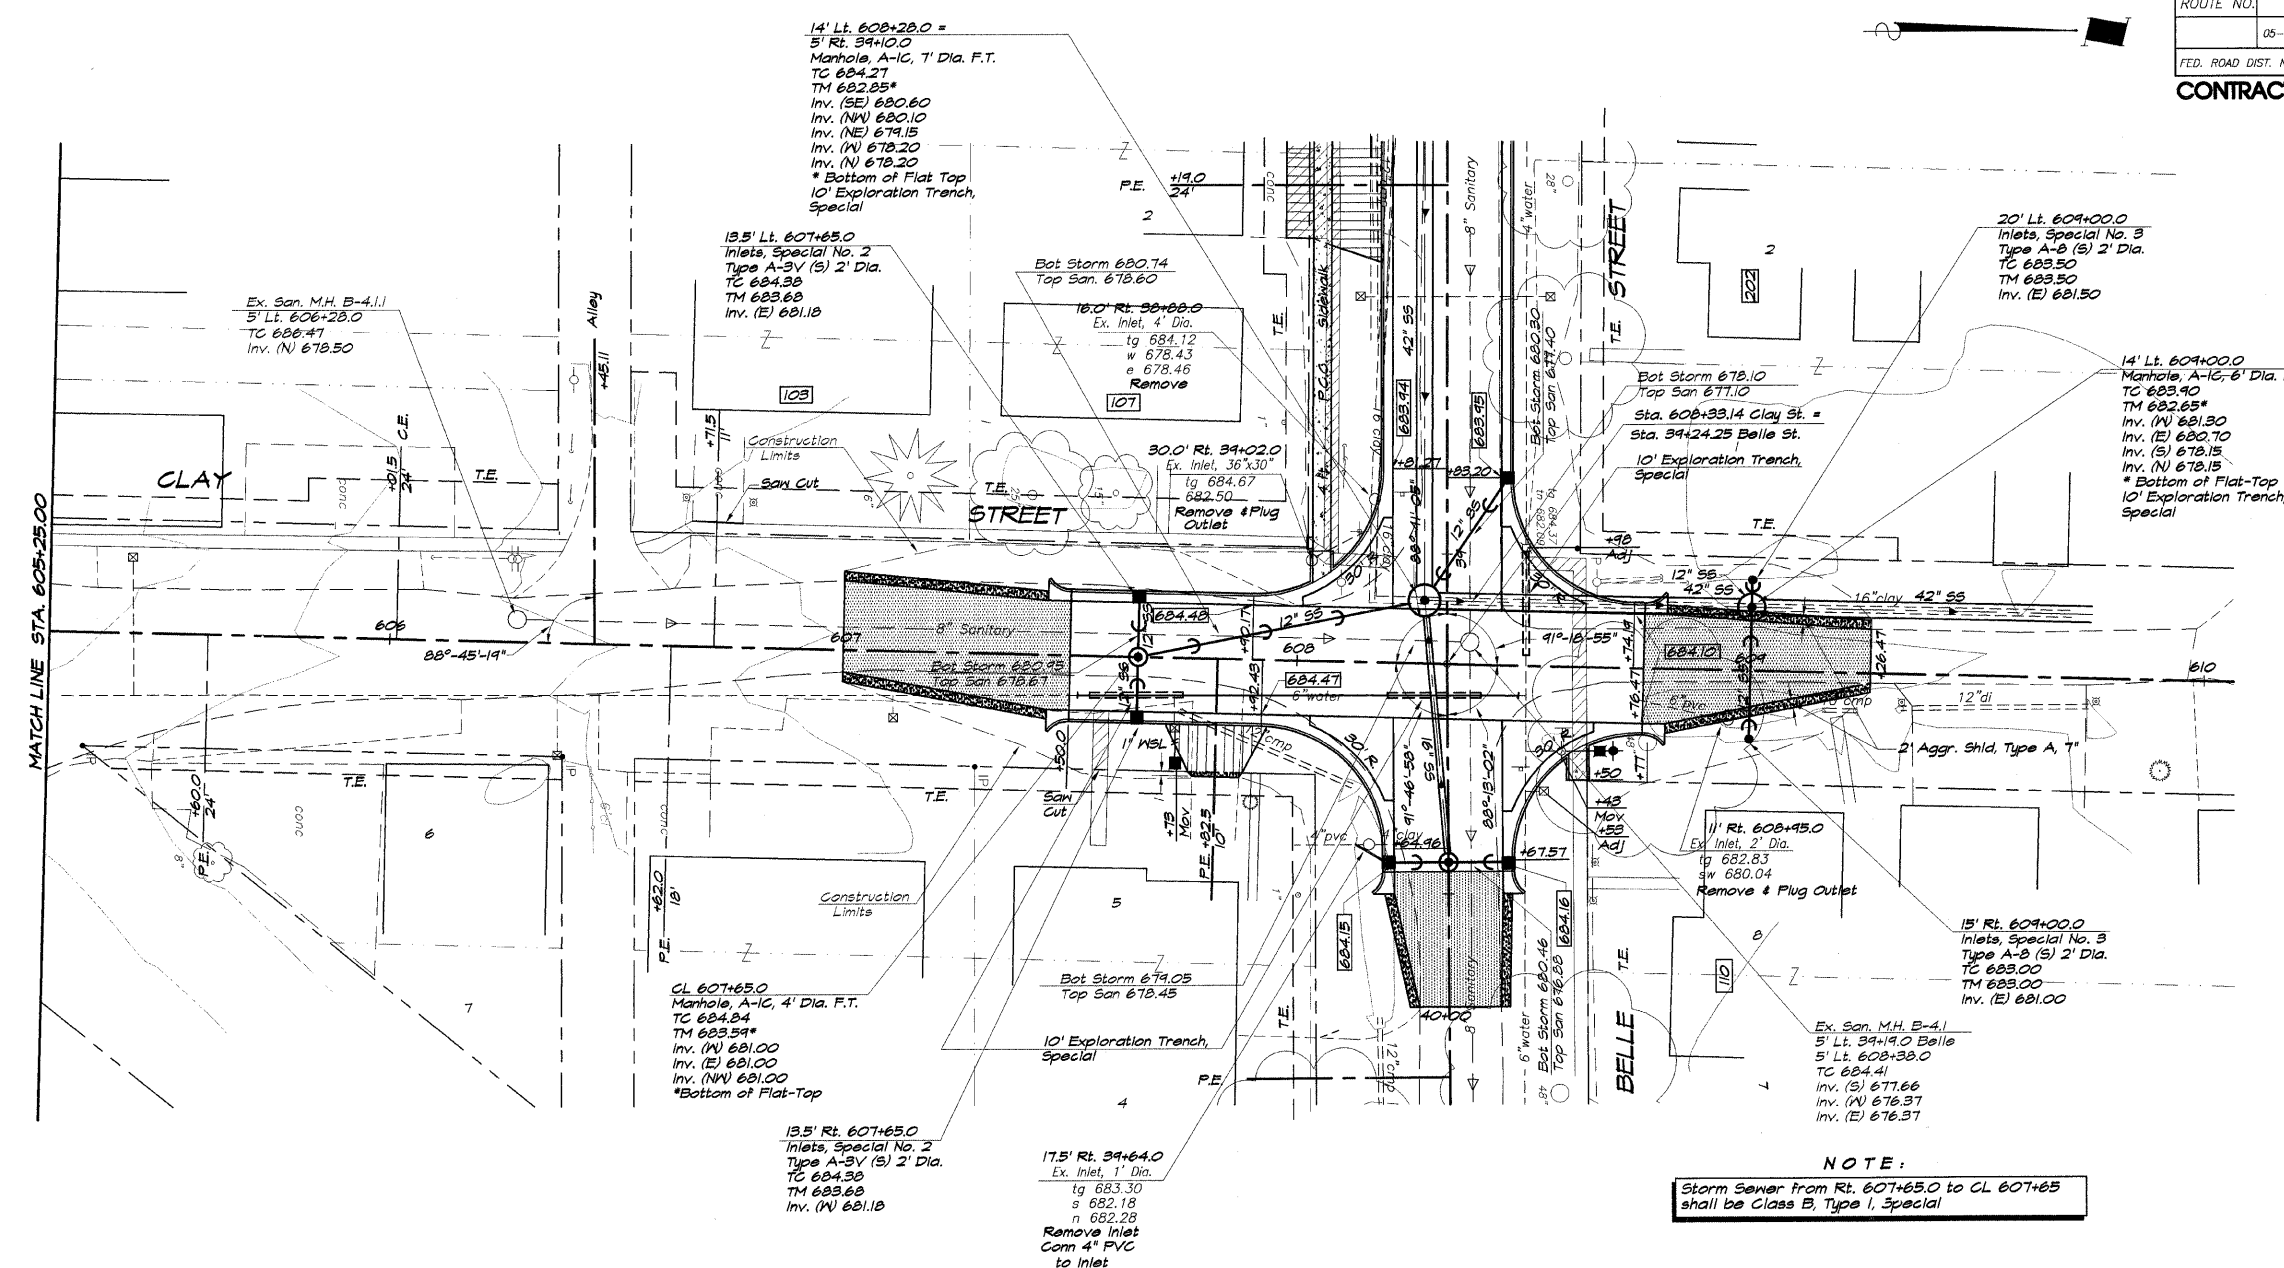

**NOTE:**  
Storm Sewer from Rt. 607+65.0 to CL 607+65 shall be Class B, Type 1, Special

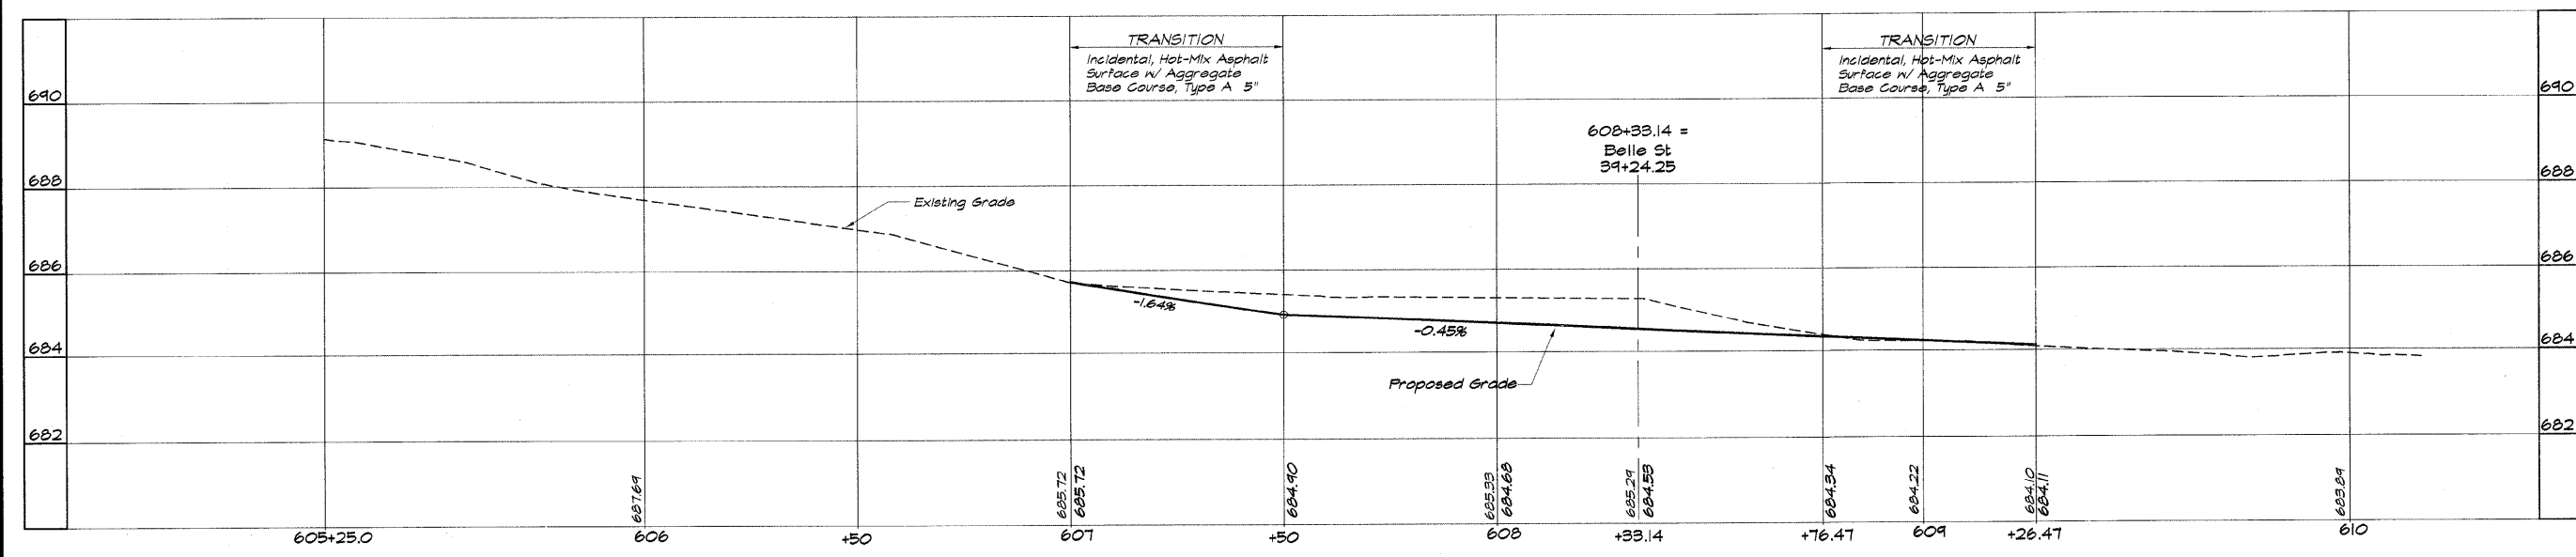

DESIGNED	M/J/P	DATE	10/20/07
DRAWN	L/S/J	DATE	05/20/06
FIELD BOOK		JOB NO.	08-040A
REVISIONS			
NO.	BY	DATE	
1	M/J/P	10/20/07	
2			
3			
4			
5			
6			
7			
8			
9			
10			
11			
12			
13			
14			
15			
16			
17			
18			
19			
20			
21			
22			
23			
24			
25			
26			
27			
28			
29			
30			
31			
32			
33			
34			
35			
36			
37			
38			
39			
40			
41			
42			
43			
44			
45			
46			

**BAINBRIDGE & ASSOCIATES, INC.**  
Consulting Engineers  
1670 SOUTH TAYLORVILLE ROAD  
DECATUR ILLINOIS  
Illinois License 18-001255

**VILLAGE OF OREANA, ILLINOIS**  
SAFE TEA-LU PROJECT  
PLAN AND PROFILE  
CLAY STREET  
STATION 605+25.00 TO 608+25.47

SHEET NO. **9** OF **46**