
 


F.A.I. RTE.	SECTION	COUNTY	TOTAL SHEETS	SHEET NO.
90/94		COOK	45	27
STA. 8220+23.67		TO STA. 8222+75		
FED. ROAD DIST. NO. 1		ILLINOIS		FED. AID PROJECT
(1818, 1919, 1919.15)		I-11		62983

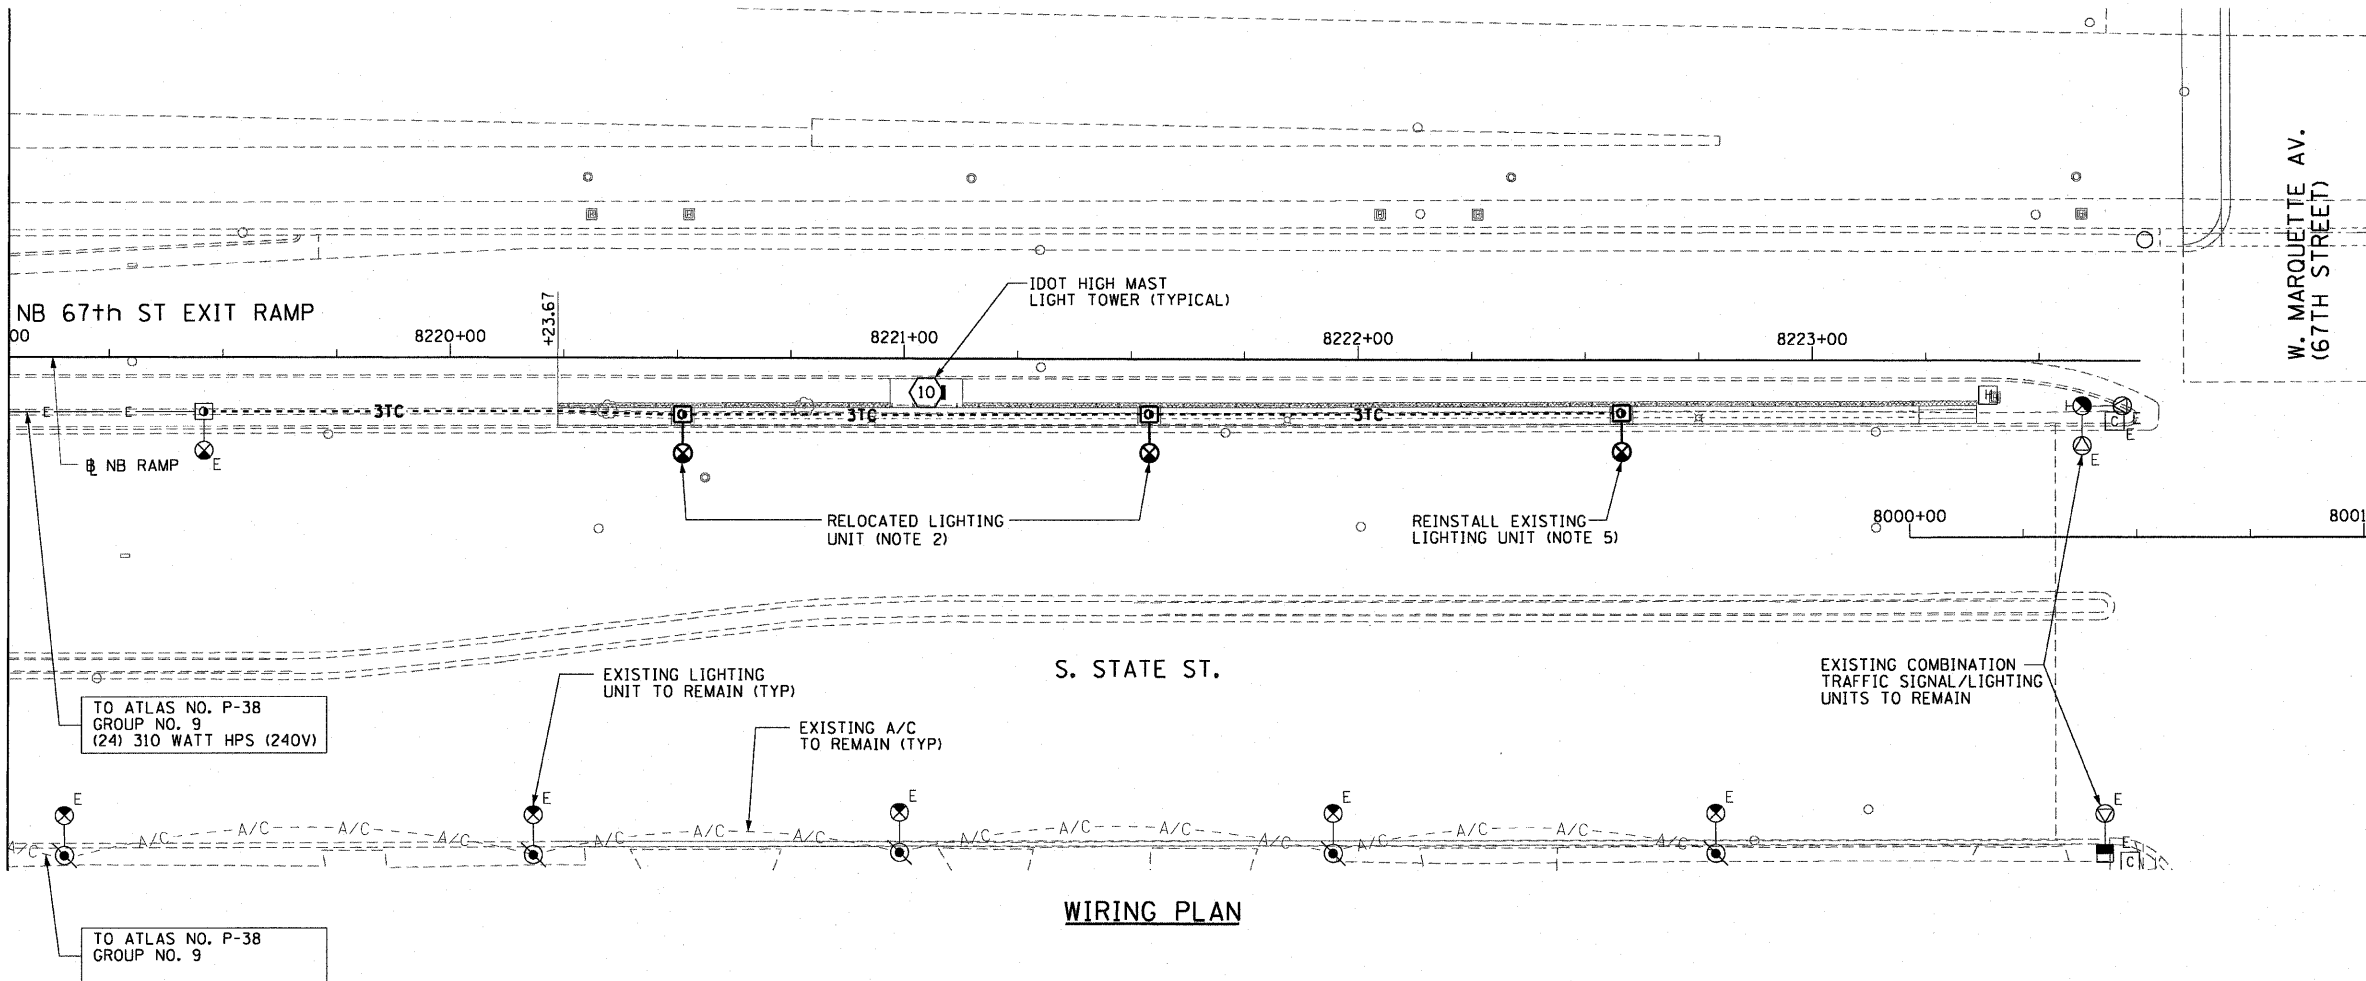

NOTES:

1. SEE DRAWINGS E-1 AND E-2 FOR GENERAL NOTES, SYMBOLS AND ABBREVIATIONS.
2. EXISTING GROUND MOUNTED LIGHTING UNITS TO BE REMOVED, CLEANED, PAINTED, PROVIDED WITH NEW LAMPS AND BE INSTALLED ON TOP OF THE NEW KNEE WALL. SEE STRUCTURAL DRAWINGS FOR KNEE WALL FOUNDATION DETAILS. REFER TO SPECIAL PROVISIONS FOR ADDITIONAL REQUIREMENTS.
3. ROUTE ALL PROPOSED LIGHTING CIRCUIT CABLE SHOWN ON THIS DRAWING IN CONDUIT SHOWN ON THE PROPOSED CONDUIT AND FOUNDATION PLAN, DRAWING E-3.
4. EXISTING REGULATORY SIGNS SHALL BE REINSTALLED ON LIGHT POLES AS DIRECTED BY THE COMMISSIONER.
5. EXISTING LIGHTING UNIT REMOVED UNDER CONTRACT 60A62 TO BE CLEANED, PAINTED, PROVIDED WITH NEW LAMP AND BE INSTALLED ON TOP OF THE NEW KNEE WALL. SEE STRUCTURAL DRAWINGS FOR KNEE WALL FOUNDATION DETAILS. REFER TO SPECIAL PROVISIONS FOR ADDITIONAL REQUIREMENTS.



E-4

REVISIONS	
NAME	DATE

ILLINOIS DEPARTMENT OF TRANSPORTATION
 F.A.I. 90/94 (DAN RYAN EXPRESSWAY)
 71ST ST TO 63RD ST (NORTHBOUND KNEE WALLS)

WIRING PLAN

SCALE: 1"=20'
 DATE: JANUARY 14, 2009

DRAWN BY: JCM
 CHECKED BY: JPC

AECOM

V:\scg\p207\p40468\p40468\elect\01\cct\new wall\cct\cct\contract 270\2700042a.dwg 1/13/2009 11:09:40 AM