


F.A. RTE.	SECTION	COUNTY	TOTAL SHEETS	SHEET NO.
1503	08-00260-01-PV	KANE	176	98

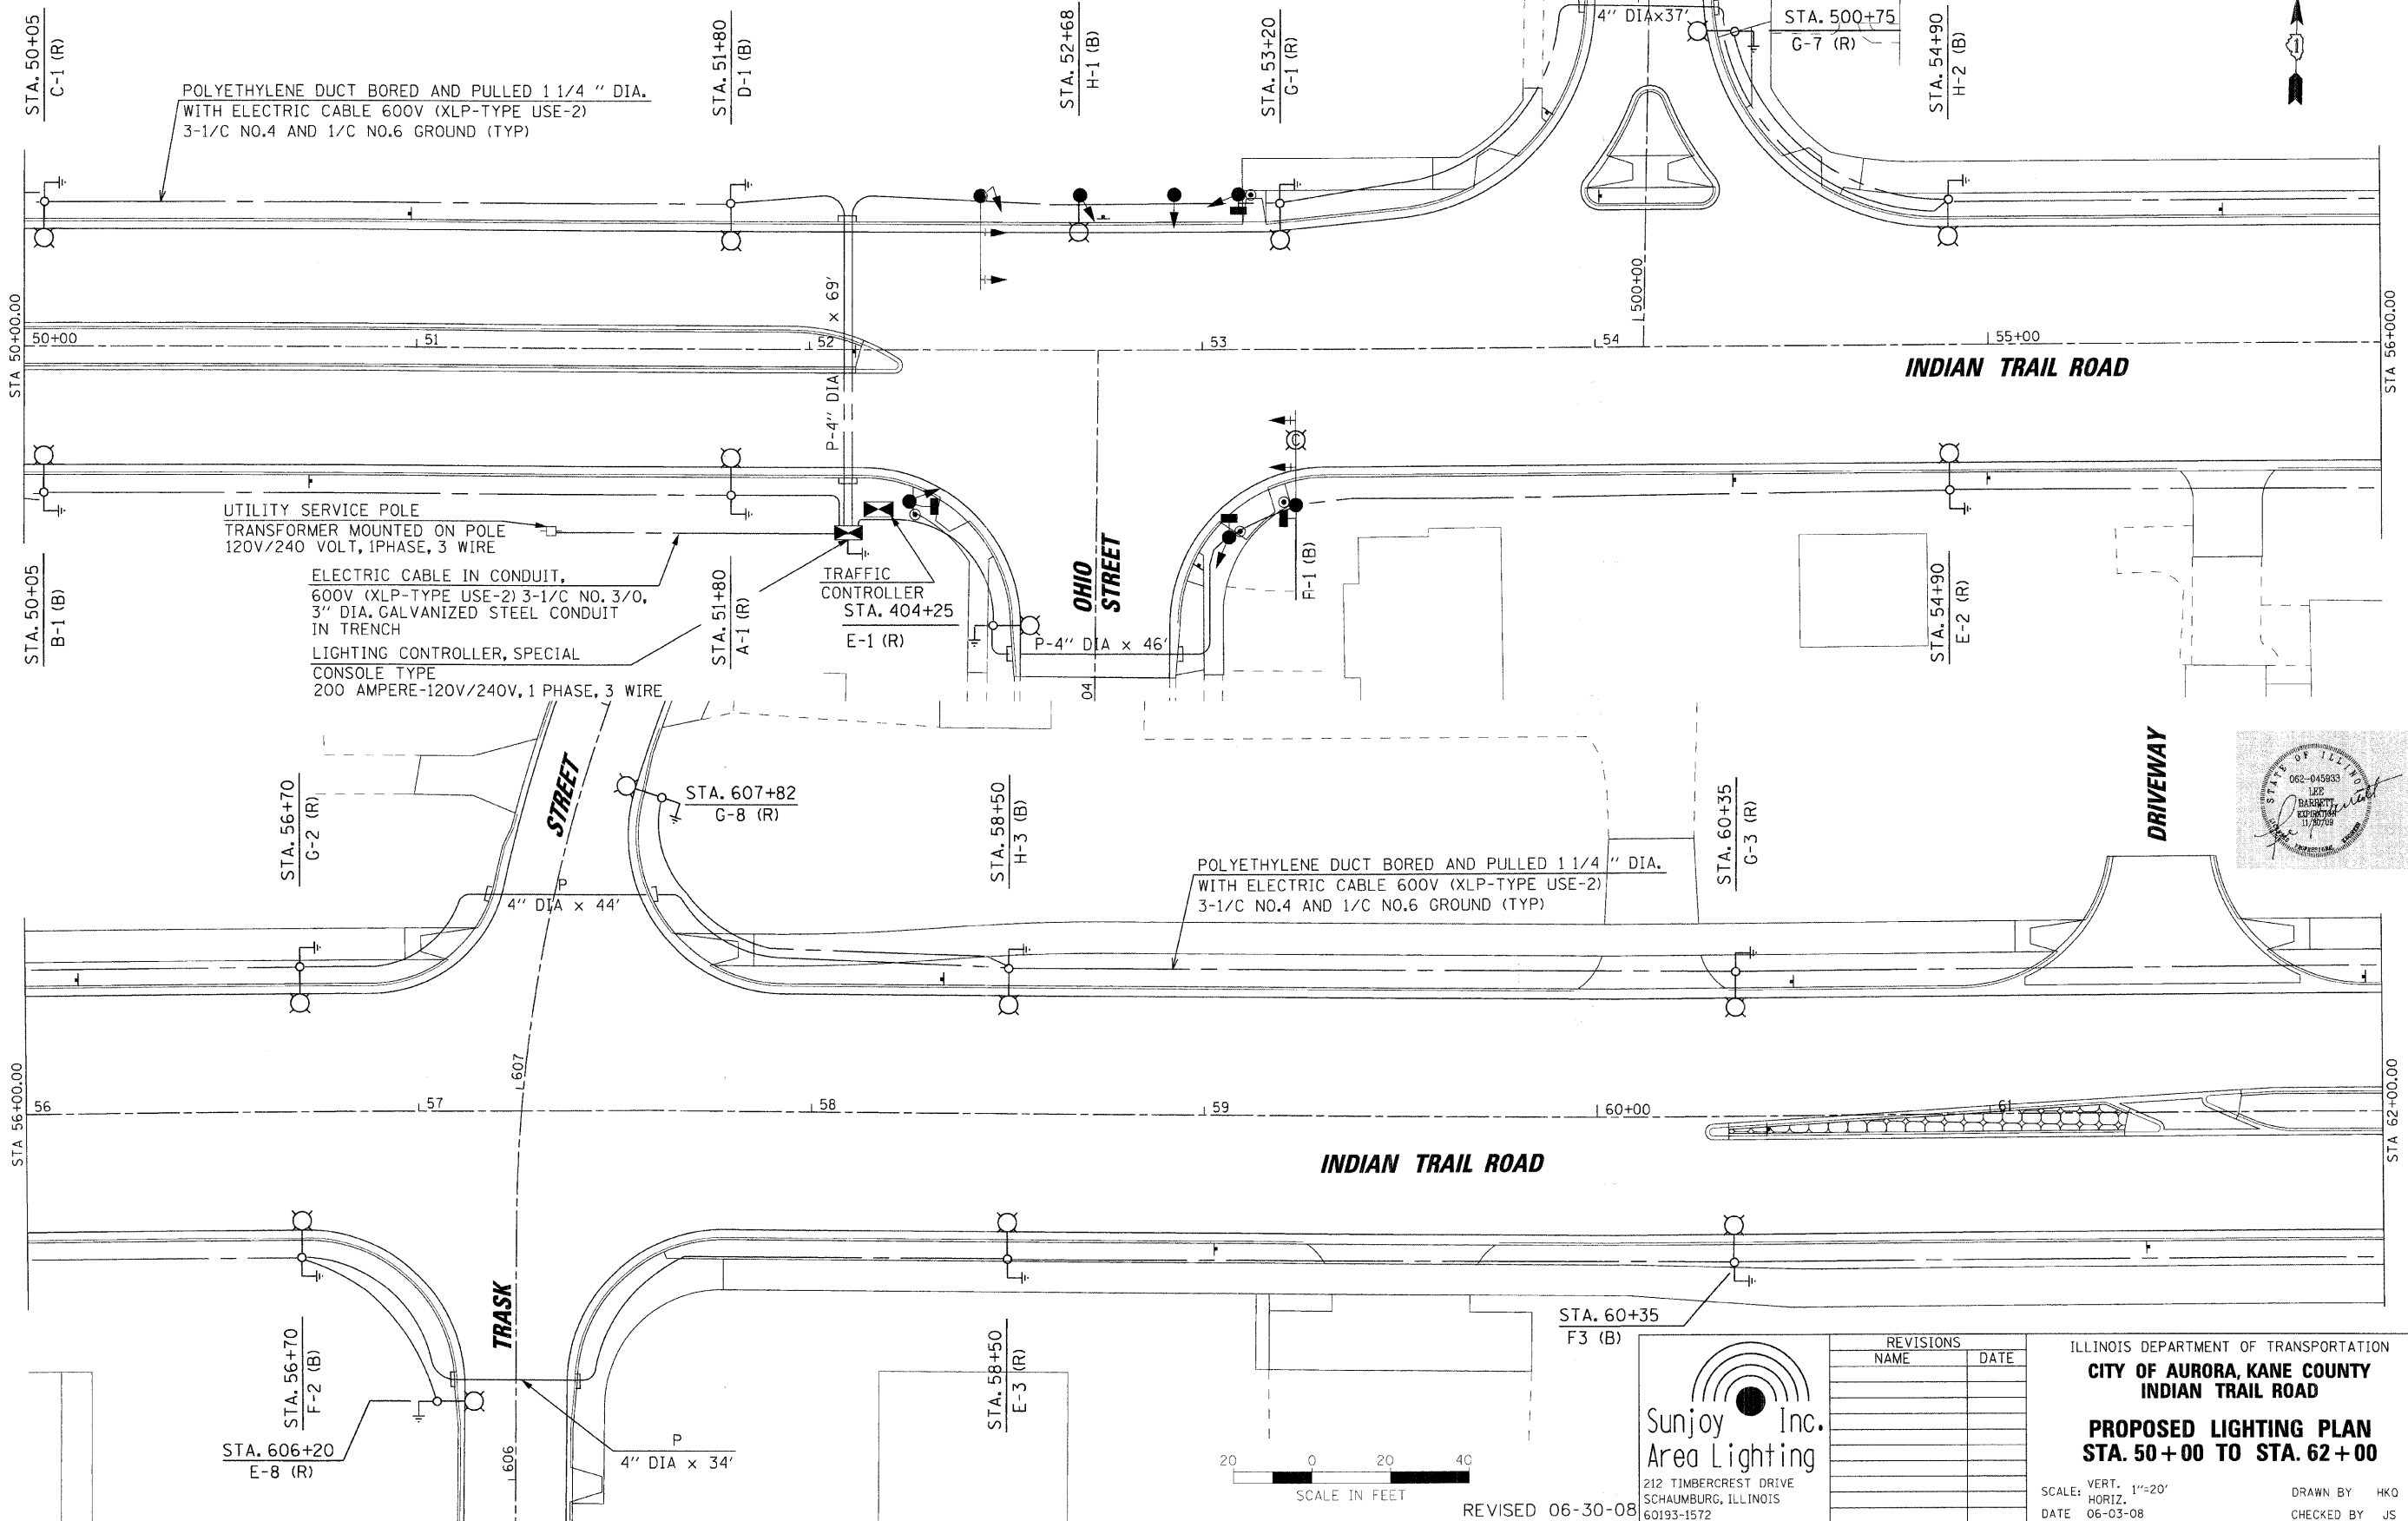

REVISED 06-30-08

Sunjoy Inc.
Area Lighting
212 TIMBERCREST DRIVE
SCHAUMBURG, ILLINOIS
60193-1572

REVISIONS	
NAME	DATE

ILLINOIS DEPARTMENT OF TRANSPORTATION
CITY OF AURORA, KANE COUNTY
INDIAN TRAIL ROAD
PROPOSED LIGHTING PLAN
STA. 50+00 TO STA. 62+00

SCALE: VERT. 1"=20'
HORIZ. 1"=20'
DATE 06-03-08

DRAWN BY HKO
CHECKED BY JS

SDATES \$FILES