
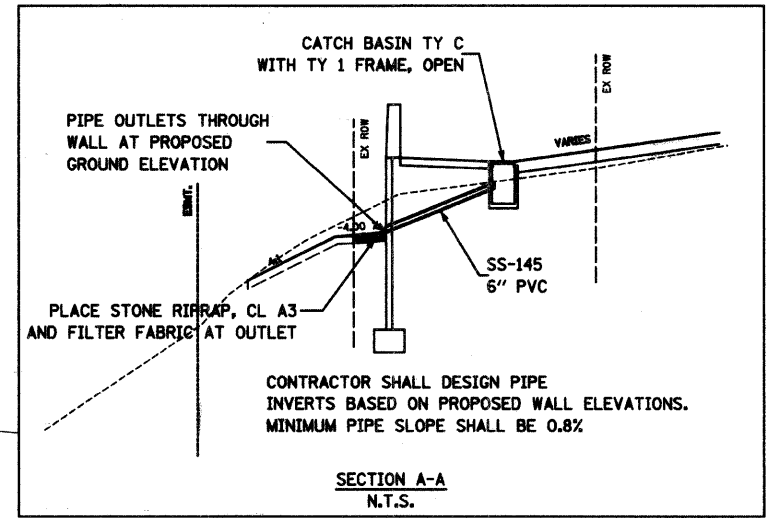



F.A.U. RTE.	SECTION	COUNTY	TOTAL SHEETS	SHEET NO.
	97-0084-00-BR	DUPAGE	241	68
STA. 22+00	TO STA. 25+75.00			
FED. ROAD DIST. NO.	ILLINOIS FED. AID PROJECT			
CONTRACT NO. 83908				

DATE	BY
DATE	BY
DATE	BY
DATE	BY
DATE	BY

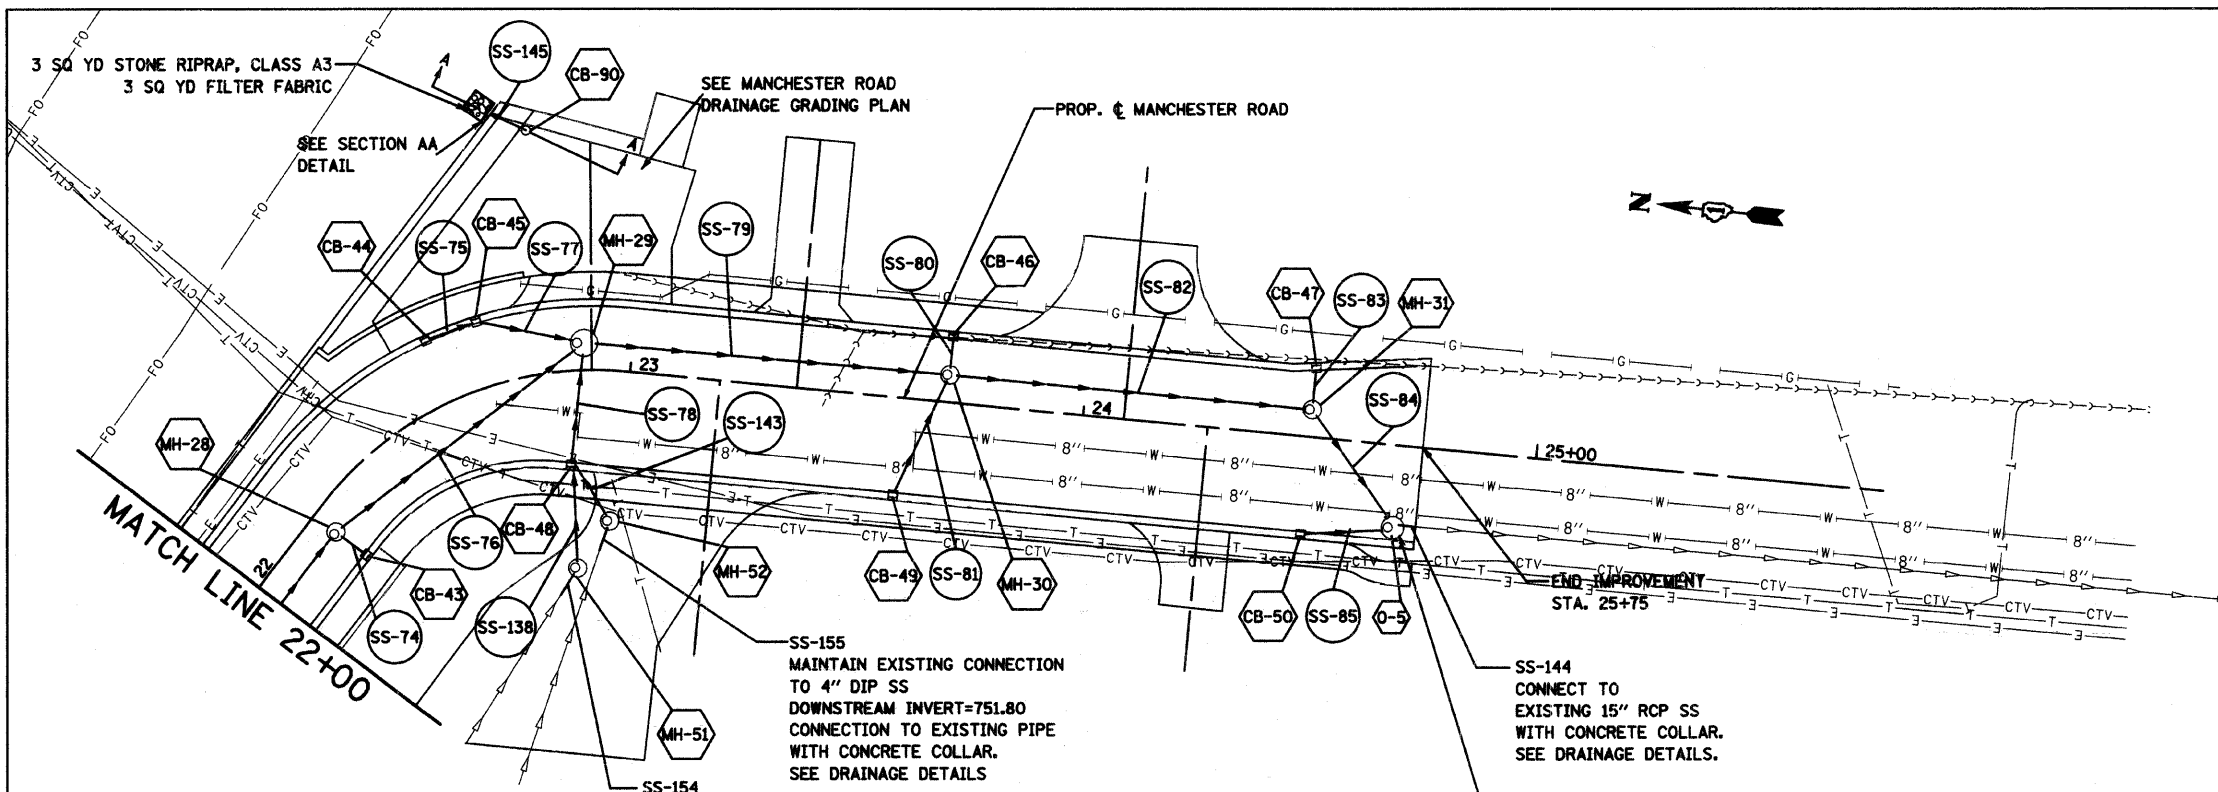


NOTE:
CONTRACTOR SHALL VERIFY ALL
INVERT ELEVATIONS IN MANHOLES,
CATCH BASINS, & INLETS PRIOR TO
ORDERING MATERIALS.

 NOTES:
1. CONNECTION TO/MAINTENANCE OF EXISTING PIPE AND PIPE
APPURTENANCES SHALL BE INCLUDED TO COST OF PIPE



DATE	BY
DATE	BY
DATE	BY
DATE	BY
DATE	BY

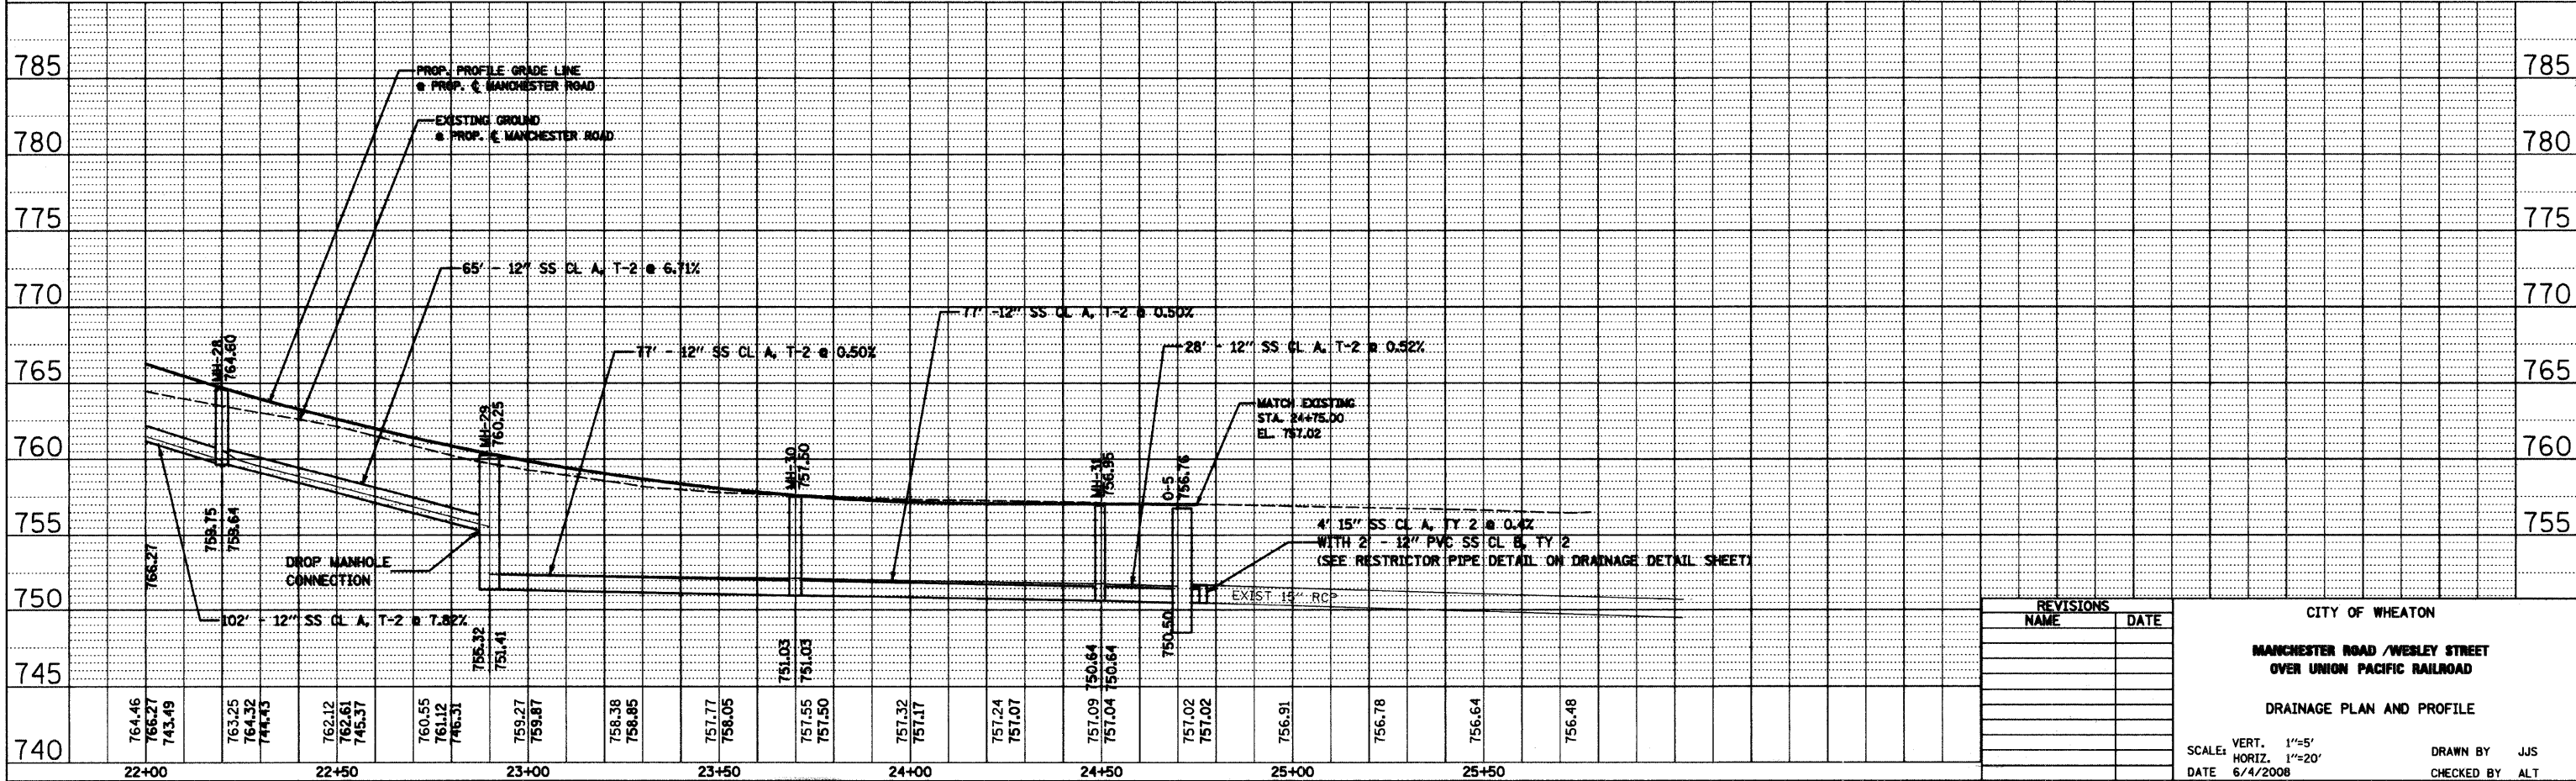

REVISIONS	
NAME	DATE

CITY OF WHEATON
MANCHESTER ROAD / WESLEY STREET
OVER UNION PACIFIC RAILROAD
DRAINAGE PLAN AND PROFILE
SCALE: VERT. 1"=5'
HORIZ. 1"=20'
DATE 6/4/2008
DRAWN BY JJS
CHECKED BY ALT