
 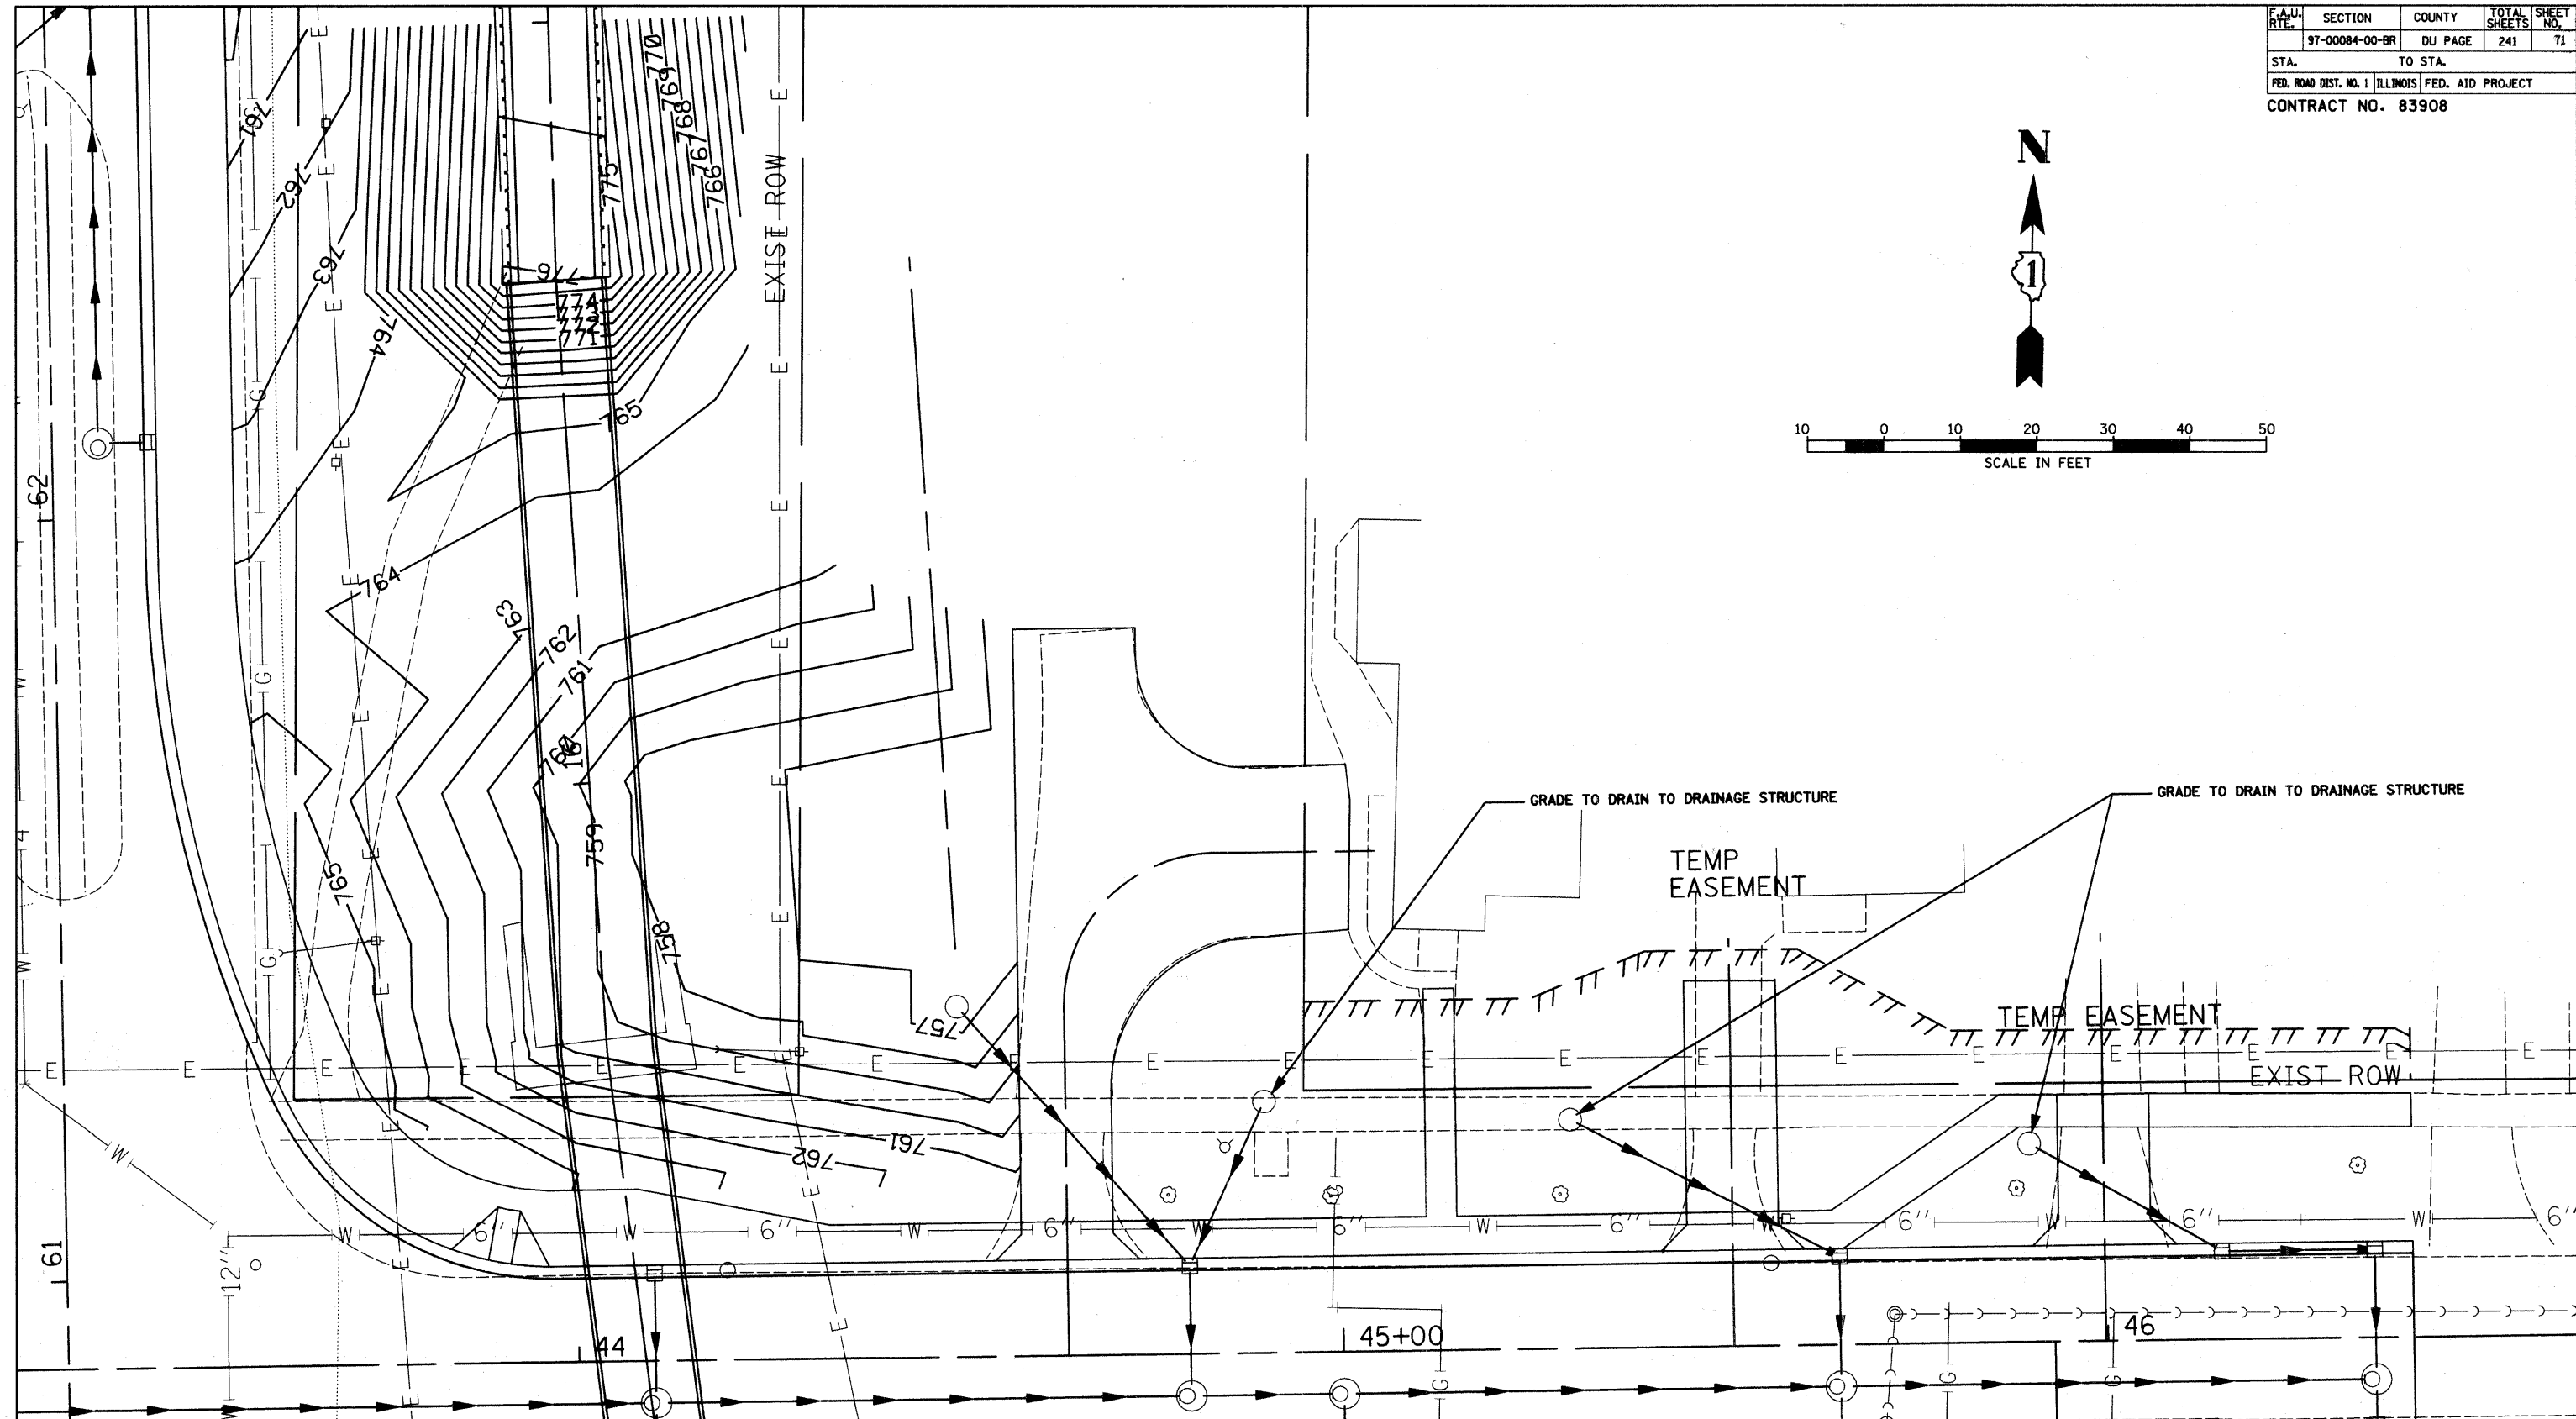


F.A.U. RTE.	SECTION	COUNTY	TOTAL SHEETS	SHEET NO.
	97-00084-00-BR	DU PAGE	241	71
STA.		TO STA.		
FED. ROAD DIST. NO. 1 ILLINOIS FED. AID PROJECT				
CONTRACT NO. 83908				



REVISIONS	
NAME	DATE

CITY OF WHEATON  
 MANCHESTER ROAD / WESLEY STREET  
 OVER UNION PACIFIC RAILROAD  
 DRAINAGE  
 GRADING PLAN  
 SCALE: VERT. 1" = 10'  
 HORIZ. 1" = 10'  
 DATE 6/4/2008  
 DRAWN BY DWK  
 CHECKED BY PML  
 WESLEY STREET (SHEET 2 OF 2)