
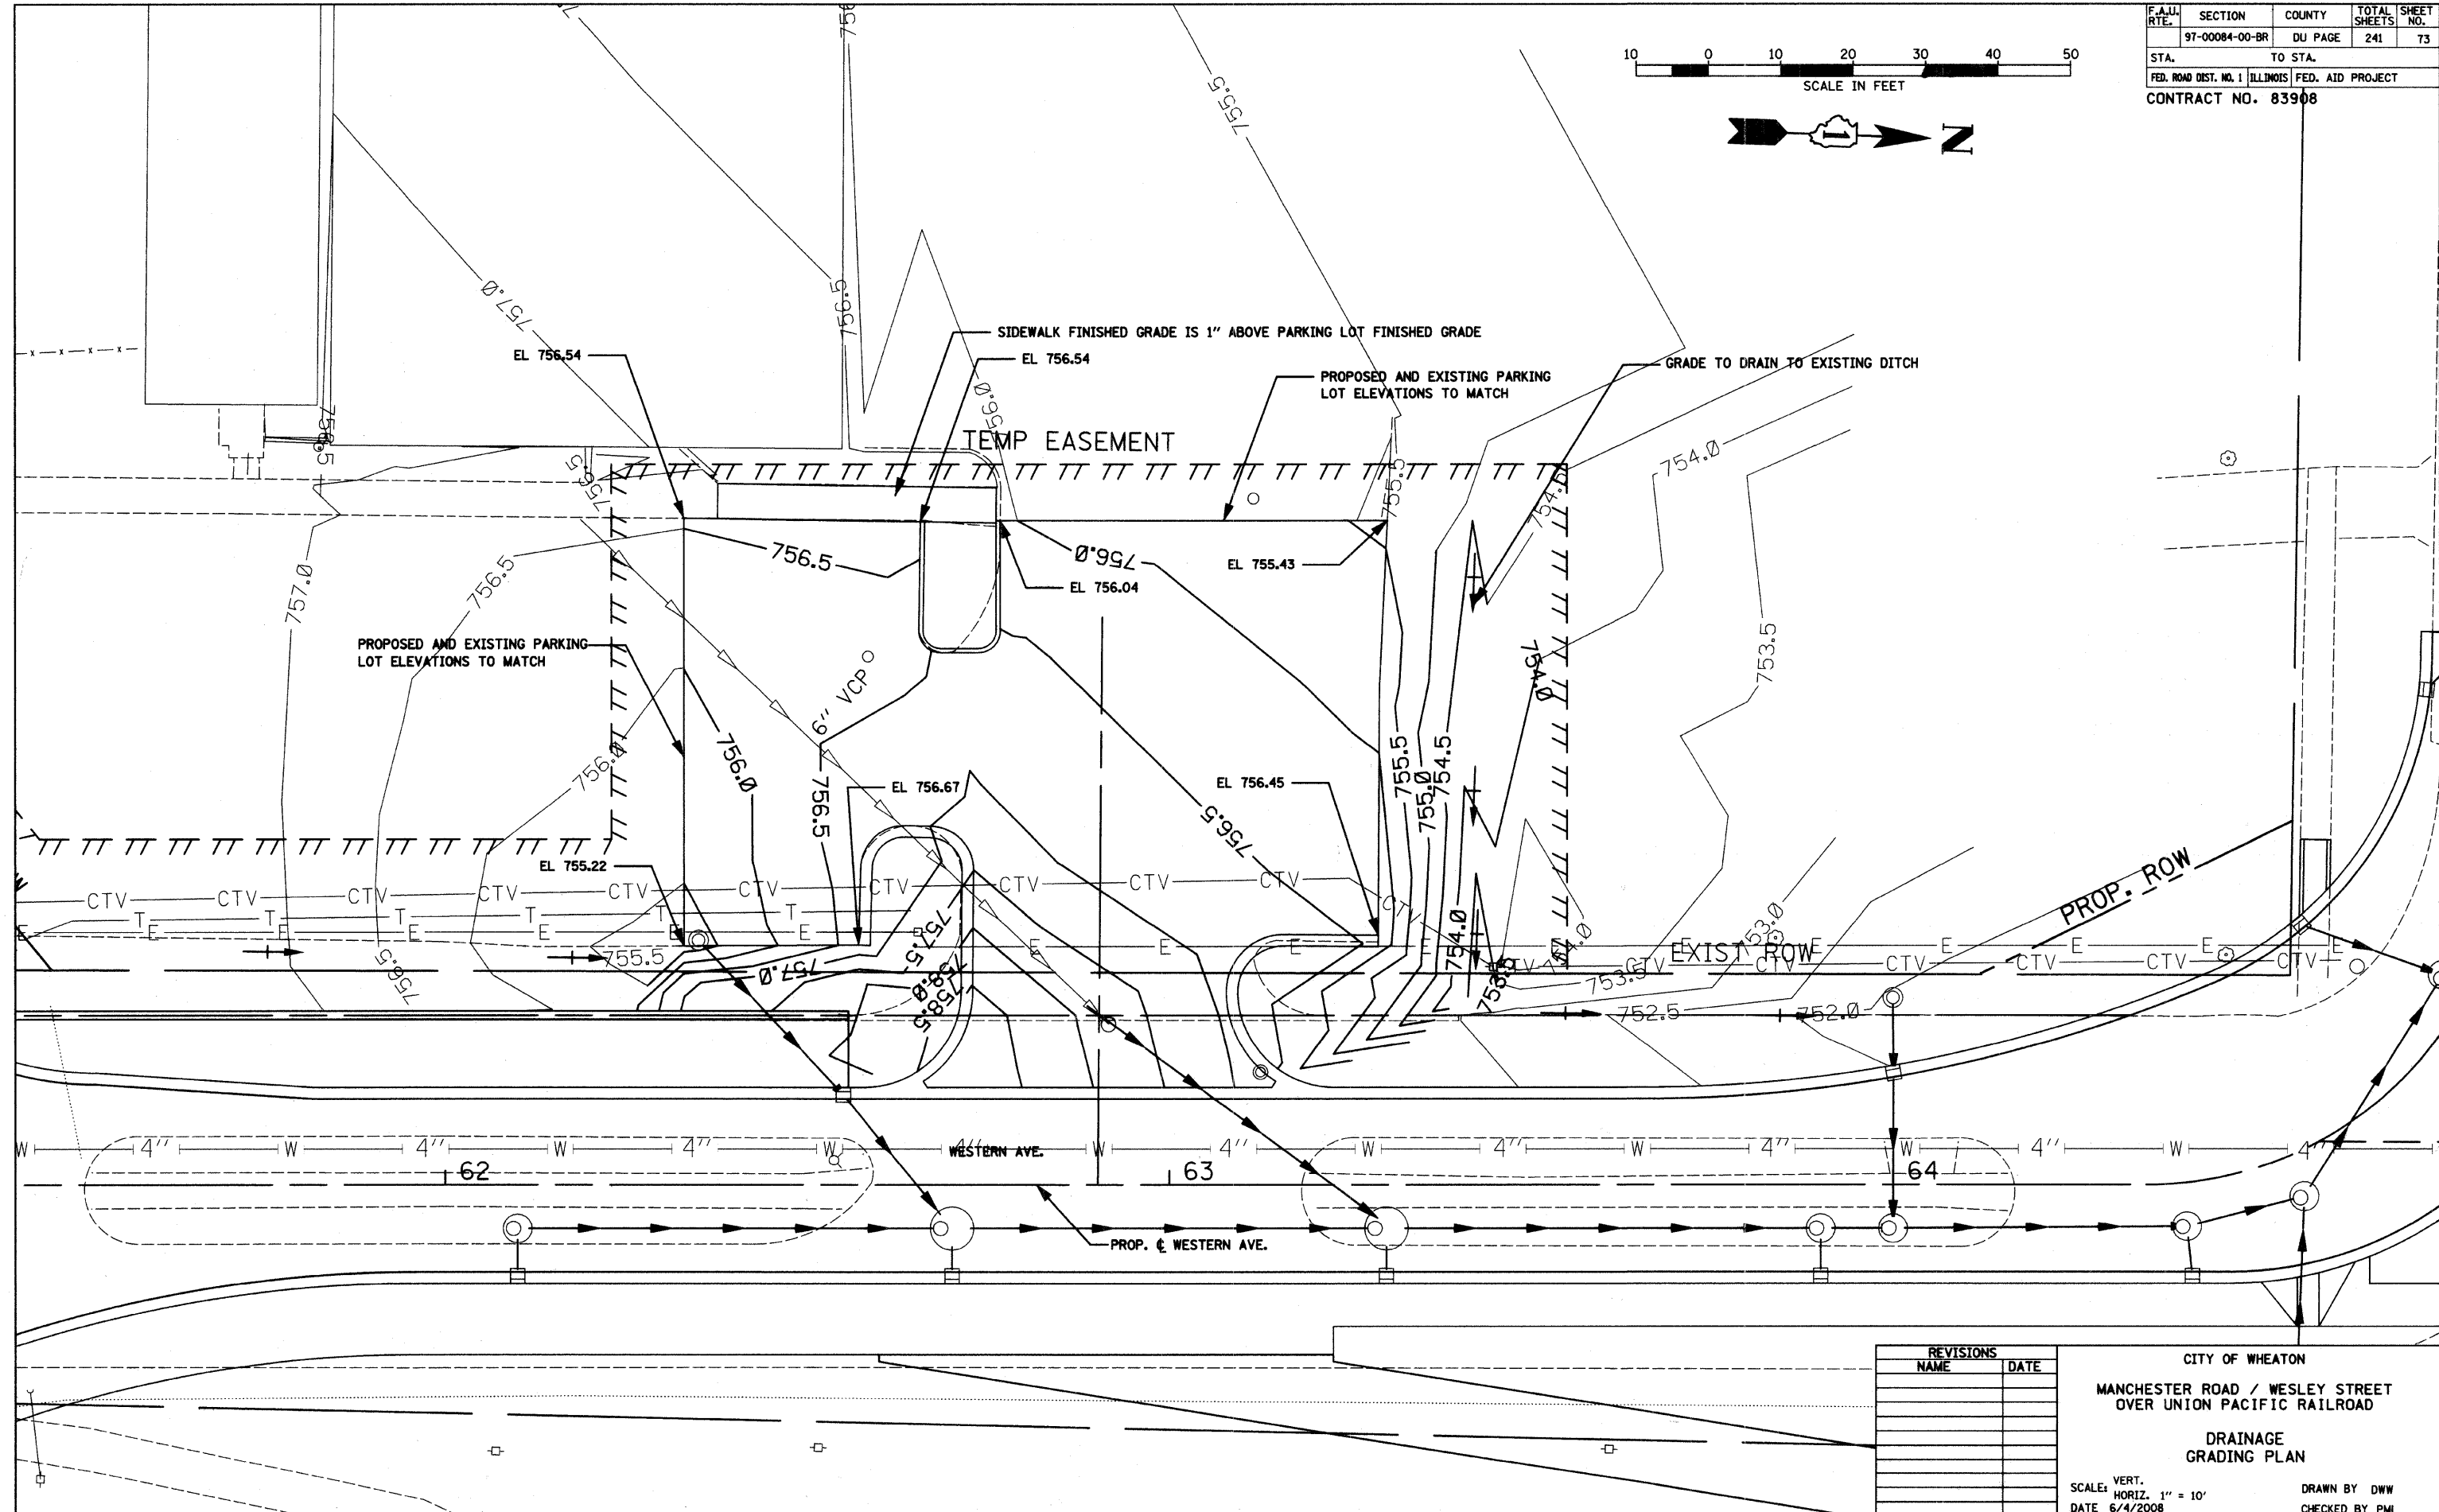


F.A.U. RTE.	SECTION	COUNTY	TOTAL SHEETS	SHEET NO.
	97-00084-00-BR	DU PAGE	241	73
STA.	TO STA.			
FED. ROAD DIST. NO. 1 ILLINOIS FED. AID PROJECT				
CONTRACT NO. 83908				

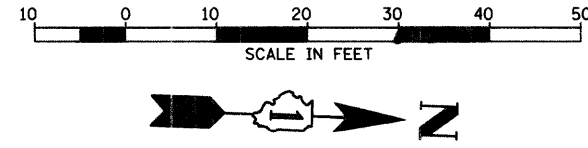

REVISIONS	
NAME	DATE

CITY OF WHEATON
 MANCHESTER ROAD / WESLEY STREET
 OVER UNION PACIFIC RAILROAD

DRAINAGE
 GRADING PLAN

SCALE: VERT. 1" = 10'
 HORIZ. 1" = 10'
 DATE 6/4/2008

DRAWN BY DWK
 CHECKED BY PML