


F.A.U. RTE.	SECTION	COUNTY	TOTAL SHEETS	SHEET NO.
87-00084-00-BR	DUPAGE		241	75
STA. 50+00		TO STA. 54+70		
FED. ROAD DIST. NO.	ILLINOIS	FED. AID PROJECT		
CONTRACT NO. 83908				



PLAN	SURVEYED	DATE
	PLOTTED	
	CHECKED	
	BY	
	NO. OF WAYS CHECKED	
	DATE FILE NAME	

PROFILE	SURVEYED	DATE
	PLOTTED	
	CHECKED	
	BY	
	NO. OF WAYS CHECKED	
	STRUCTURE NOTATIONS CHKD	

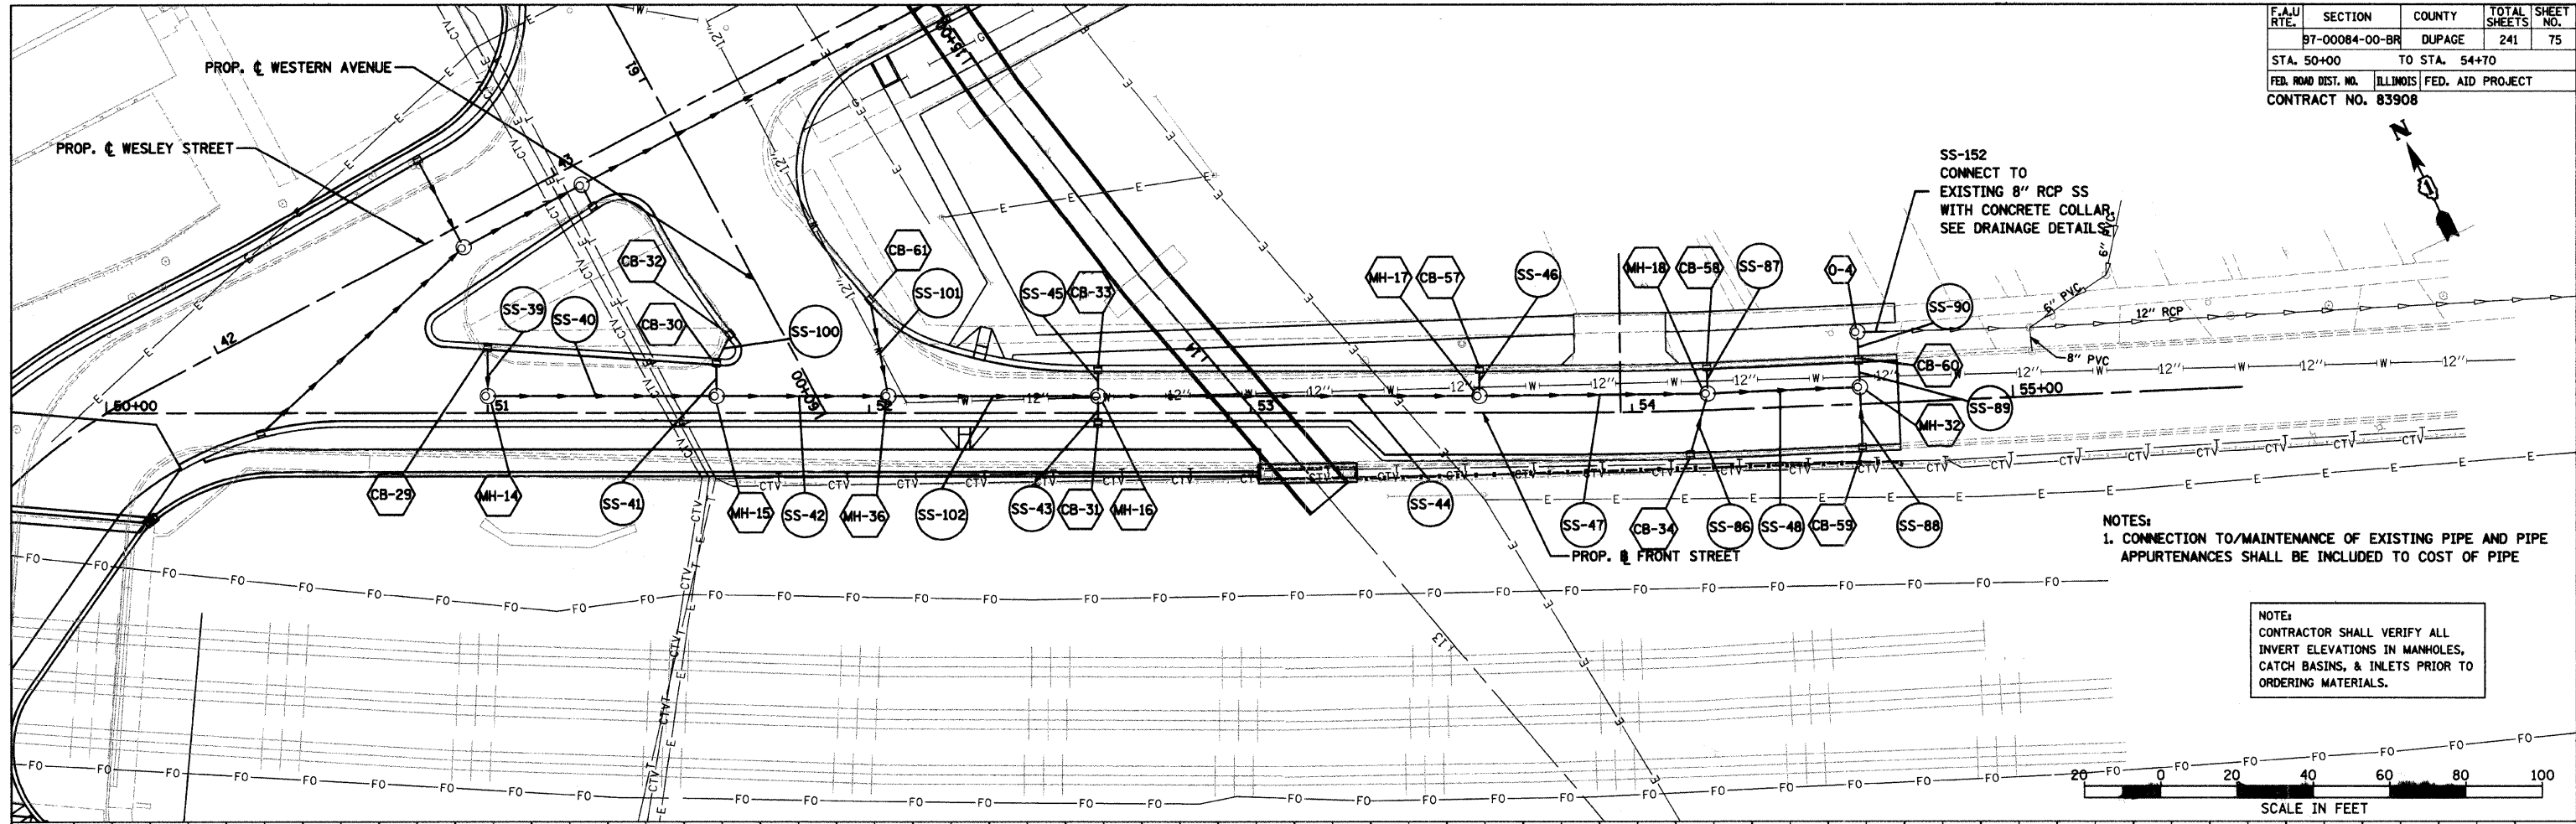

NOTES:
1. CONNECTION TO/MAINTENANCE OF EXISTING PIPE AND PIPE APPURTENANCES SHALL BE INCLUDED TO COST OF PIPE

 NOTE:
CONTRACTOR SHALL VERIFY ALL INVERT ELEVATIONS IN MANHOLES, CATCH BASINS, & INLETS PRIOR TO ORDERING MATERIALS.

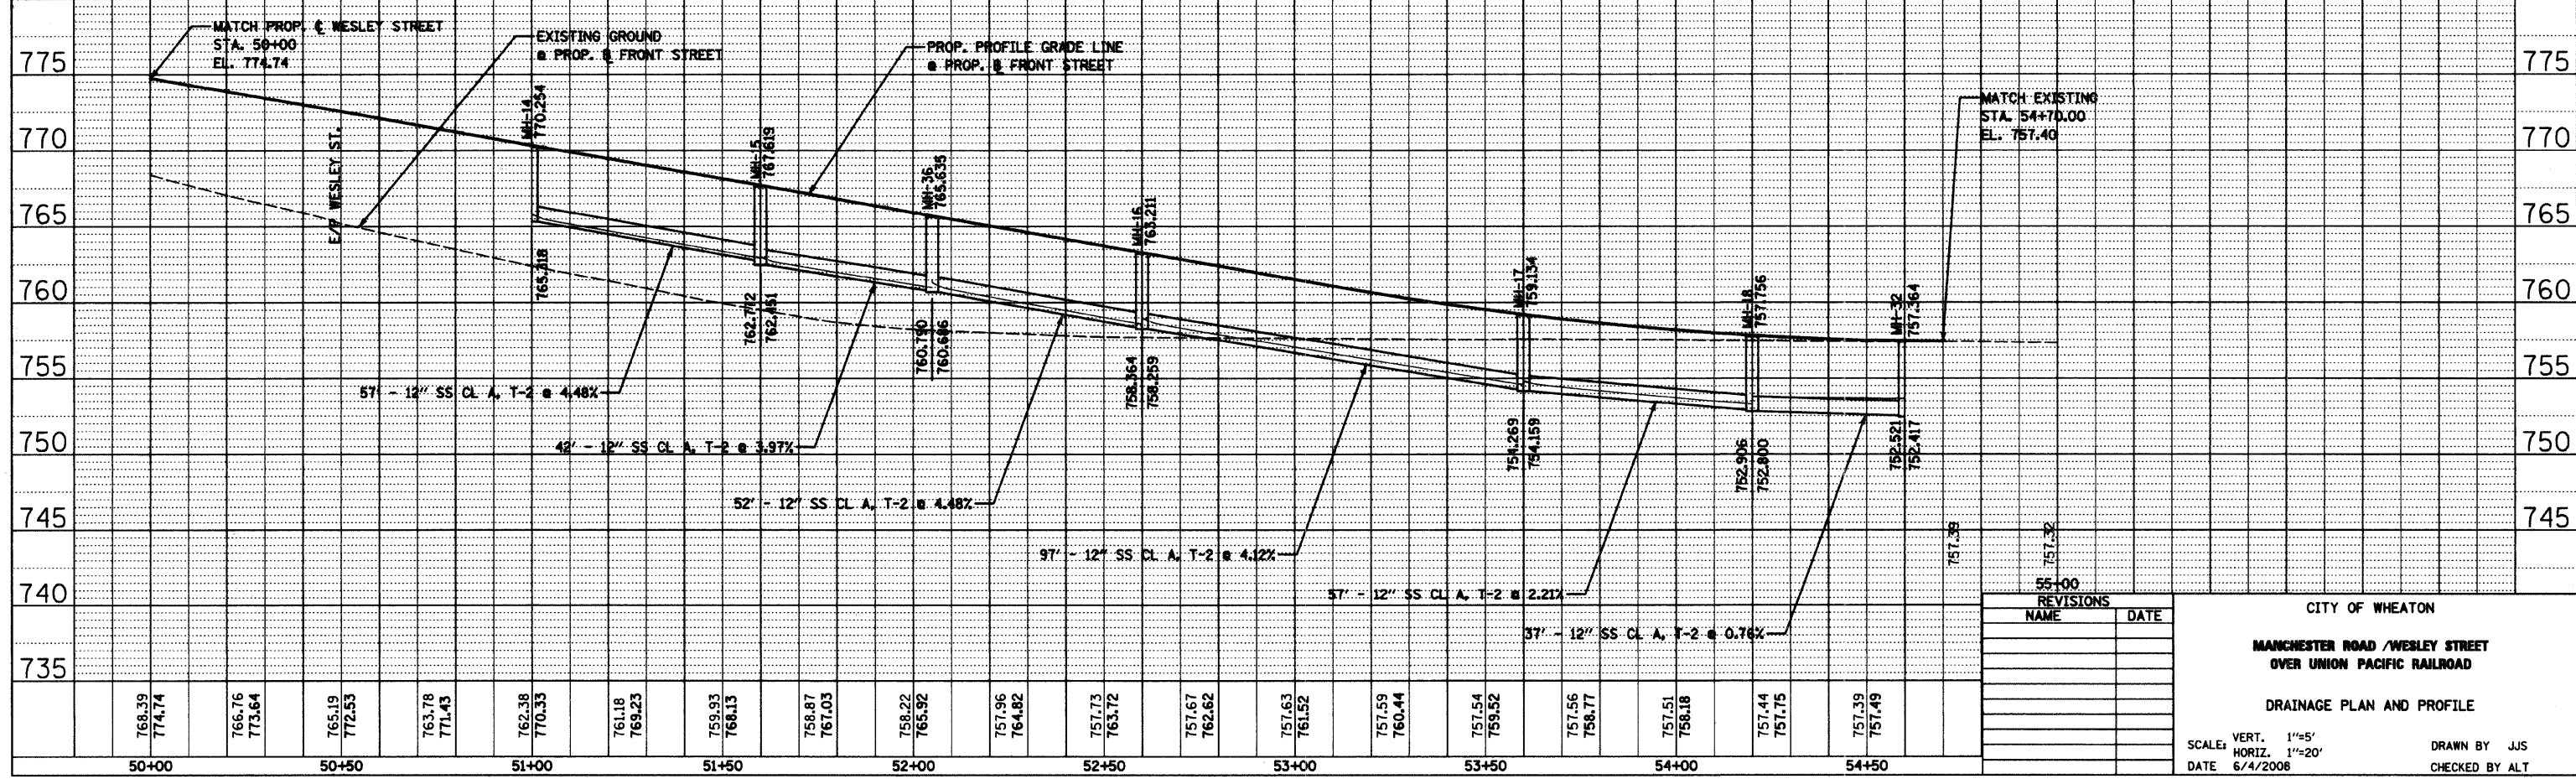

REVISIONS	
NAME	DATE

CITY OF WHEATON
MANCHESTER ROAD / WESLEY STREET
OVER UNION PACIFIC RAILROAD
DRAINAGE PLAN AND PROFILE
SCALE: VERT. 1"=5'
HORIZ. 1"=20'
DATE 6/4/2006
DRAWN BY JJS
CHECKED BY ALT