


F.A.P. RTE.	SECTION	COUNTY	TOTAL SHEETS	SHEET NO.
120		LAKE	469	161
STA.		TO STA.		
FED. ROAD DIST. NO. D-91-404-99		ILLINOIS	FED. AID PROJECT	
• 125X-HB-(1&2) R-1				

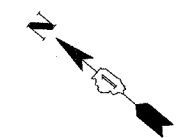


EXISTING LIGHT POLES TO BE REPLACED. REFER TO PROPOSED LIGHTING PLAN, SHEET 1

PLAN	DATE
BY	
CHECKED	
DATE	
NO.	

PROFIL	DATE
BY	
CHECKED	
DATE	
NO.	

PLOT DATE * BUA/EP
FILE NAME * #FILE#

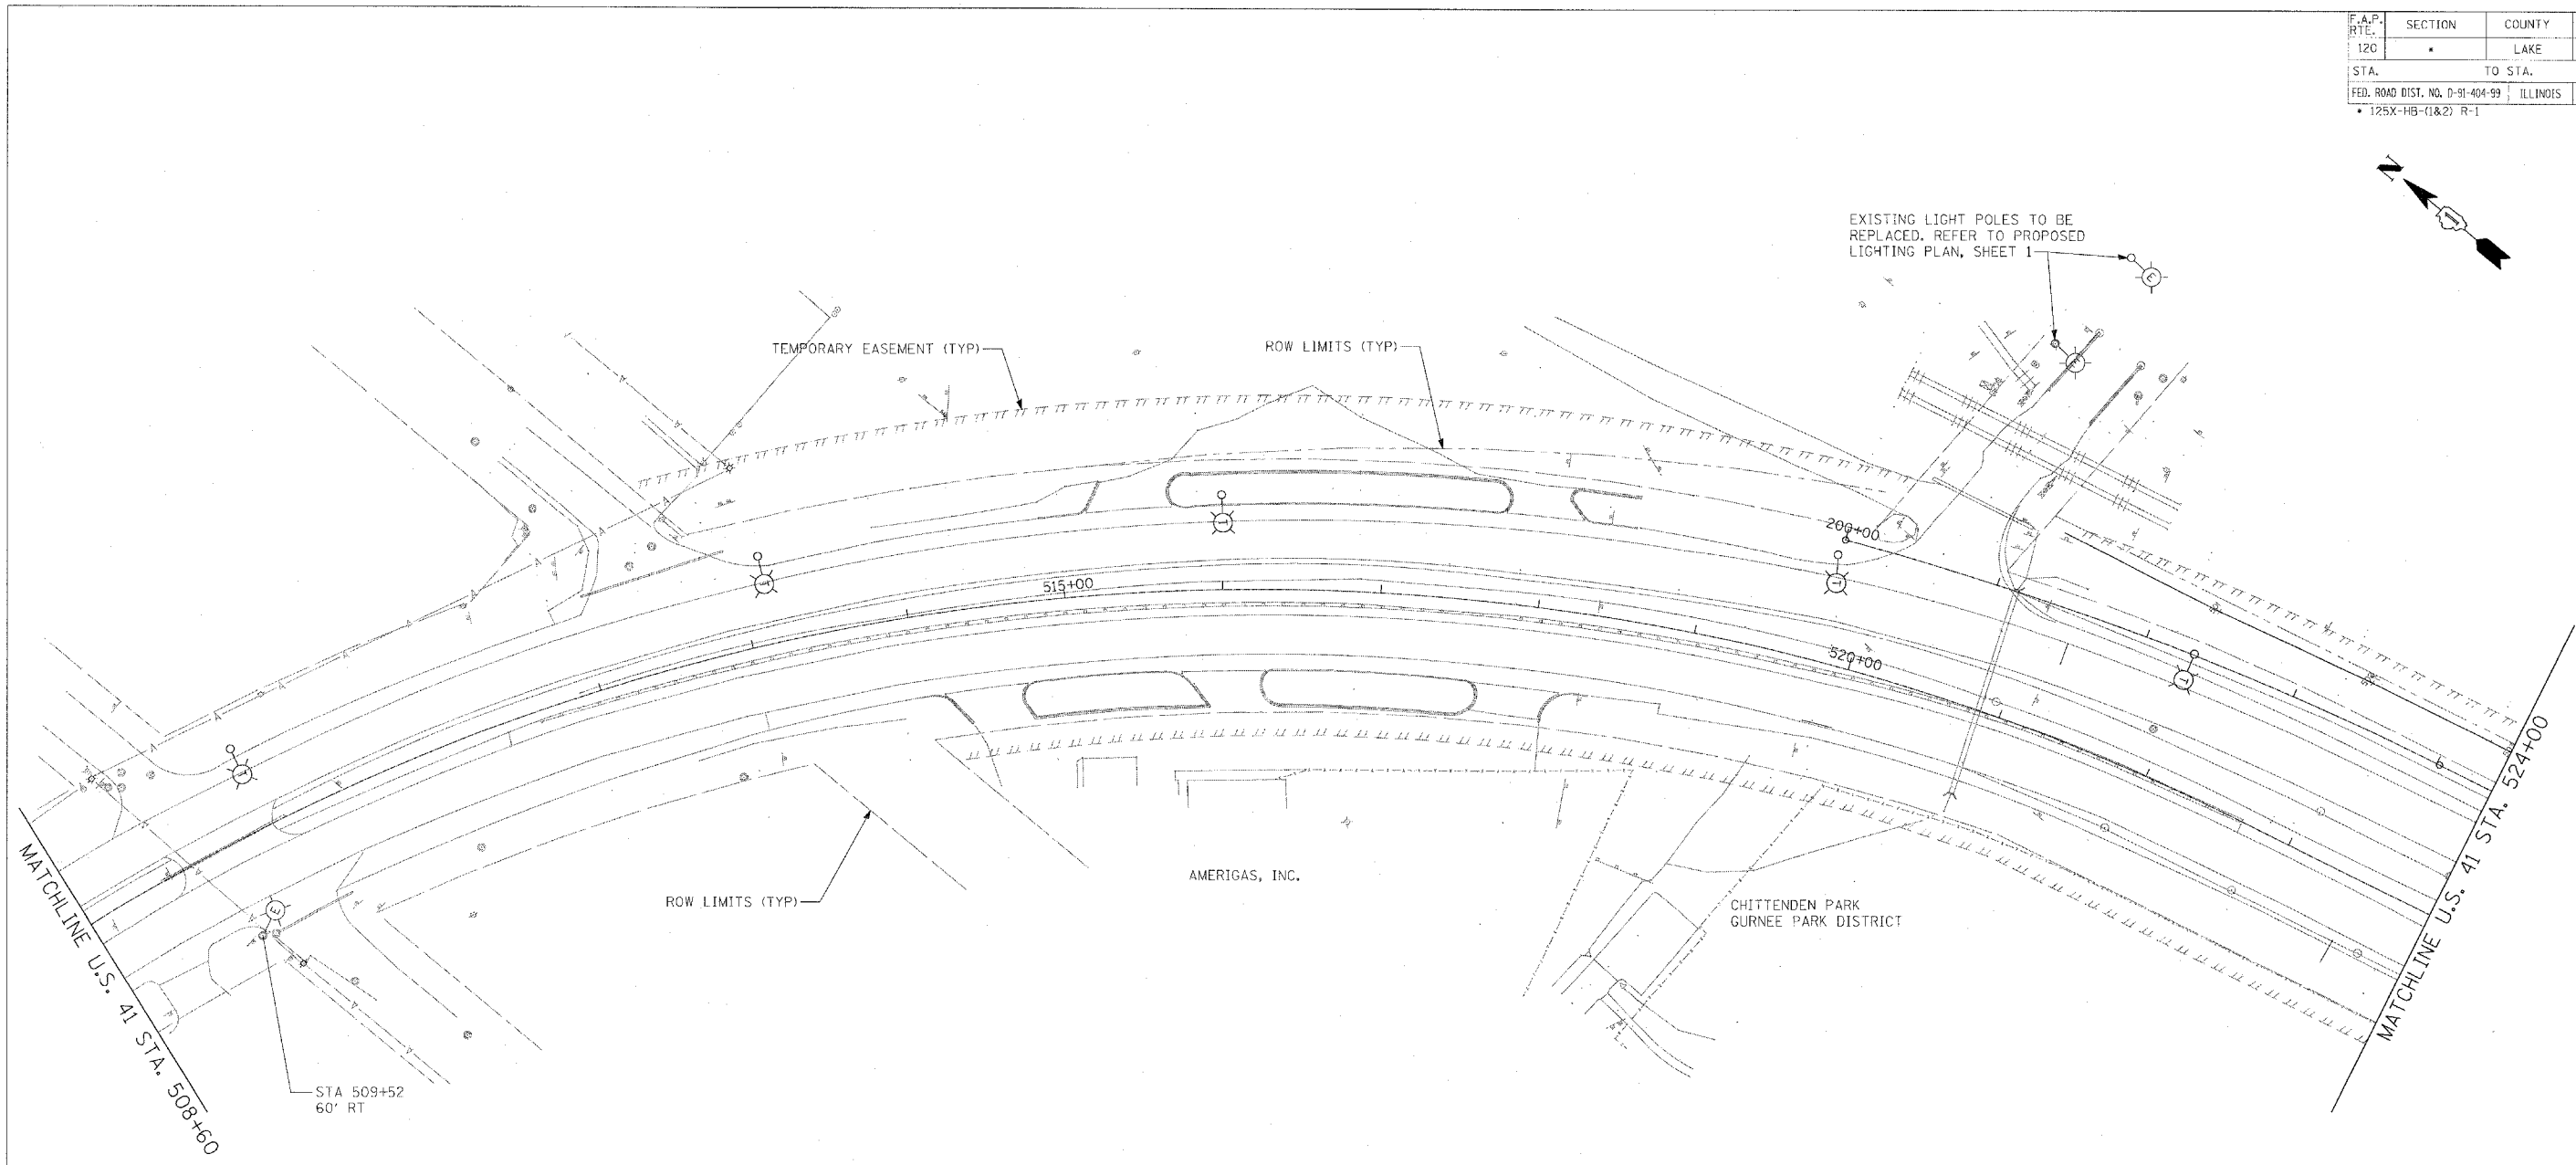

REVISIONS	
NAME	DATE
FEI	06/19/08



ILLINOIS DEPARTMENT OF TRANSPORTATION
 U.S. 41 (SKOKIE HIGHWAY)
 AT IL ROUTE 132
 LIGHTING DEMOLITION PLAN
 SHEET 1 OF 4
 US 41 - BOP TO STA. 524+00
 SCALE: 1"=50'-0"
 DATE: 05/07/08
 DRAWN BY: FO
 CHECKED BY: DEM