


**NOTES:**


1. HORIZONTAL CONTROL, VERTICAL CONTROL, CENTERLINE ALIGNMENT, TOPOGRAPHIC FEATURES, AND ALL UTILITY LINE WORK (EXCEPTING SUE QUALITY LEVEL B DESIGNATIONS) WERE SUPPLIED BY ILLINOIS DEPARTMENT OF TRANSPORTATION.

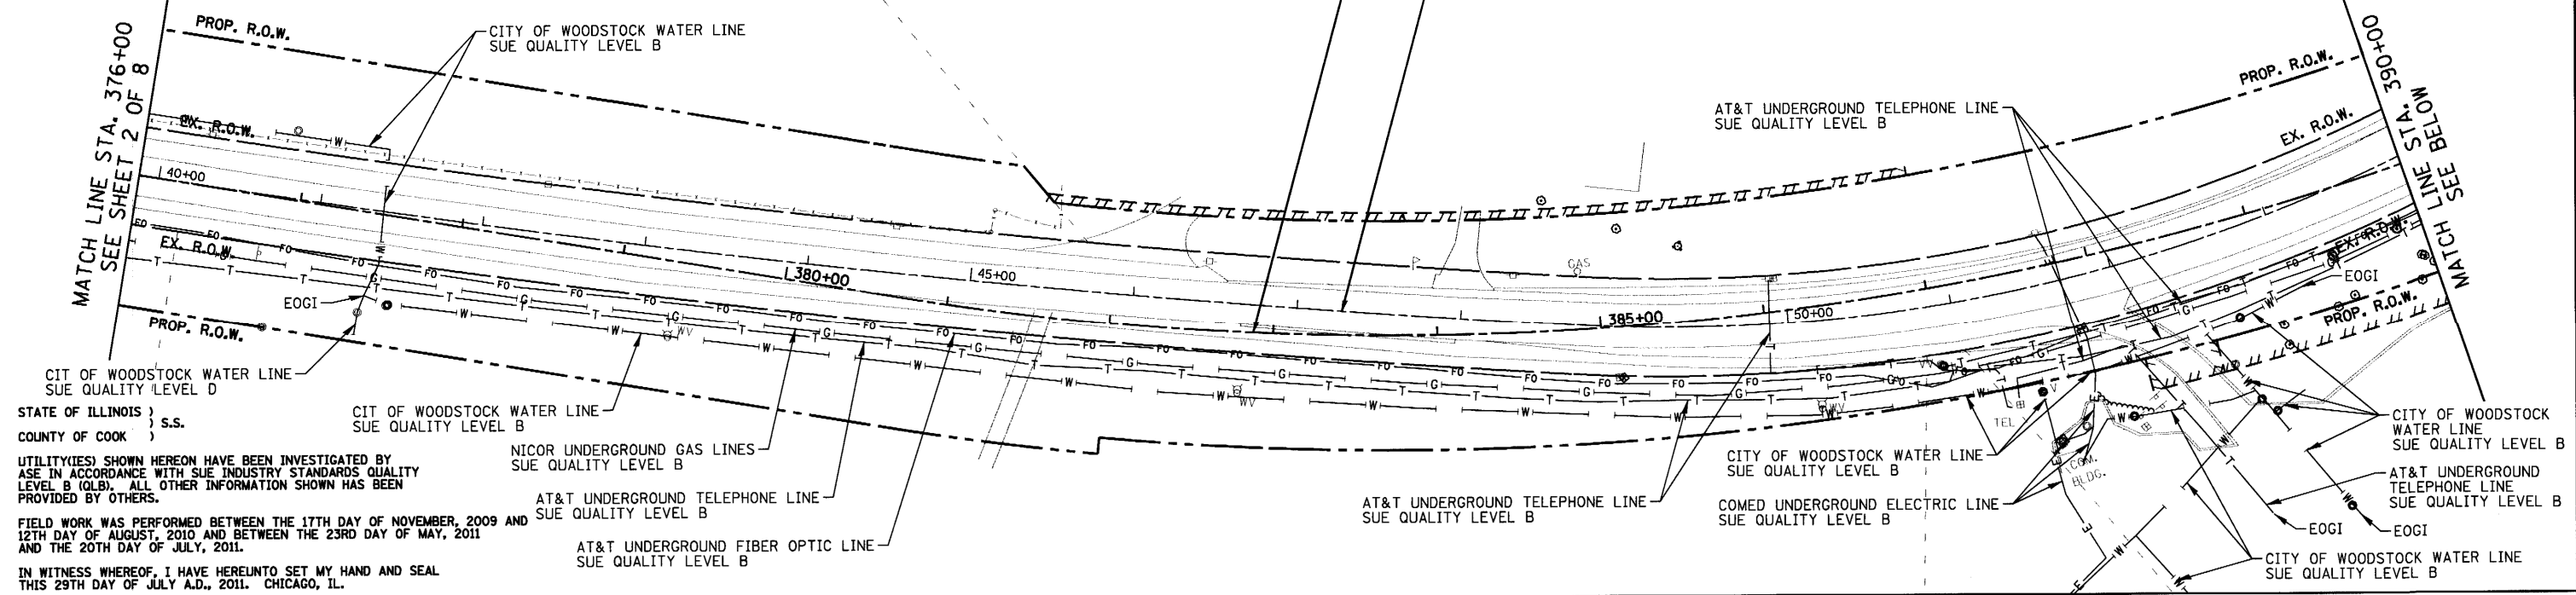

CITY OF WOODSTOCK WATER LINE SUE QUALITY LEVEL D  
 STATE OF ILLINOIS ) S.S.  
 COUNTY OF COOK )  
 UTILITIES SHOWN HEREON HAVE BEEN INVESTIGATED BY ASE IN ACCORDANCE WITH SUE INDUSTRY STANDARDS QUALITY LEVEL B (QLB). ALL OTHER INFORMATION SHOWN HAS BEEN PROVIDED BY OTHERS.  
 FIELD WORK WAS PERFORMED BETWEEN THE 17TH DAY OF NOVEMBER, 2009 AND 12TH DAY OF AUGUST, 2010 AND BETWEEN THE 23RD DAY OF MAY, 2011 AND THE 20TH DAY OF JULY, 2011.  
 IN WITNESS WHEREOF, I HAVE HEREUNTO SET MY HAND AND SEAL THIS 29TH DAY OF JULY A.D., 2011. CHICAGO, IL.

**STEVEN M. RIENKS**  
 062-044619  
 LICENSED PROFESSIONAL ENGINEER OF ILLINOIS  
 STEVEN M. RIENKS - ILLINOIS PROFESSIONAL ENGINEER NUMBER 62-044619  
 MY LICENSE EXPIRES 11/30/2011

- LEGEND**
- T ——— EXISTING UNDERGROUND TELEPHONE
  - W ——— EXISTING UNDERGROUND WATER
  - E ——— EXISTING UNDERGROUND ELECTRIC
  - G ——— EXISTING UNDERGROUND GAS
  - CTV ——— EXISTING UNDERGROUND CABLE TV
  - EOGI ——— END OF GEOPHYSICAL INFORMATION

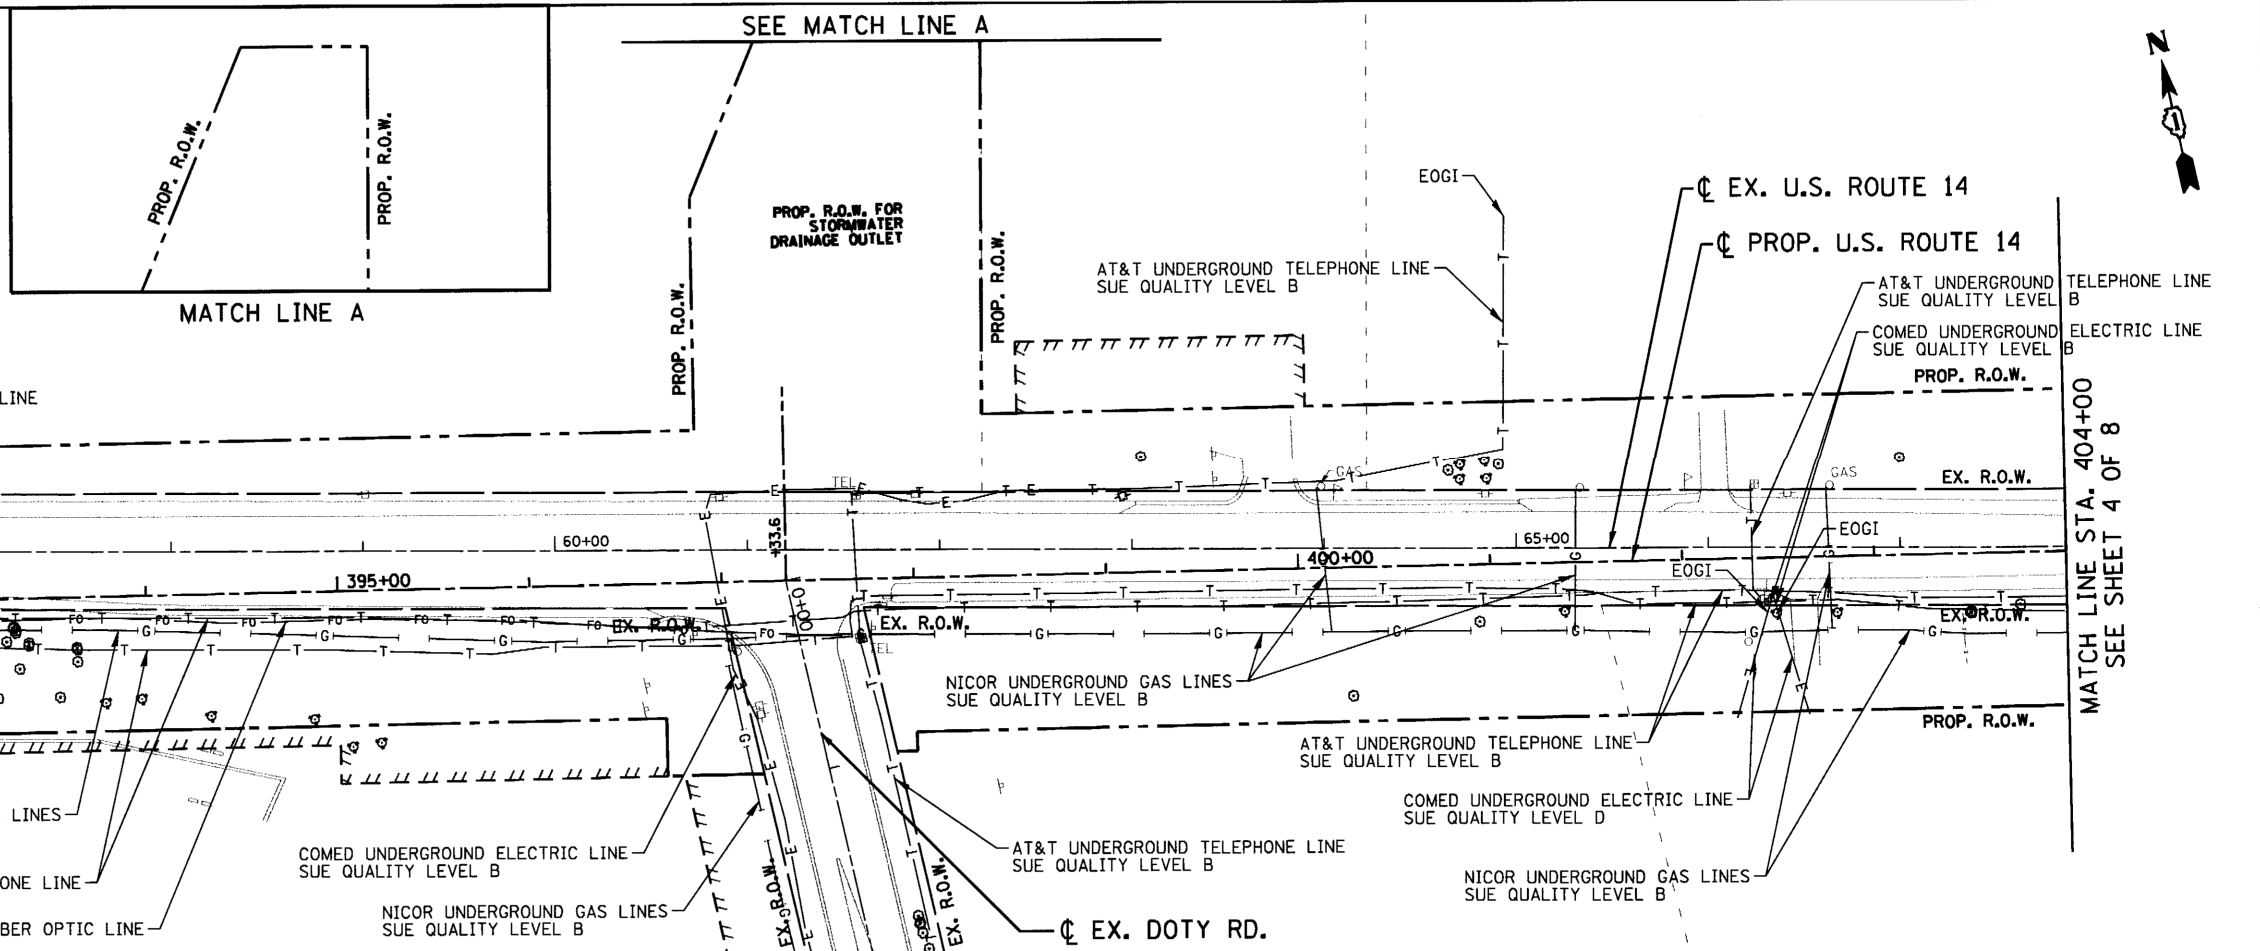

**AMERICAN**  
 SURVEYING & ENGINEERING, P.C.  
 SURVEYORS - ENGINEERS  
 GEODESISTS - MAPPING SCIENTISTS  
 Chicago 312-277-2000 / Fax 312-277-2002  
 Dtxora 815-288-6231 / Fax 815-288-6277  
 Aurora 603-897-4105 / Fax 630-897-4121  
 Illinois Professional Design Firm No. 184-003192

FILE NAME = Utl083.dgn	USER NAME = **user**	DESIGNED -	REVISED - 7-22-11 ADD. INFORMATION
		DRAWN -	REVISED -
		CHECKED -	REVISED -
		DATE - >DATE	REVISED -

**STATE OF ILLINOIS**  
 DEPARTMENT OF TRANSPORTATION  
 U.S. ROUTE 14

**UTILITY PLANS**  
 BY S.U.E.  
 STA. 376+00 TO STA. 404+00  
 SCALE: 1"=50'  
 SHEET NO. 3 OF 8 SHEETS STA. TO STA.

F.A.P. RTE. 305	SECTION 27R-2	COUNTY MCHENRY	TOTAL SHEETS	SHEET NO.
				CONTRACT NO. 62268
FED. ROAD DIST. NO. 1 ILLINOIS FED. AID PROJECT				



TENG & ASSOCIATES, INC.  
 ENGINEERS/ARCHITECTS/PLANNERS  
 CHICAGO, ILLINOIS