

 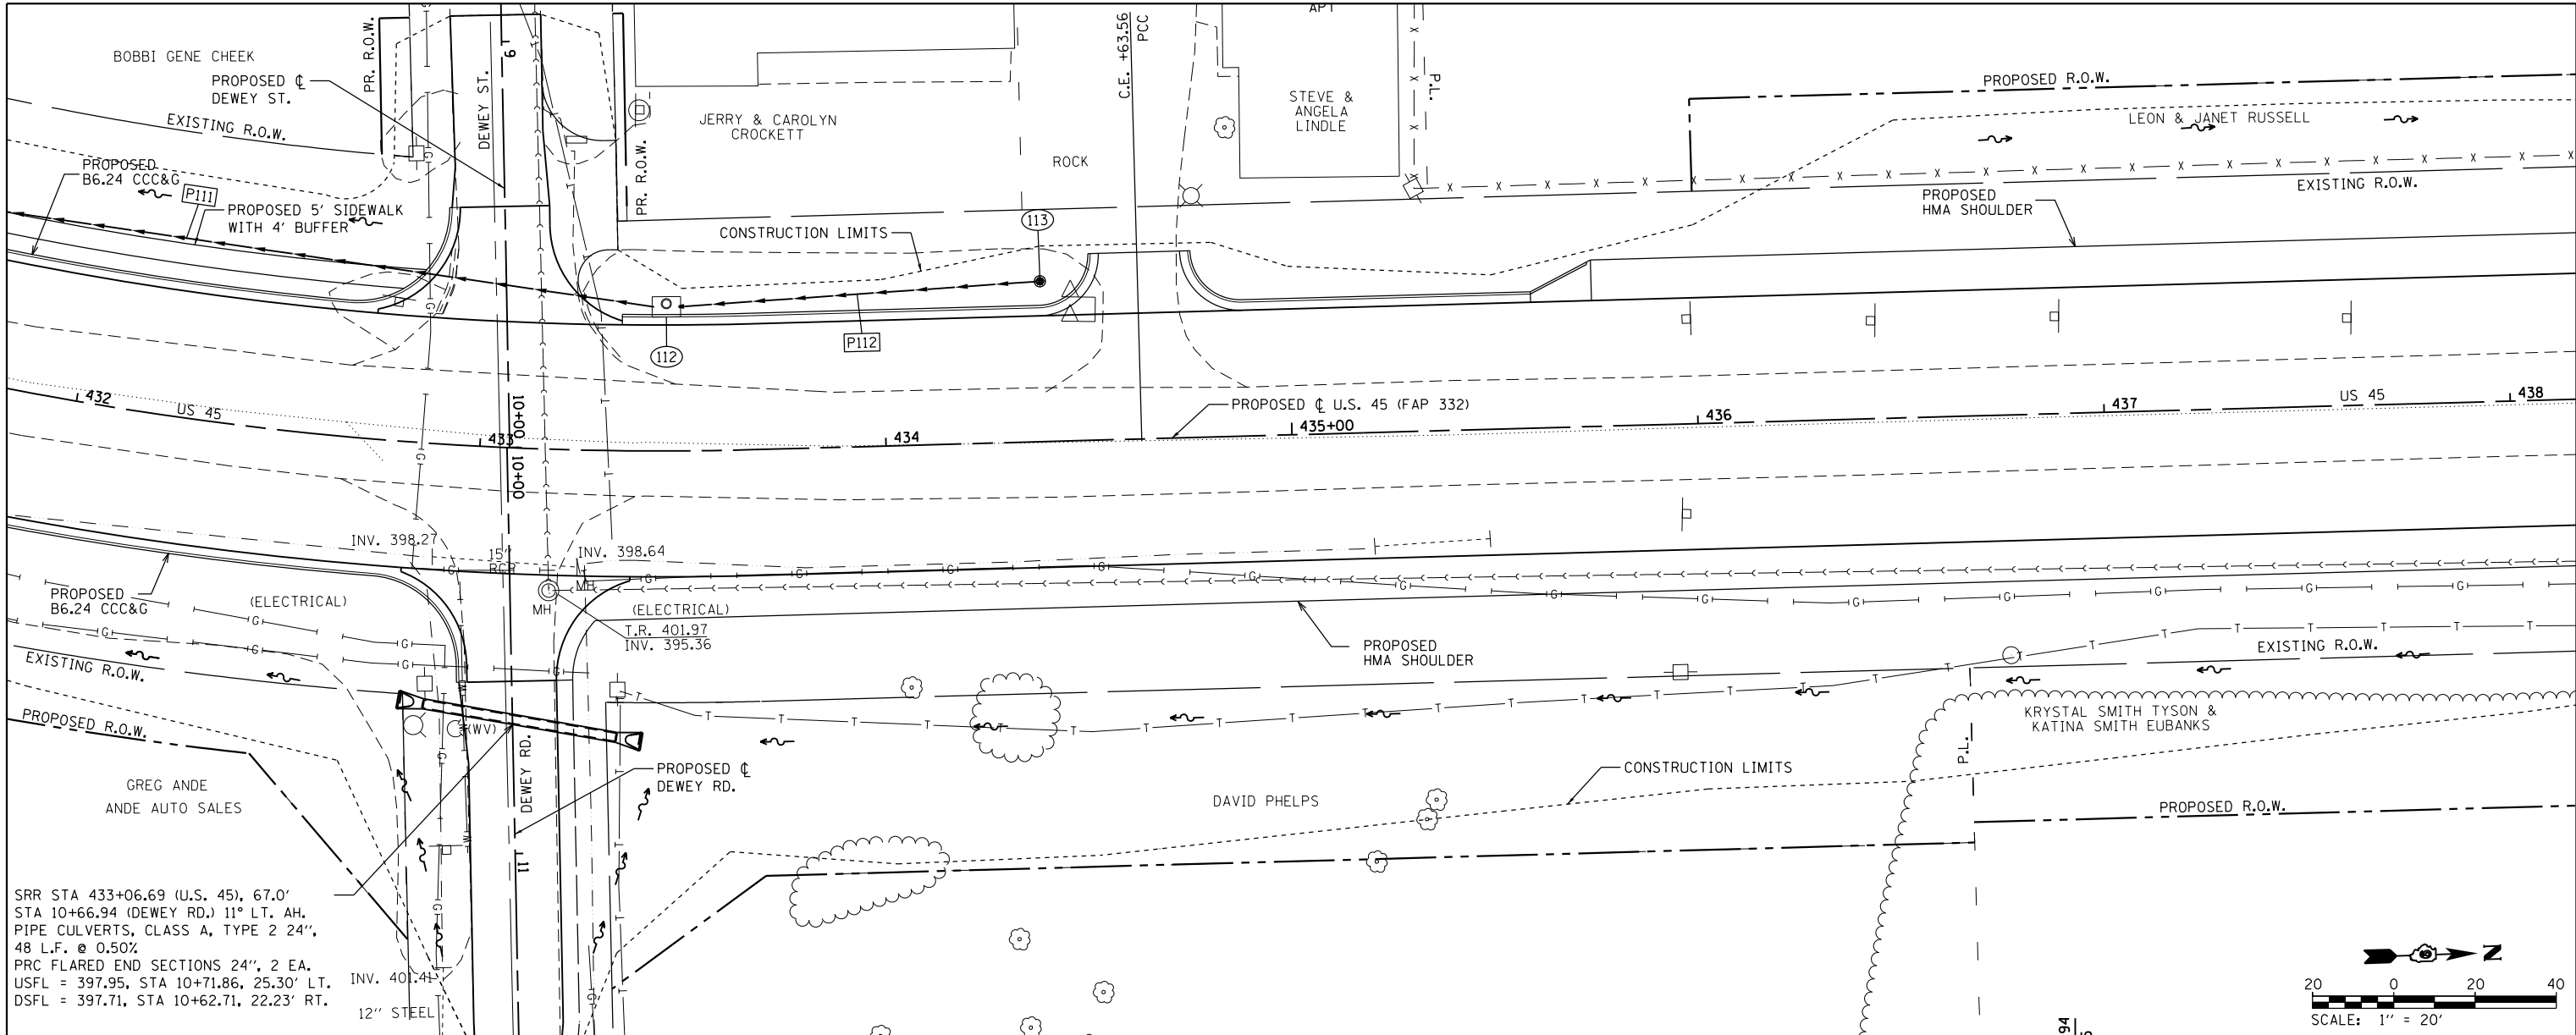


| | | |
|------|-------------------|------|
| PLAN | SURVEYED | DATE |
| | PLOTTED | |
| | NOTE BOOK | |
| | GRADES CHECKED | |
| | ALIGNMENT CHECKED | |
| | STRUCTURE | |
| | NO. 11297 | |
| | FILE NAME | |

| | | |
|---------|----------------|------|
| PROFILE | SURVEYED | DATE |
| | PLOTTED | |
| | NOTE BOOK | |
| | GRADES CHECKED | |
| | STRUCTURE | |
| | NO. 11297 | |
| | FILE NAME | |

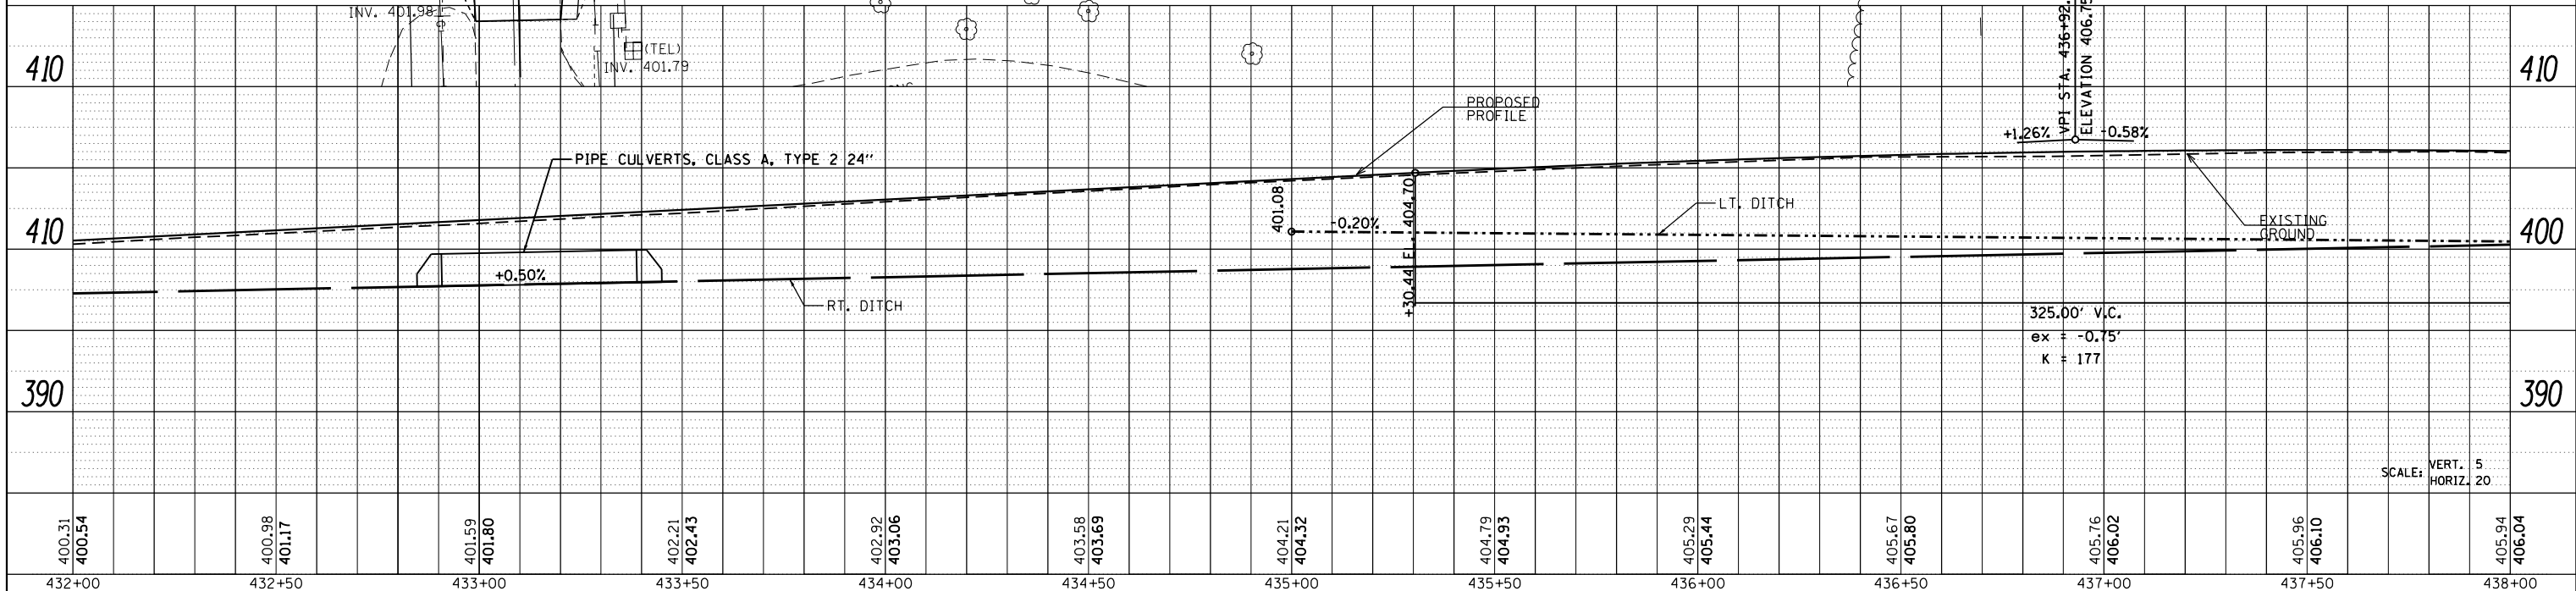

SRR STA 433+06.69 (U.S. 45), 67.0'
 STA 10+66.94 (DEWEY RD.) 11° LT. AH.
 PIPE CULVERTS, CLASS A, TYPE 2 24",
 48 L.F. @ 0.50%
 PRC FLARED END SECTIONS 24", 2 EA.
 USFL = 397.95, STA 10+71.86, 25.30' LT.
 DSFL = 397.71, STA 10+62.71, 22.23' RT.
 12" STEEL



| | | | | | | | | | | | | | | | | | | | | | | | | | | |
|--------|--------|--------|--------|--------|--------|--------|--------|--------|--------|--------|--------|--------|--------|--------|--------|--------|--------|--------|--------|--------|--------|--------|--------|--------|--------|--|
| 400.31 | 400.54 | 400.98 | 401.17 | 401.59 | 401.80 | 402.21 | 402.43 | 402.92 | 403.06 | 403.58 | 403.69 | 404.21 | 404.32 | 404.79 | 404.93 | 405.29 | 405.44 | 405.67 | 405.80 | 405.76 | 406.02 | 405.96 | 406.10 | 405.94 | 406.04 | |
| 432+00 | 432+50 | 433+00 | 433+50 | 434+00 | 434+50 | 435+00 | 435+50 | 436+00 | 436+50 | 437+00 | 437+50 | 438+00 | | | | | | | | | | | | | | |

FILE NAME =
 P:\Projects\2011 Projects\11297 - I00T US45

| | | |
|--|------------|-----------|
| USER NAME = bemory | DESIGNED - | REVISED - |
| Ph2\CV\CADD Sheets\0978077-shd-drain-US45-UDRAWN | DRAWN - | REVISED - |
| PLOT SCALE = 40.0000' / in. | CHECKED - | REVISED - |
| PLOT DATE = 4/30/2014 | DATE - | REVISED - |

STATE OF ILLINOIS
DEPARTMENT OF TRANSPORTATION

DRAINAGE PLAN & PROFILE
U.S. 45
 SCALE: 1" = 20' SHEET OF SHEETS STA. 432+00.00 TO STA. 438+00.00

| | | | | |
|--------------------|------------|--------|---------------------------|-----------|
| F.A.P. RTE. | SECTION | COUNTY | TOTAL SHEETS | SHEET NO. |
| 332 | (29,30)R-1 | SALINE | 745 | 348 |
| CONTRACT NO. 78077 | | | ILLINOIS FED. AID PROJECT | |