 


**UN053**

REVISIONS		
NUMBER	BY	DATE




UNIVERSITY OF ILLINOIS  
 WILLARD AIRPORT  
 SAVOY, ILLINOIS

**BASE BID - REALIGN AND WIDEN TAXIWAY C  
 PROPOSED LIGHTING LAYOUT 3**

© Copyright CMT, Inc.  
**CMT**  
 CRAWFORD, MURPHY & TILLY, INC.  
 CONSULTING ENGINEERS  
 License No. 184-000613

DESIGN BY:	CBG
DRAWN BY:	ADD
CHECKED BY:	CET
APPROVED BY:	CET
DATE:	JUNE 27, 2014
JOB No:	13059-02-00
IL PROJ. NO.	CMI-4347
AIP PROJ. NO.	3-17-0016-XX
SHEET	42 OF 83 SHEETS

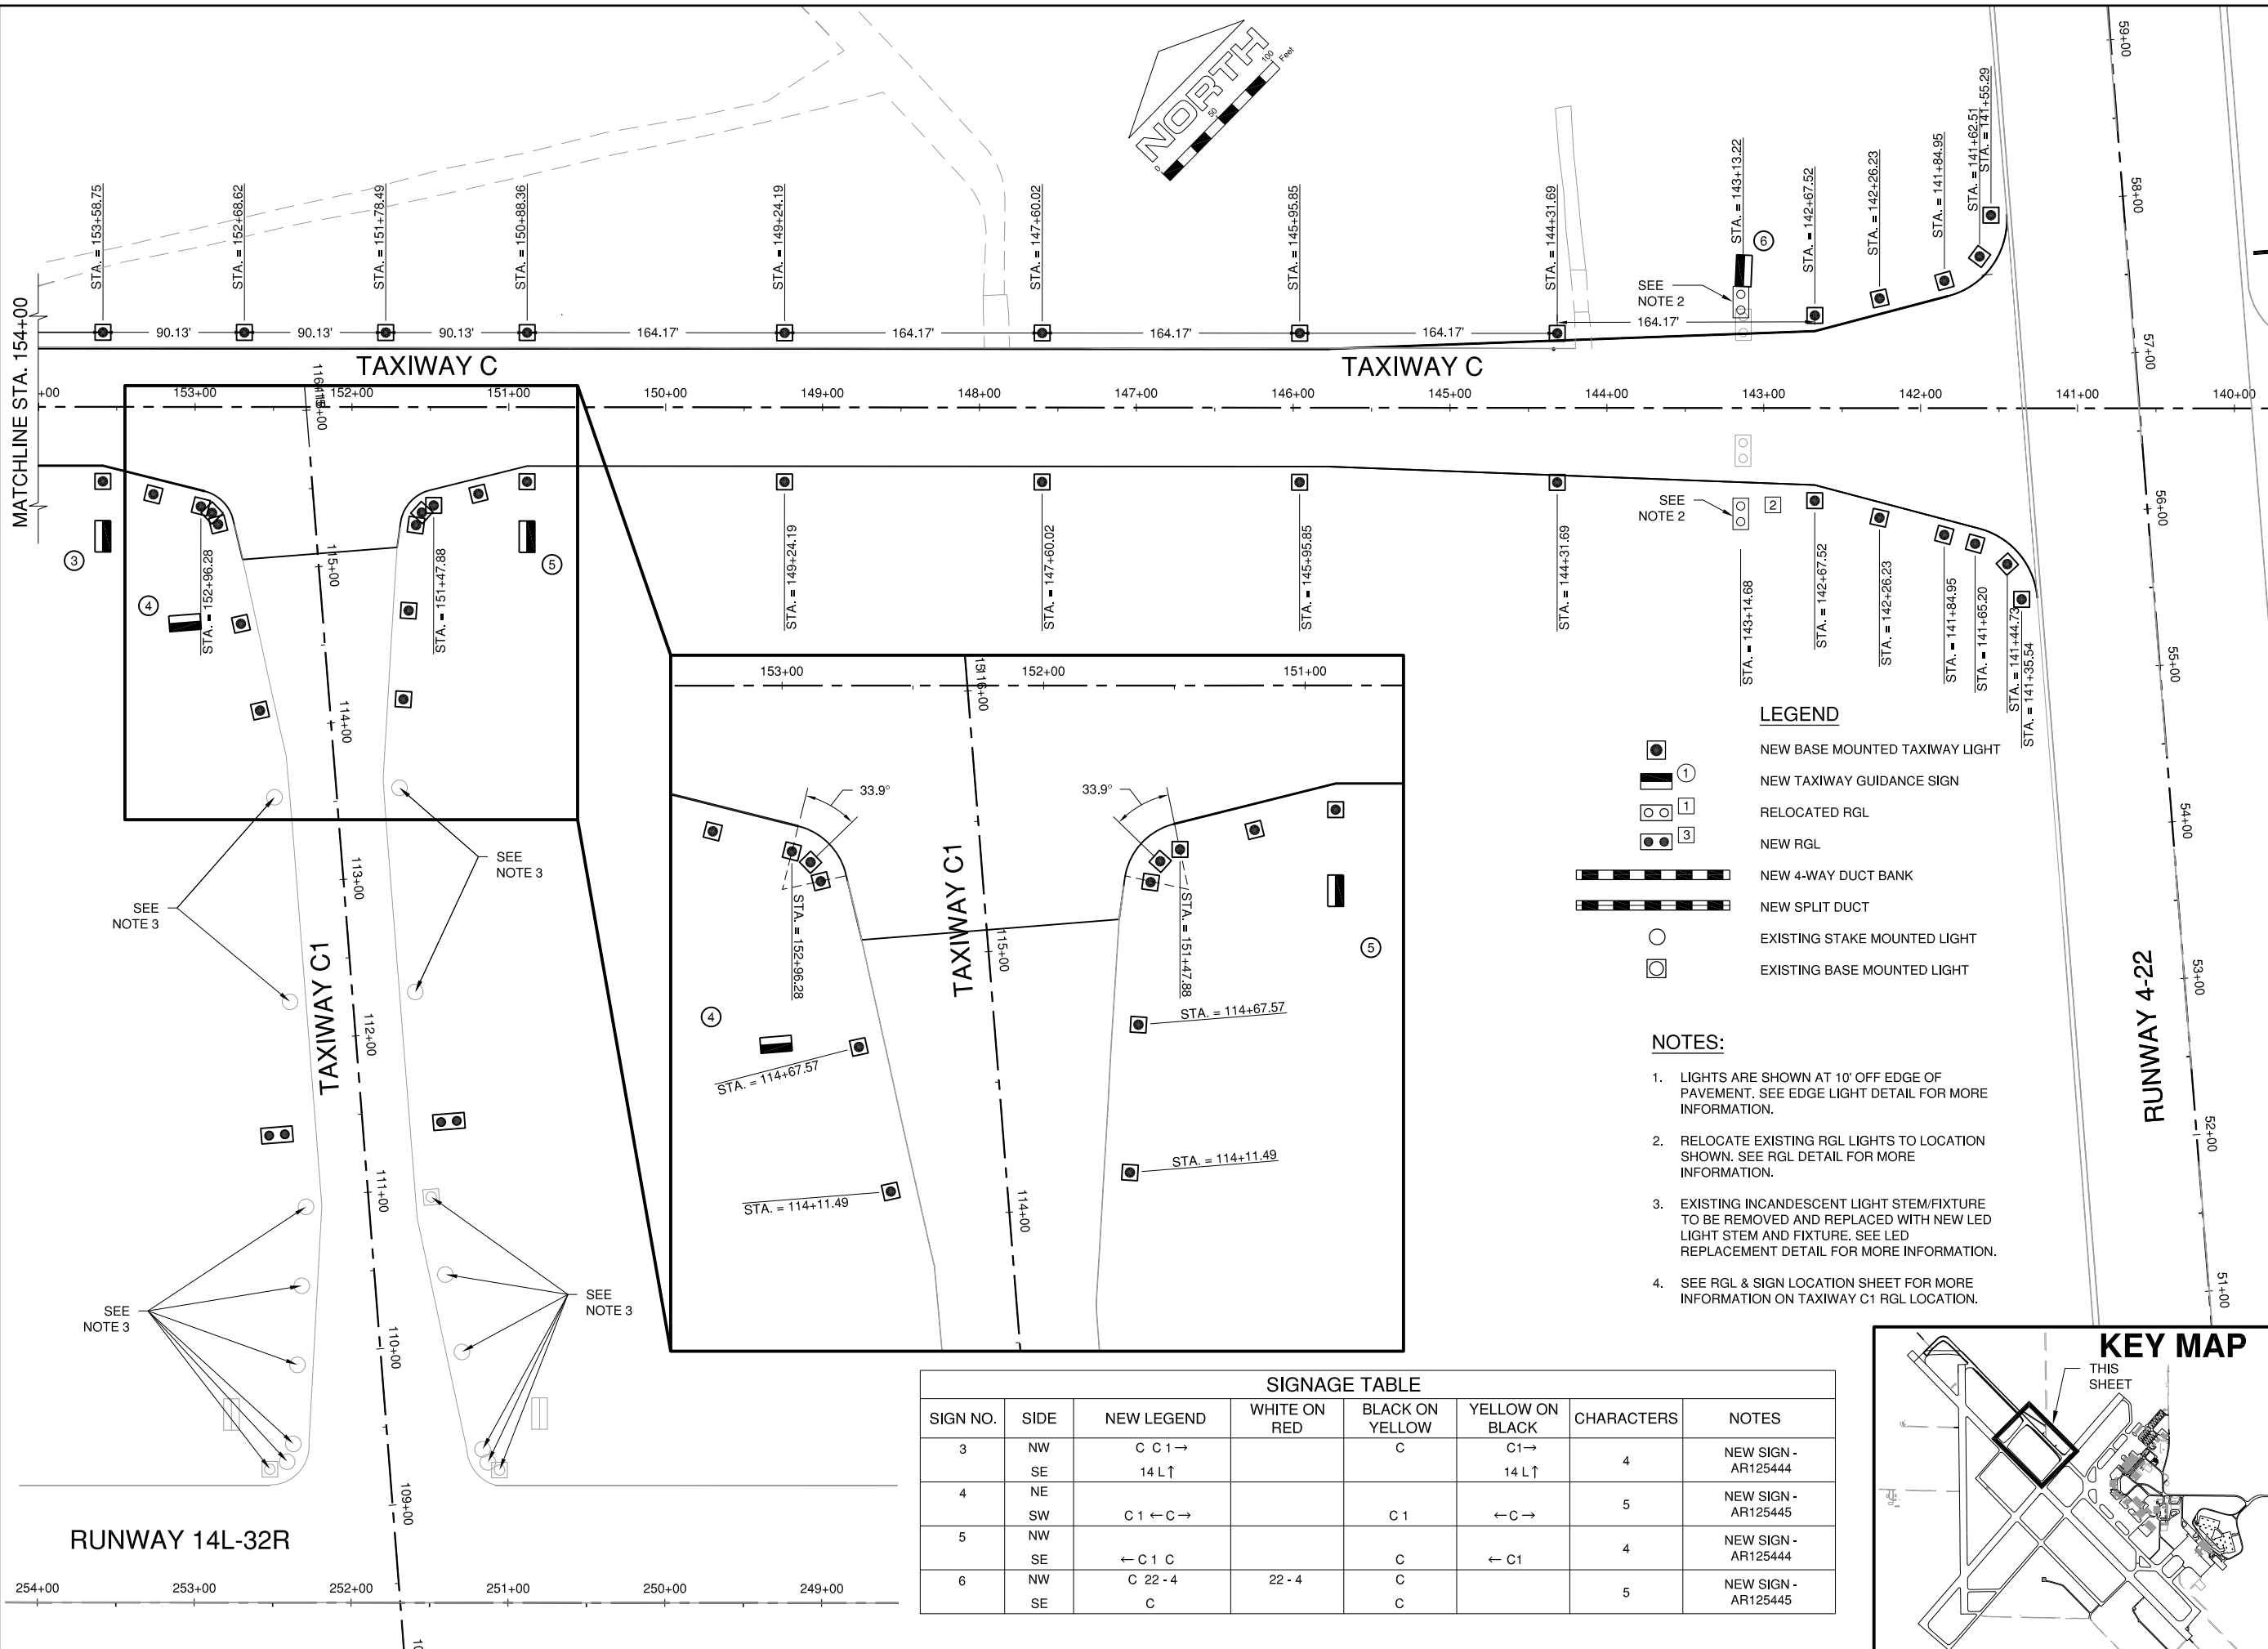

- LEGEND**
- NEW BASE MOUNTED TAXIWAY LIGHT
  - NEW TAXIWAY GUIDANCE SIGN
  - RELOCATED RGL
  - NEW RGL
  - NEW 4-WAY DUCT BANK
  - NEW SPLIT DUCT
  - EXISTING STAKE MOUNTED LIGHT
  - EXISTING BASE MOUNTED LIGHT

- NOTES:**
1. LIGHTS ARE SHOWN AT 10' OFF EDGE OF PAVEMENT. SEE EDGE LIGHT DETAIL FOR MORE INFORMATION.
  2. RELOCATE EXISTING RGL LIGHTS TO LOCATION SHOWN. SEE RGL DETAIL FOR MORE INFORMATION.
  3. EXISTING INCANDESCENT LIGHT STEM/FIXTURE TO BE REMOVED AND REPLACED WITH NEW LED LIGHT STEM AND FIXTURE. SEE LED REPLACEMENT DETAIL FOR MORE INFORMATION.
  4. SEE RGL & SIGN LOCATION SHEET FOR MORE INFORMATION ON TAXIWAY C1 RGL LOCATION.

SIGNAGE TABLE							
SIGN NO.	SIDE	NEW LEGEND	WHITE ON RED	BLACK ON YELLOW	YELLOW ON BLACK	CHARACTERS	NOTES
3	NW SE	C C1 → 14 L ↑		C	C1 → 14 L ↑	4	NEW SIGN - AR125444
4	NE SW	C1 ← C →		C 1	← C →	5	NEW SIGN - AR125445
5	NW SE	← C 1 C		C	← C 1	4	NEW SIGN - AR125444
6	NW SE	C 22 - 4 C	22 - 4	C C		5	NEW SIGN - AR125445

