
 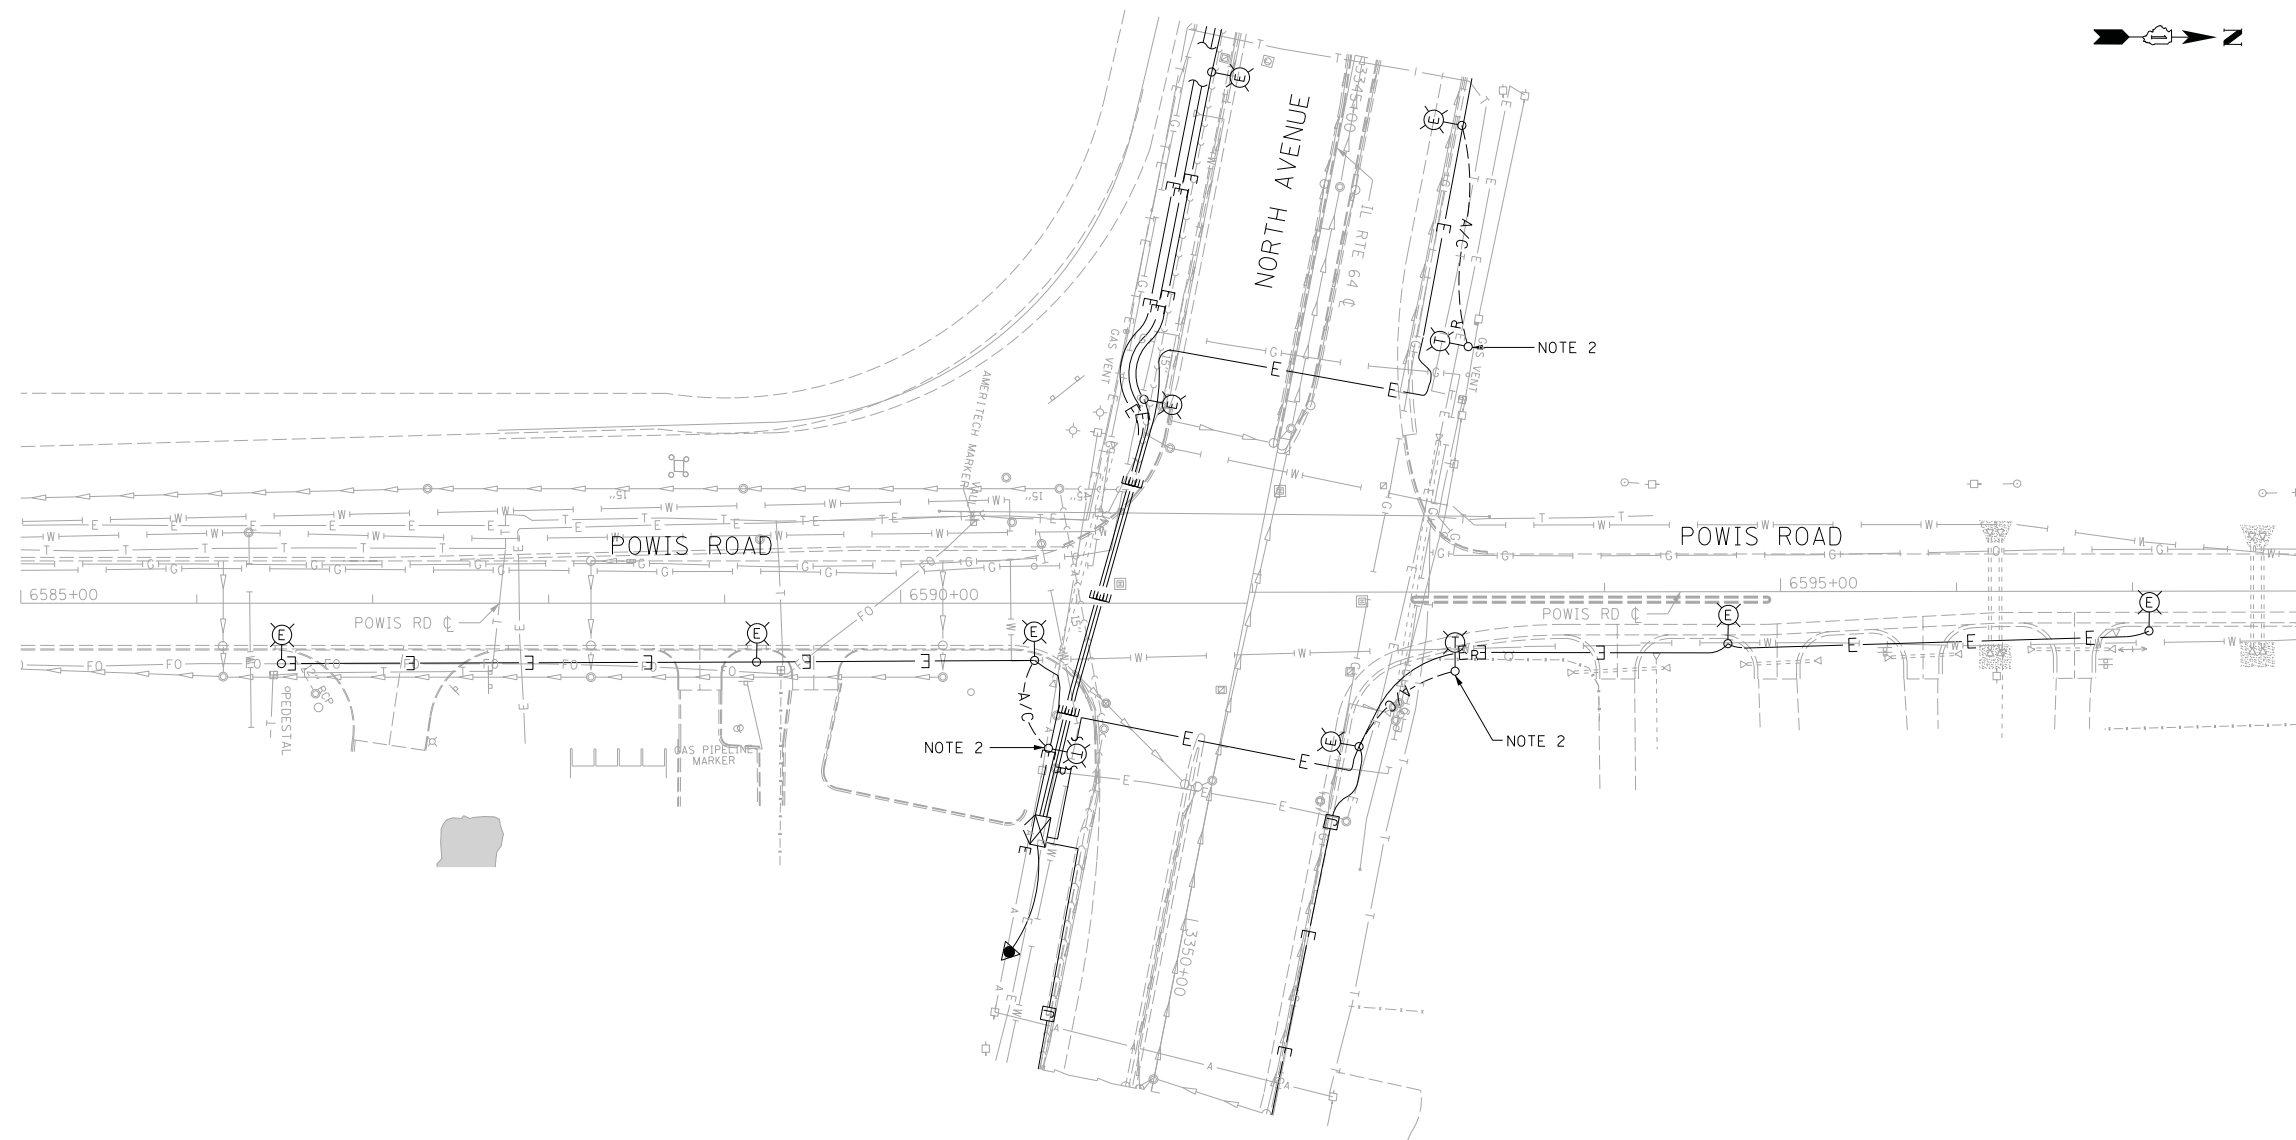


F.A.P. RTE.	SECTION	COUNTY	TOTAL SHEETS	SHEET NO.
307	130N-3 (11)	DUPAGE	141	117
STA.		TO STA.		
FED. ROAD DIST. NO.	ILLINOIS	FED. AID PROJECT		

NOTES: 60R46

- SEE SHEET E-01 FOR ELECTRICAL SYMBOLS, CALL-OUT SAMPLES, ABBREVIATIONS AND GENERAL NOTES.
- THE TEMPORARY WOOD POLES, MAST ARMS, LUMINAIRES AND AERIAL CABLES SHALL BE REMOVED, BECOME PROPERTY OF THE CONTRACTOR, AND PROPERLY DISPOSED OF OFFSITE.



E-02

REVISIONS		ILLINOIS DEPARTMENT OF TRANSPORTATION F.A.P. ROUTE 307 (ILLINOIS ROUTE 64)
NAME	DATE	
		EXISTING/DEMOLITION ROADWAY LIGHTING PLAN POWIS ROAD STA. 6585+00 TO STA. 6598+00
SCALE: 1" = 50'		DRAWN BY: AFC
DATE: FEBRUARY 1, 2013		CHECKED BY: WDS

