


SIGN DETAIL

1:75

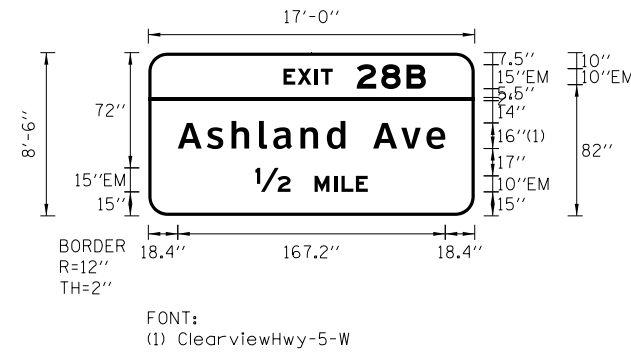

FONT:
(1) ClearviewHwy-5-W

SIGN NUMBER	WB-03-BM
WIDTH x HGHT.	17'-0" x 8'-6"
BORDER WIDTH	2"
CORNER RADIUS	12"
MOUNTING	Overhead
BACKGROUND	TYPE: ZZ Retro Reflective
	COLOR: Green
LEGEND/BORDER	TYPE: Reflective
	COLOR: White/White

SYMBOL	ROT	X	Y	WID	HT

Panel Style: guide_exp_advance_a.ssi
Dimensions are in inches.tenths

Letter locations are panel edge to lower left corner

LETTER POSITIONS (X)															LENGTH	SERIES/SIZE		
E	X	I	T	2	8	B											EM 2000	
84.5	93.3	104.1	107.9	130.3	145.6	161.4											89	10,15
A	s	h	l	a	n	d		A	v	e							167.2	ClearviewHwy-5-W
18.4	36.7	52	69.2	78.1	95.1	111.6	123.3	140.5	158.1	173.9							1613	
1/2	M	I	L	E													70.3	EM 2000
66.9	103.9	116	120.8	129.8														15,10

FILE PATH = ...



DI60W25-sht-Sign-Bridge-Detail-02
USER NAME = moronik
PLOT SCALE = 5.0000 ' / in.
PLOT DATE = 5/15/2013

DESIGNED - AFC	REVISED -
DRAWN - AFC	REVISED -
CHECKED - DBM	REVISED -
DATE - 5/14/2013	REVISED -

STATE OF ILLINOIS
DEPARTMENT OF TRANSPORTATION

OVERHEAD SIGN PANEL DETAILS
SCALE: NTS SHEET 2 OF 2 SHEETS STA. TO STA.

F.A.I. RTE.	SECTION	COUNTY	TOTAL SHEETS	SHEET NO.
90/94/290	2013-007R	COOK	317	115
CONTRACT NO. 60W25			ILLINOIS FED. AID PROJECT	