



FILE PATH = p:\388035\pmt\escomon\me\local\p\AECD\00\Documents\01_Americas\Transportation\60269938_Circle\Phase\1\000_CAD\016_Electrical\Sheets\60W25_Contract\160W25-sht-Light-03

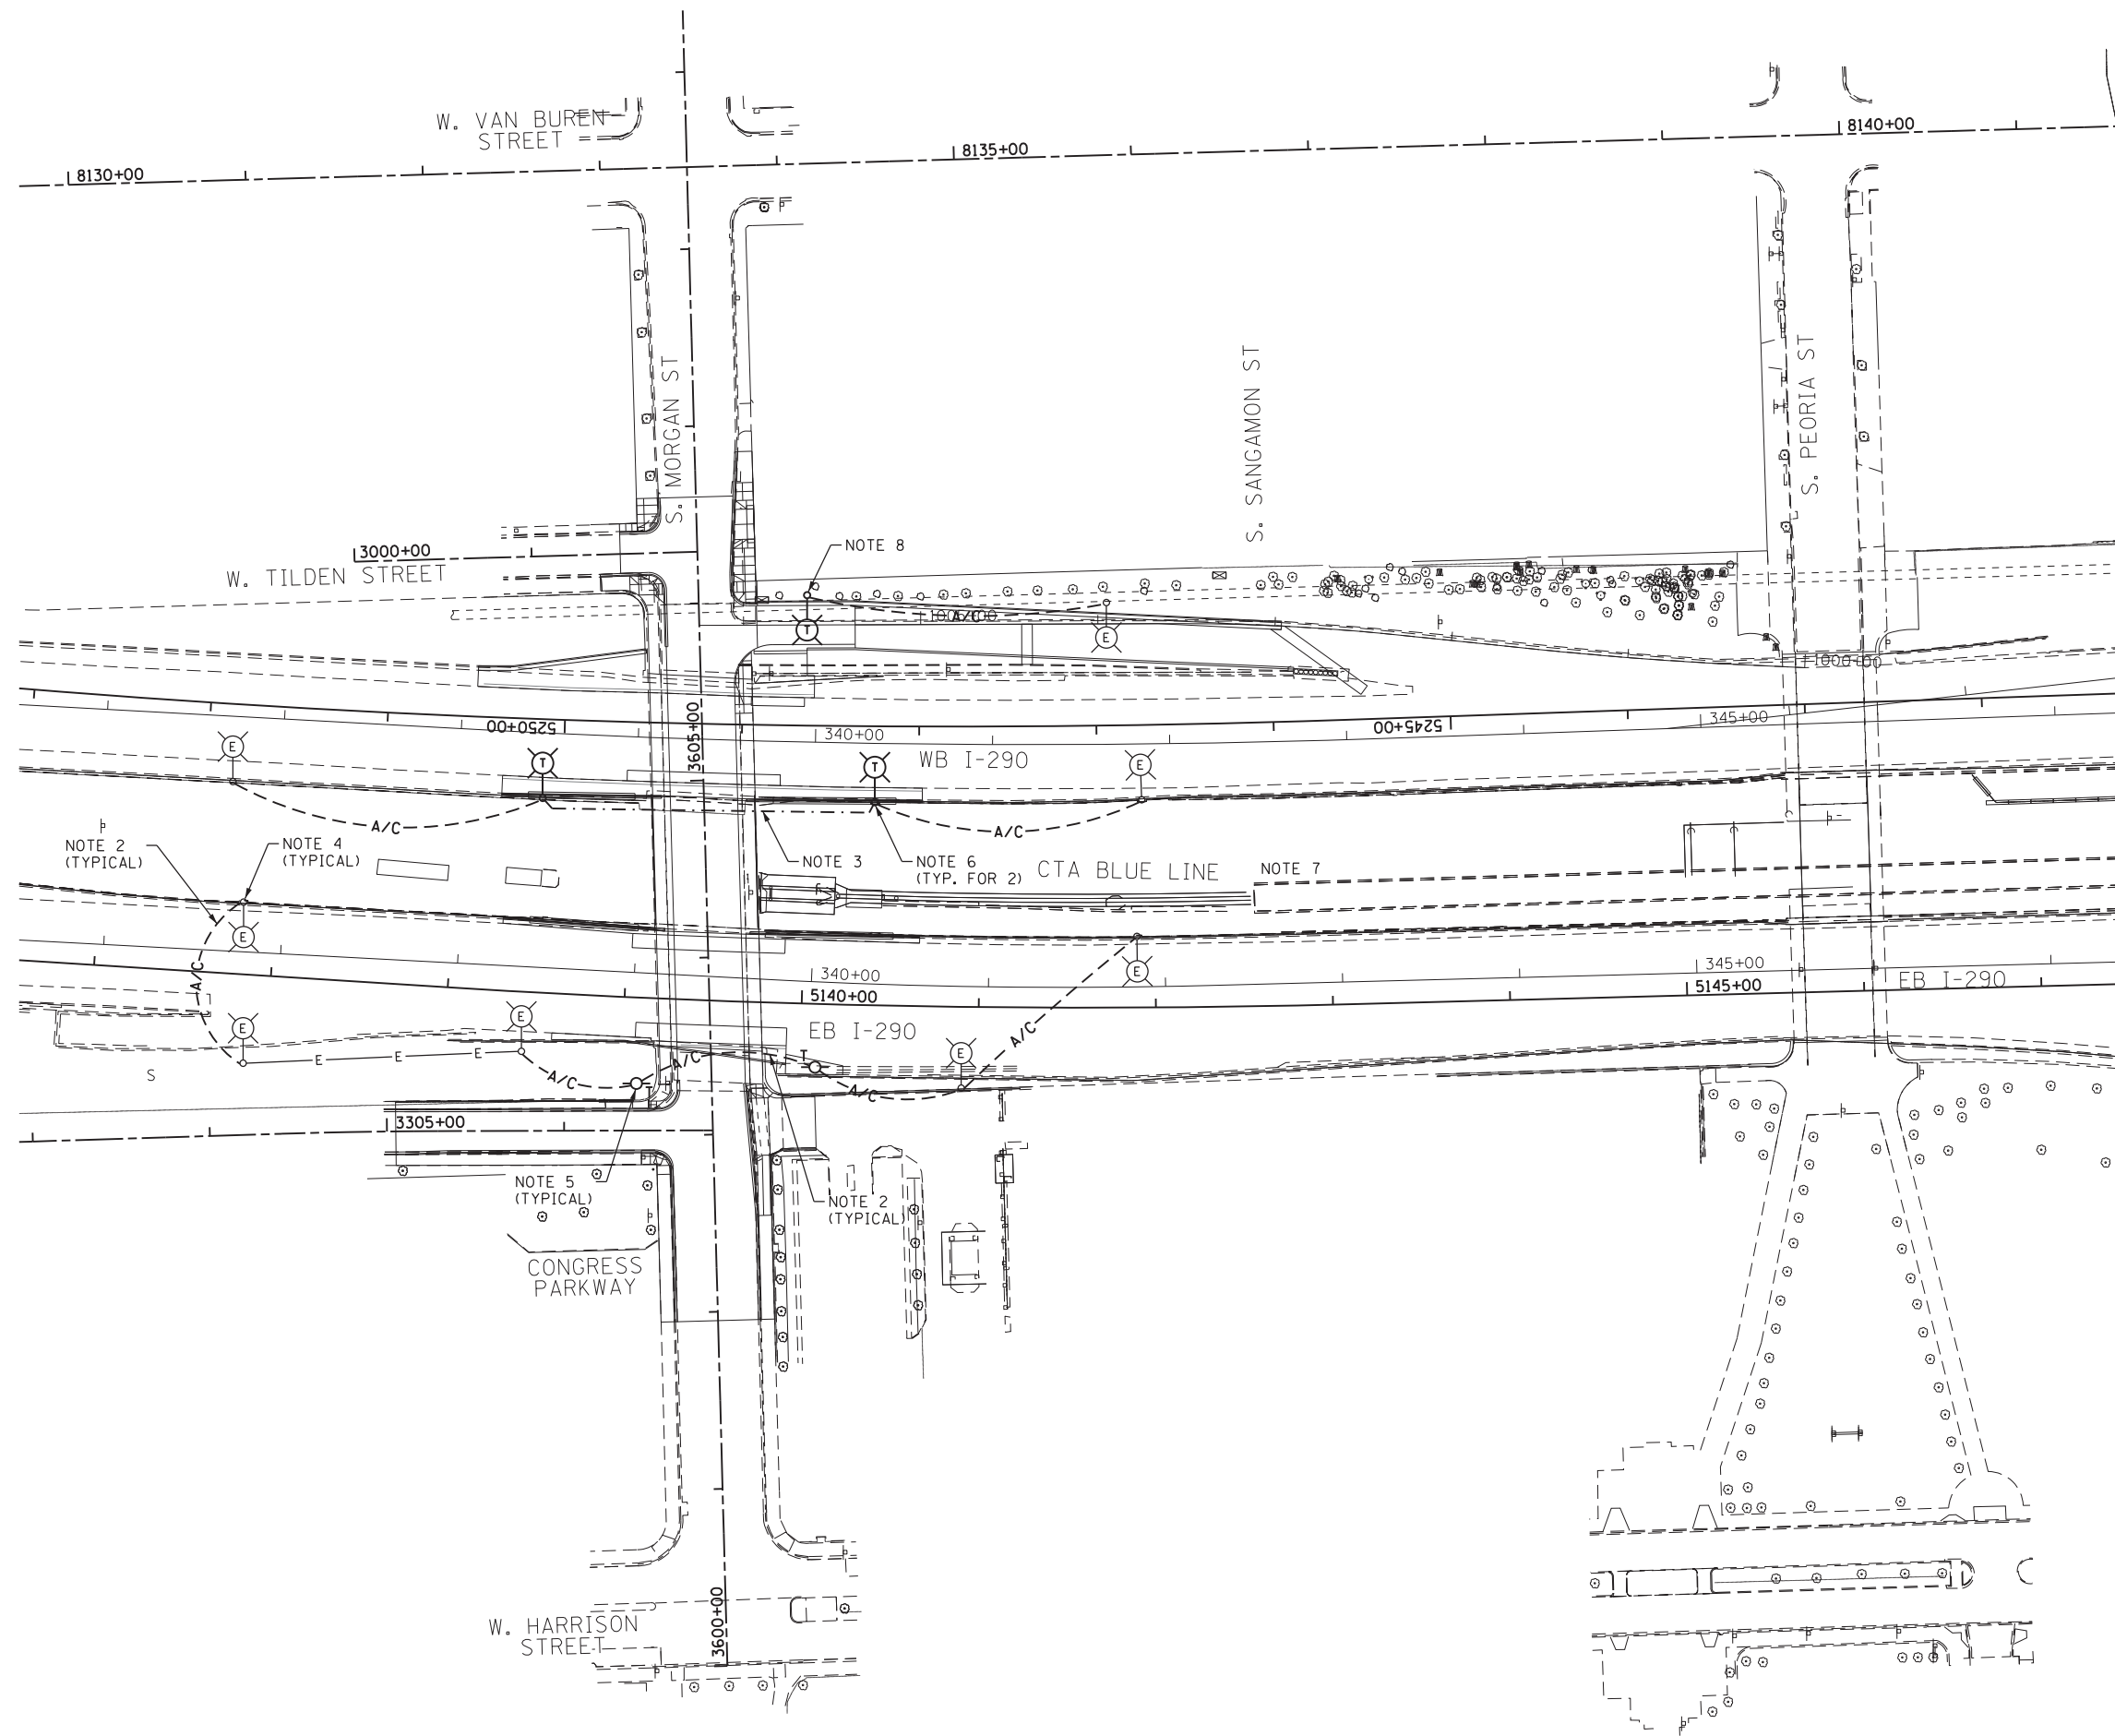

- NOTES:**
- SEE DRAWING E-01 FOR IDOT ELECTRICAL SYMBOLS.
 - PROVIDE A TEMPORARY AERIAL CABLE POWER FEED FOR THE ROADWAY LIGHTING CIRCUITS. THE FEED SHALL BE 3-1/C NO. 2 WITH MESSENGER.
 - PROVIDE A TEMPORARY POWER FEED FOR THE ROADWAY LIGHTING CIRCUITS. THE FEED SHALL BE 3-1/C NO. 2 WITH 1/C NO. 4 GROUND XLP TYPE USE CABLES IN A 1 1/2" UNIT DUCT INSTALLED BEHIND THE MEDIAN BARRIER WALL. THIS TEMPORARY FEED SHALL BE PROTECTED DURING THE BRIDGE RECONSTRUCTION AND MEDIAN BARRIER WORK AND WILL BE REMOVED AT THE CONCLUSION OF THE PROJECT. REMOVAL OF THIS FEED WILL NOT BE PAID FOR SEPARATELY AND WILL BE INCLUDED IN THE COST OF THE "UNIT DUCT" PAY ITEM.
 - ATTACH AERIAL CABLES TO EXISTING LIGHT POLES.
 - PROVIDE 25 FEET OF SLACK CABLE ON EACH TEMPORARY WOOD POLE TO ALLOW FOR RELOCATION OF WOOD POLES DURING CONSTRUCTION.
 - INSTALL THE TEMPORARY LIGHTING UNITS IN GRADE BEHIND THE PERMANENT MEDIAN BARRIER WALL.
 - THIS DRAWING SHOWS THE INTERIM TEMPORARY POWER FEEDS REQUIRED TO BE INSTALLED PRIOR TO THE MORGAN STREET BRIDGE RECONSTRUCTION WORK. DRAWING NO. E-04 SHOWS THE FINAL CONDITIONS FOR THE TEMPORARY ROADWAY LIGHTING CONNECTIONS TO REMAIN AT THE CONCLUSION OF THIS CONTRACT.
 - INSTALL A TEMPORARY LIGHTING UNIT IN GRADE 11 FEET FROM THE EDGE OF PAVEMENT.

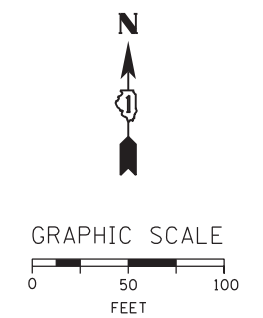

E-03



DI60W25-sht-Light-03
 USER NAME = myersc
 PLOT SCALE = 50.0000' / in.
 PLOT DATE = 6/14/2013

DESIGNED - WDS	REVISED -
DRAWN - CAM	REVISED -
CHECKED - JPC	REVISED -
DATE - 6/17/2013	REVISED -

**STATE OF ILLINOIS
 DEPARTMENT OF TRANSPORTATION**

I-290 TEMPORARY POWER PLAN

SCALE: SHEET 3 OF 11 SHEETS STA. TO STA.

F.A.I. RTE.	SECTION	COUNTY	TOTAL SHEETS	SHEET NO.
90/94/290	2013-007R	COOK	317	124
CONTRACT NO. 60W25				
ILLINOIS FED. AID PROJECT				