



REF-EDR02
REF-PDR02

CONTRACT NO. 60A91

F.A.P. RTE.	SECTION	COUNTY	TOTAL SHEETS	SHEET NO.
334	III RS-5 & 116 B-1	McHENRY	96	33
STA.		TO STA.		
FED. ROAD DIST. NO.	ILLINOIS	FED. AID PROJECT		

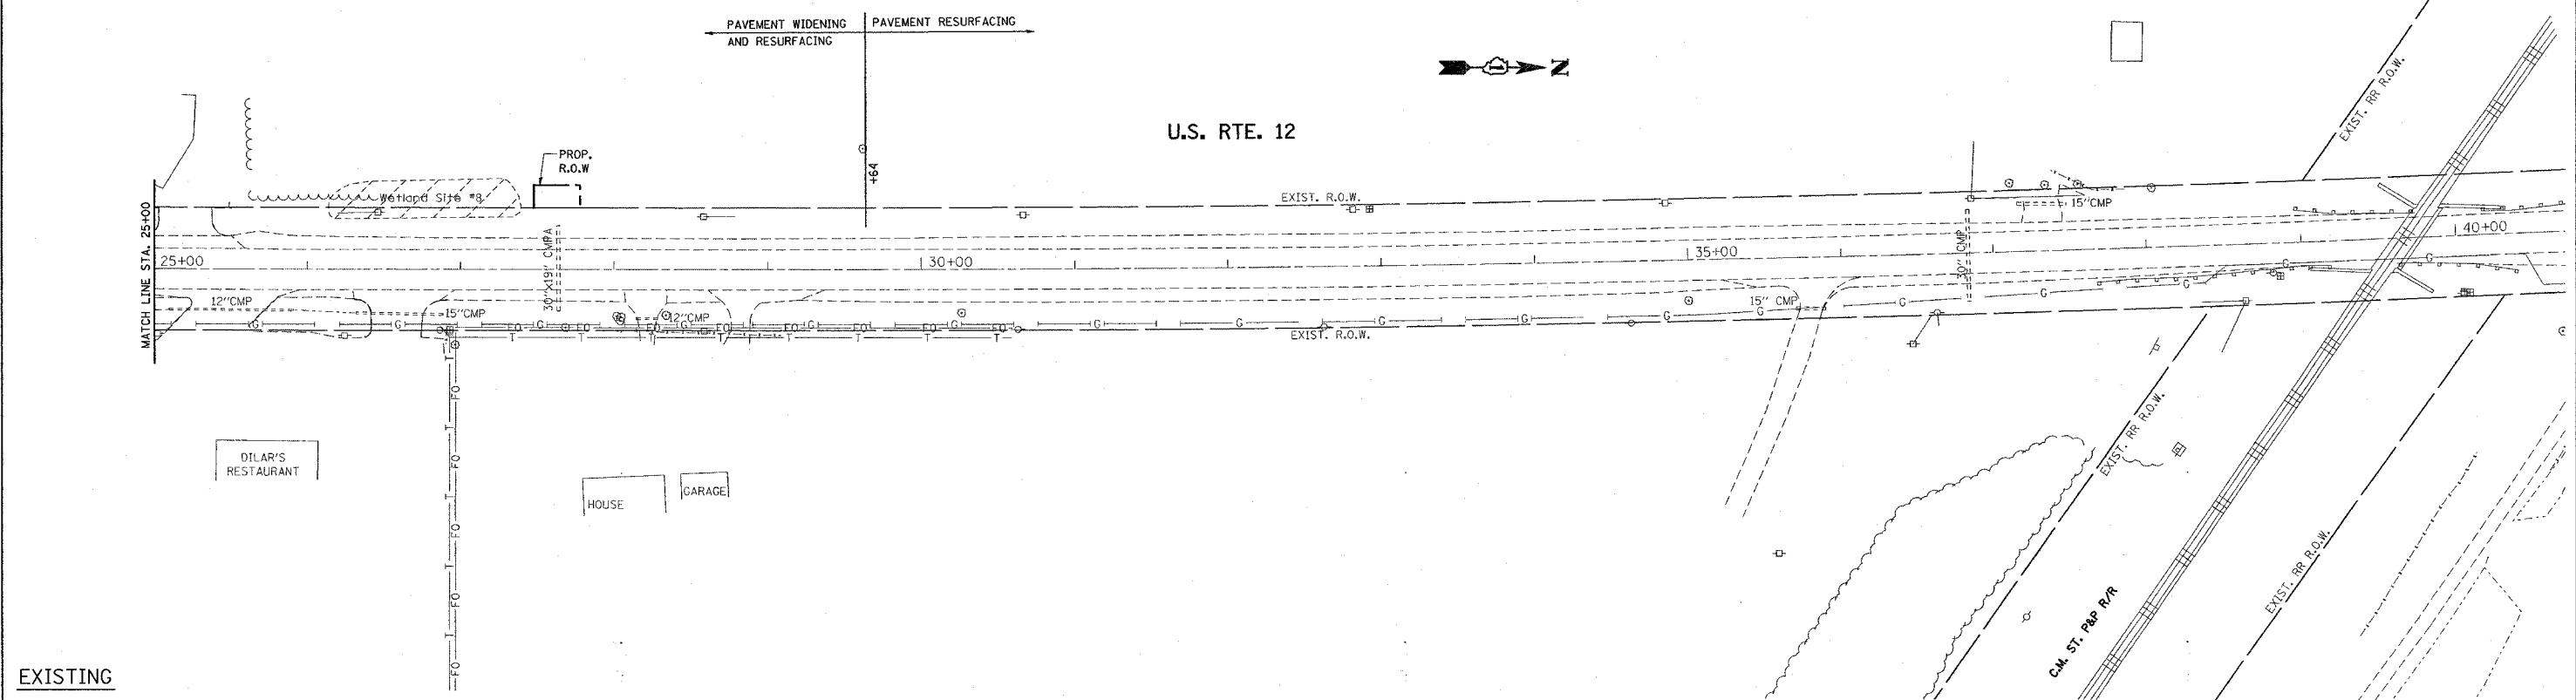

EXISTING

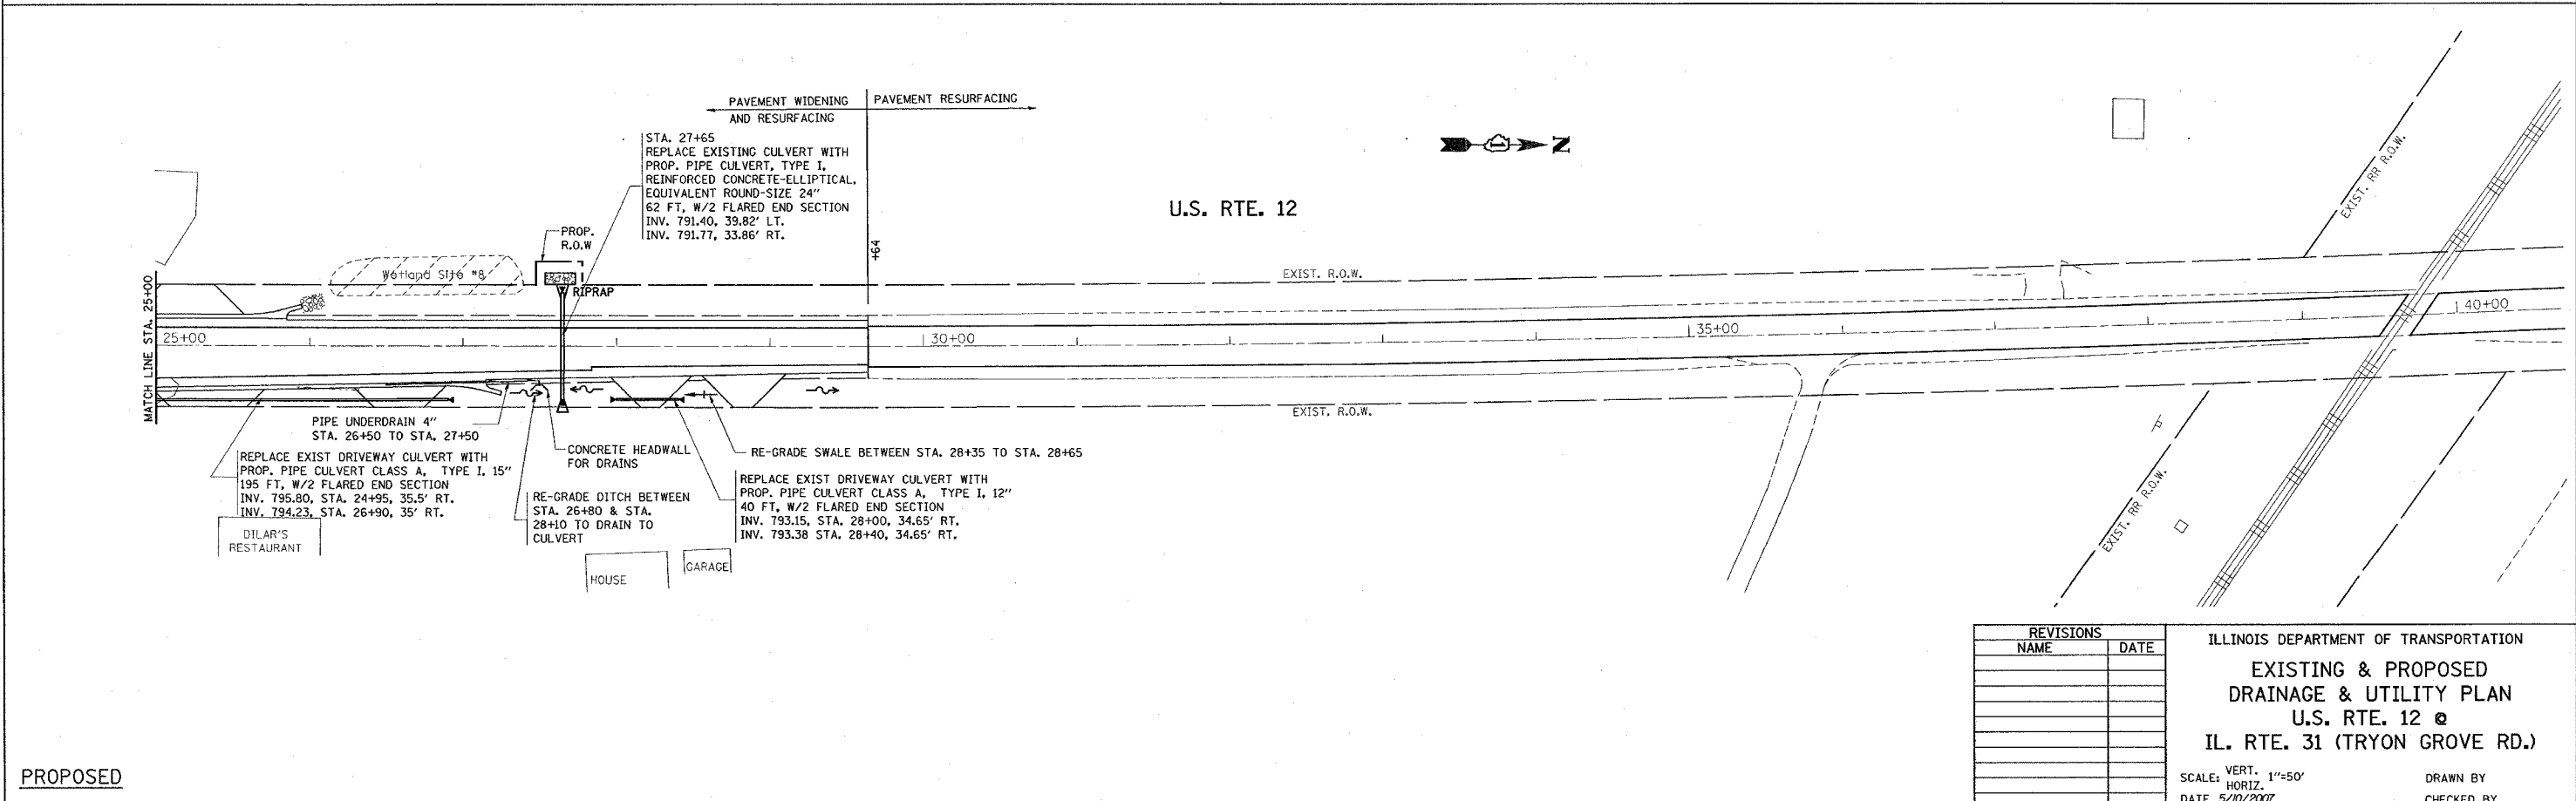

PROPOSED

PLOT DATE = 5/10/2007
FILE NAME = c:\projects\114899\ah.drain2.dgn
PLOT SCALE = 5/8"=1'-0"
USER NAME = baward

REVISIONS	
NAME	DATE

ILLINOIS DEPARTMENT OF TRANSPORTATION
**EXISTING & PROPOSED
DRAINAGE & UTILITY PLAN
U.S. RTE. 12 @
IL. RTE. 31 (TRYON GROVE RD.)**

SCALE: VERT. 1"=50'
HORIZ. DATE 5/10/2007

DRAWN BY
CHECKED BY