


\*REF-draft05-1  
\*REF-draft06-1

CONTRACT NO. 62719

F.A.P. RTE.	SECTION	COUNTY	TOTAL SHEETS	SHEET NO.
344	3034N-1	COOK	71	16
STA.		TO STA.		
FED. ROAD DIST. NO.		ILLINOIS FED. AID PROJECT		

**EXISTING**


- [R] STRUCTURE TO BE REMOVED
- [AB] STORM SEWER TO BE PLUGGED AND ABANDONED
- [ADJ] STRUCTURE TO BE ADJUSTED
- [REL] RELOCATE STORM SEWER

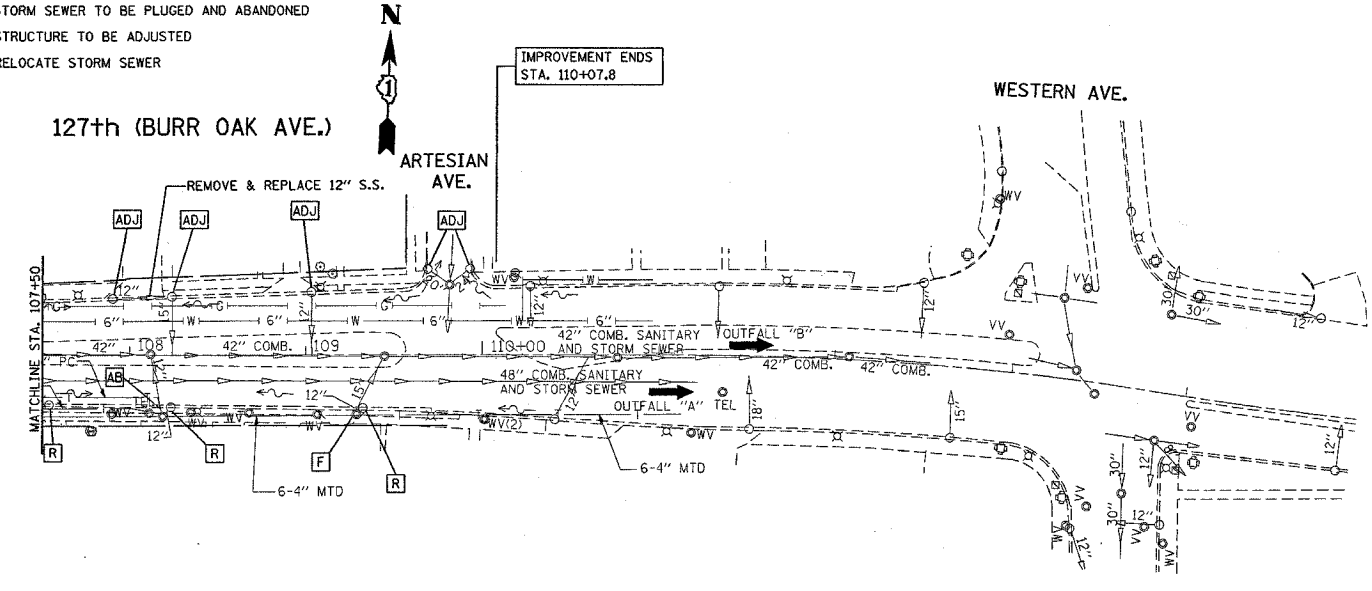

EXISTING

**PROPOSED**

- CATCH BASIN
- ⊙ MANHOLE
- STORM SEWER

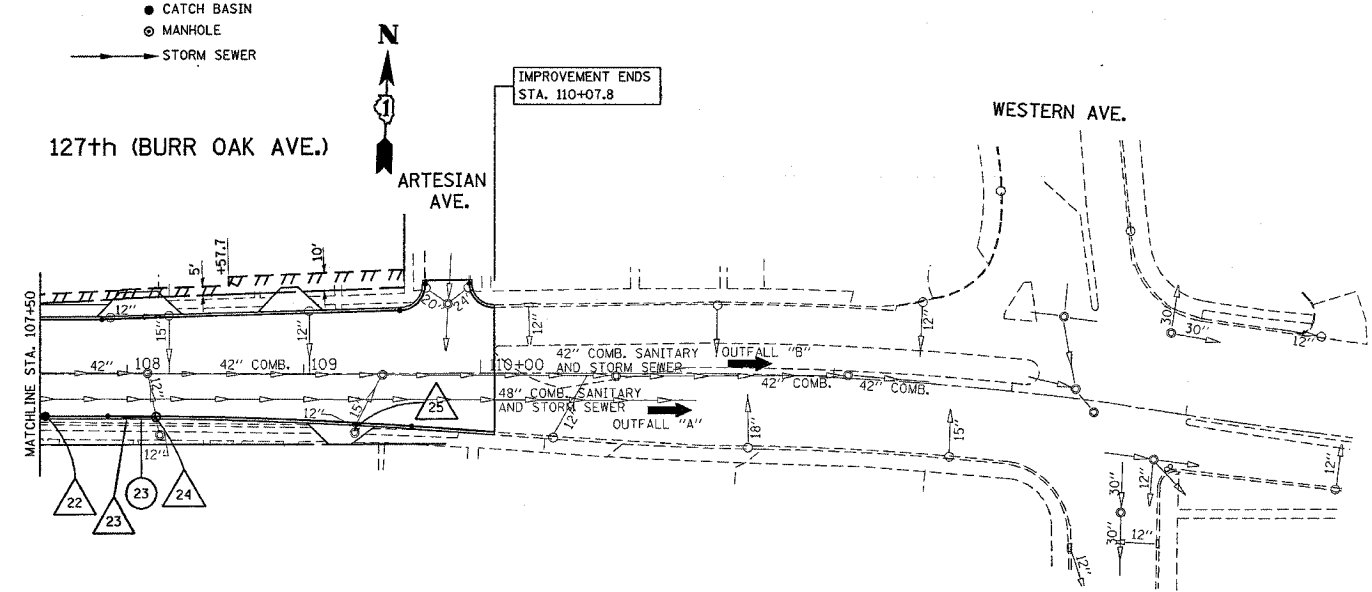

PROPOSED

PLOT DATE = 1/3/2007  
FILE NAME = c:\projects\108483\ah.drain.dgn  
PLOT SCALE = 1/8" = 1' IN.  
USER NAME = drvhoksgn

REVISIONS	
NAME	DATE

ILLINOIS DEPARTMENT OF TRANSPORTATION

**127TH STREET  
EXISTING & PROPOSED  
DRAINAGE AND UTILITY PLANS**

SCALE: VERT. 1"=50'  
HORIZ. 1"=50'  
DATE 1/3/2007

DRAWN BY  
CHECKED BY