
 
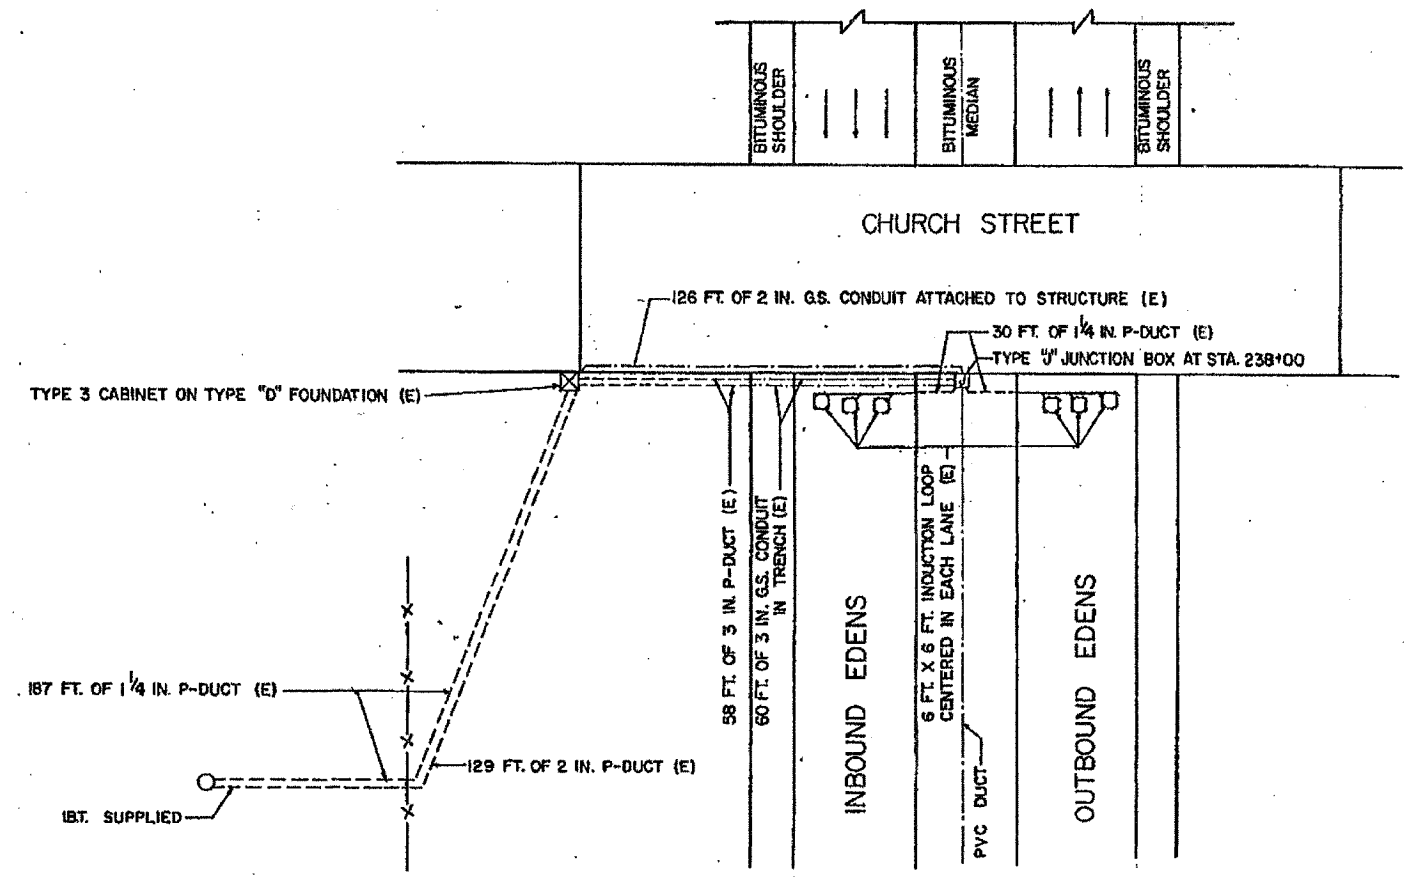


F. S. SECTION	COUNTY	TOTAL SHEETS	SHEET NO.
		135	75
STA.	TO STA.	FED. ROAD DIST. NO. 7 ILLINOIS	
		FED. AID PROJECT	


62747



PLAN

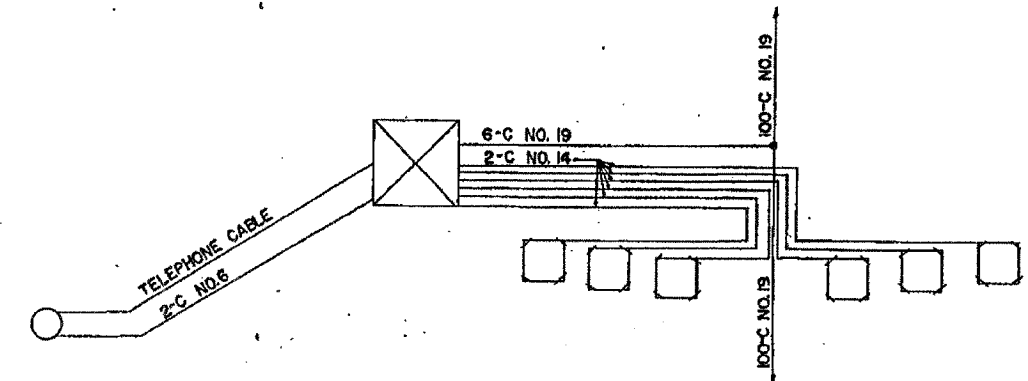

WIRING DIAGRAM

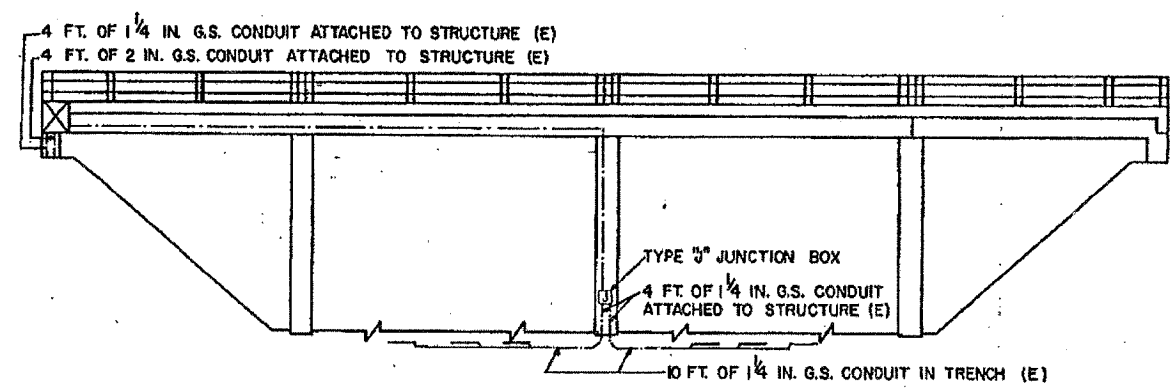

SOUTH ELEVATION

LEGEND

- INDUCTION LOOP
- ⊠ CABINET
- ⊞ JUNCTION BOX
- ⊙ PULL POINT
- SERVICE INSTALLATION
- ⊙ HEAVYDUTY HANDHOLE
- ⊙ HANDHOLE
- POLYETHYLENE DUCT
- CONDUIT
- - - FENCE
- - - GUARDRAIL
- △ FLASHER
- ⊙ METERING SIGNAL LIGHT
- (E) EXISTING FACILITIES

FOR INFORMATION ONLY

REVISIONS	
NAME	DATE

ILLINOIS DEPARTMENT OF TRANSPORTATION

**CHURCH STREET
INSTALLATION**

SCALE: VERT. _____
HORIZ. _____

DATE _____ DRAWN BY _____
CHECKED BY _____