




62747

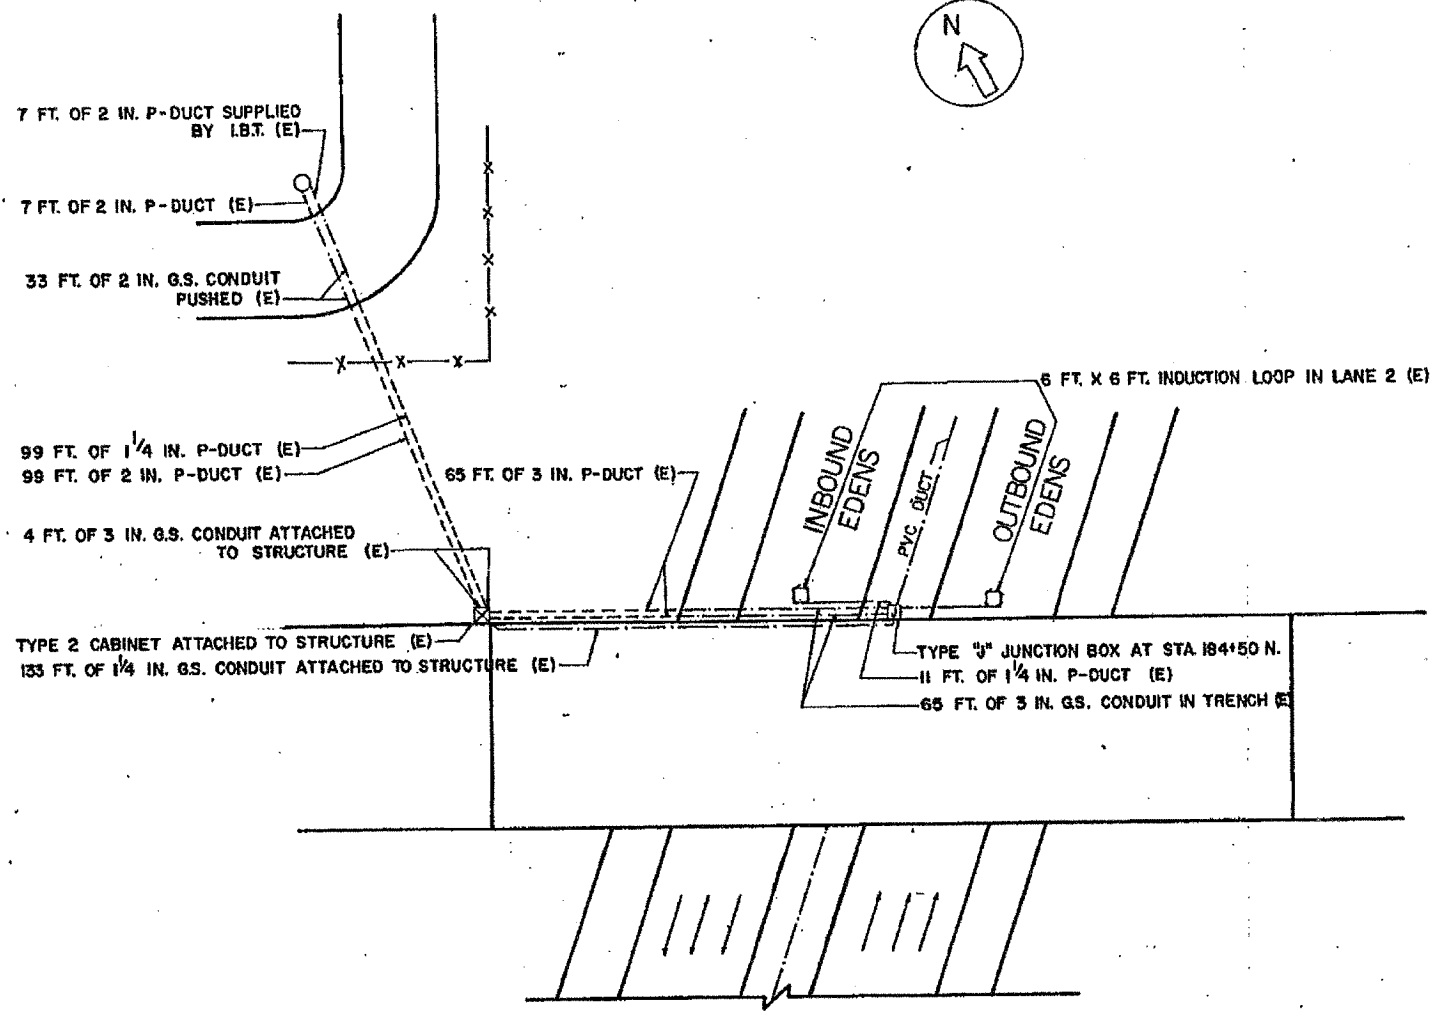

PLAN

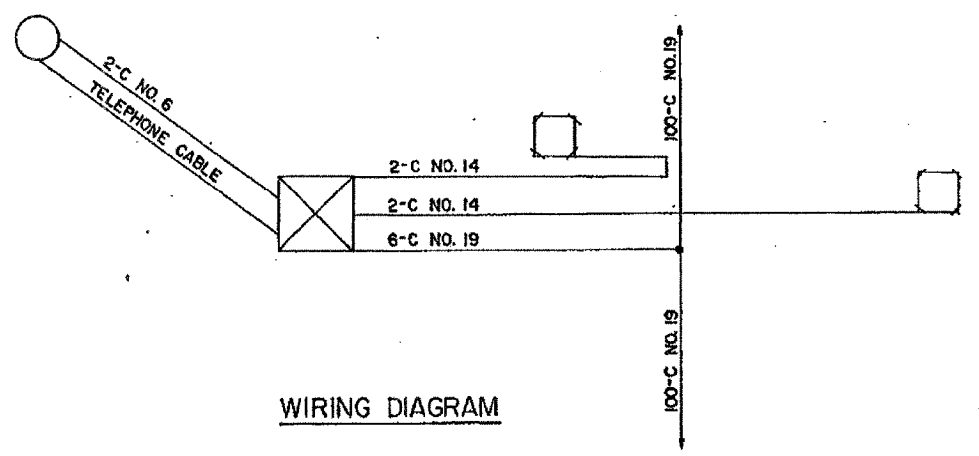

WIRING DIAGRAM

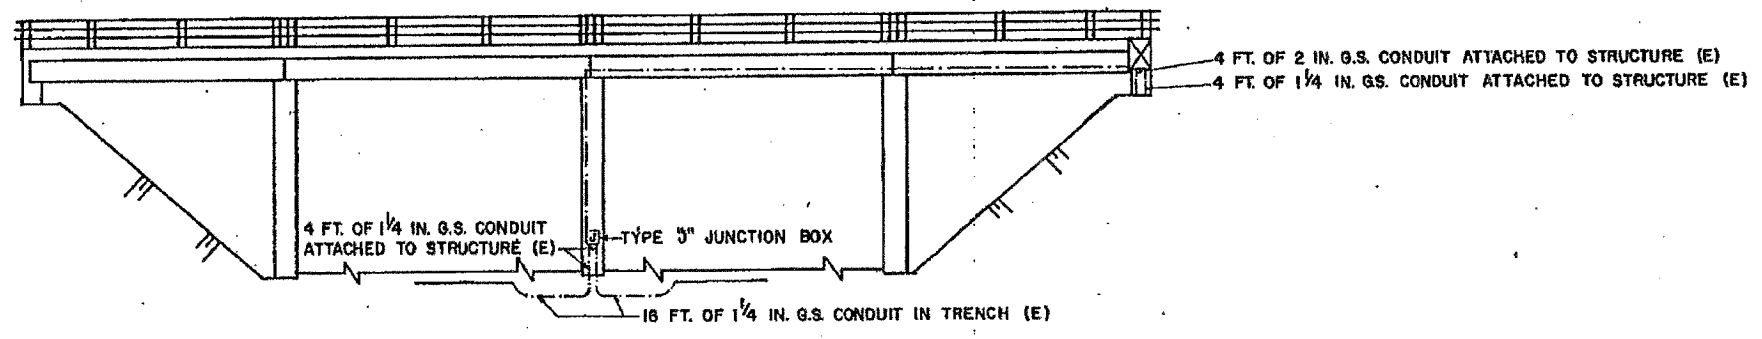

NORTH ELEVATION

LEGEND

- INDUCTION LOOP
- ▣ CABINET
- ⊠ JUNCTION BOX
- ⊙ PULL POINT
- SERVICE INSTALLATION
- ⊙ HANDHOLE
- ⊙ HEAVY DUTY HANDHOLE
- POLYETHYLENE DUCT
- CONDUIT
- x-x- FENCE
- - - GUARDRAIL
- △ FLASHER
- METERING SIGNAL LIGHT
- (E) EXISTING FACILITIES

FOR INFORMATION ONLY

REVISIONS	
NAME	DATE

ILLINOIS DEPARTMENT OF TRANSPORTATION  
**LINCOLN AVENUE  
 INSTALLATION**  
 SCALE: VERT. \_\_\_\_\_  
 HORIZ. \_\_\_\_\_  
 DATE \_\_\_\_\_ DRAWN BY \_\_\_\_\_  
 CHECKED BY \_\_\_\_\_