




62747

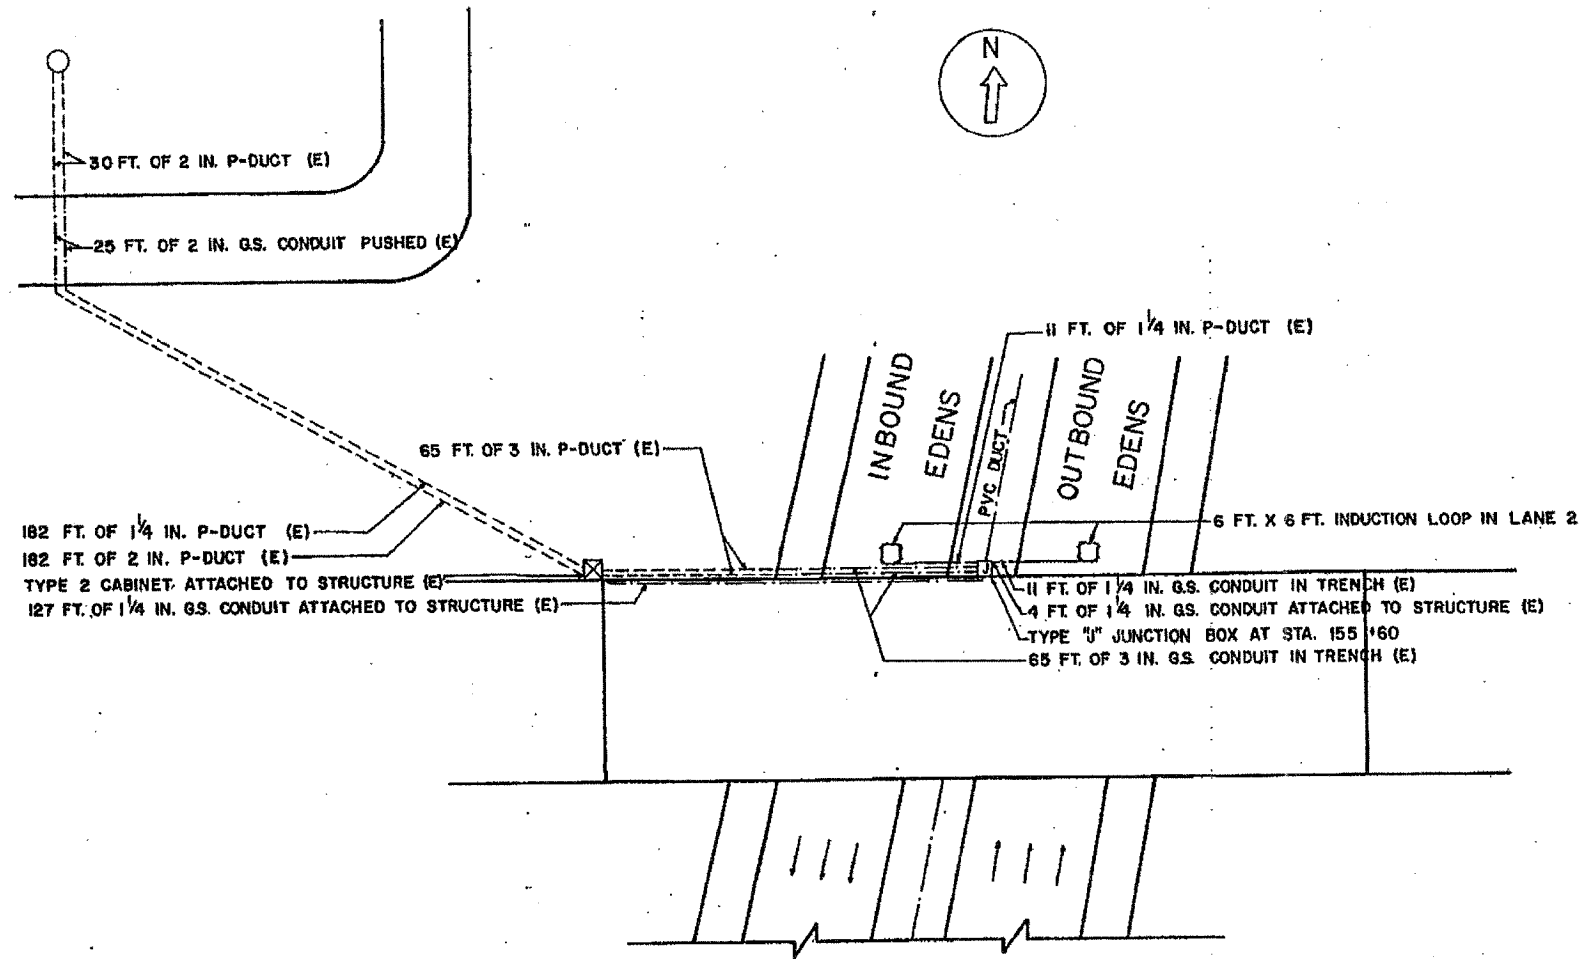

PLAN

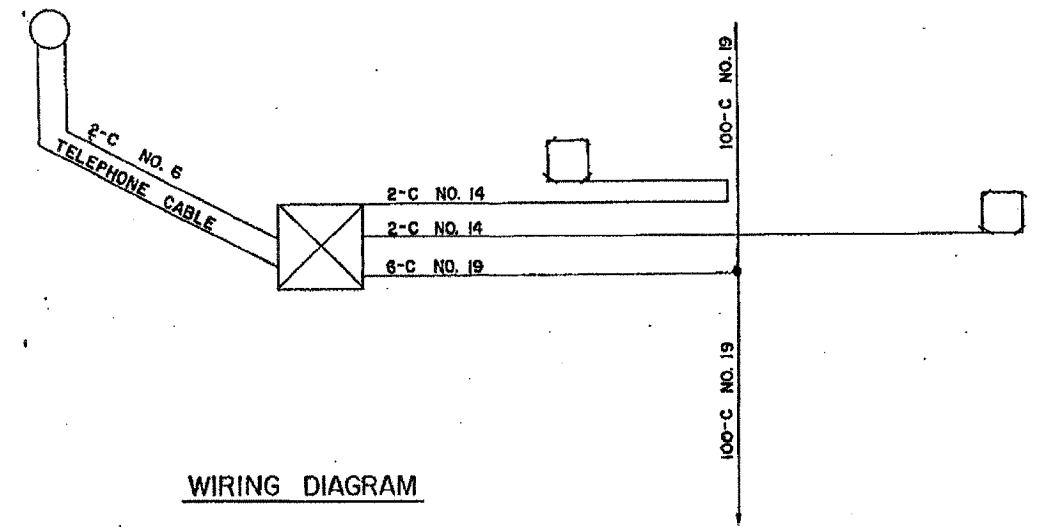

WIRING DIAGRAM

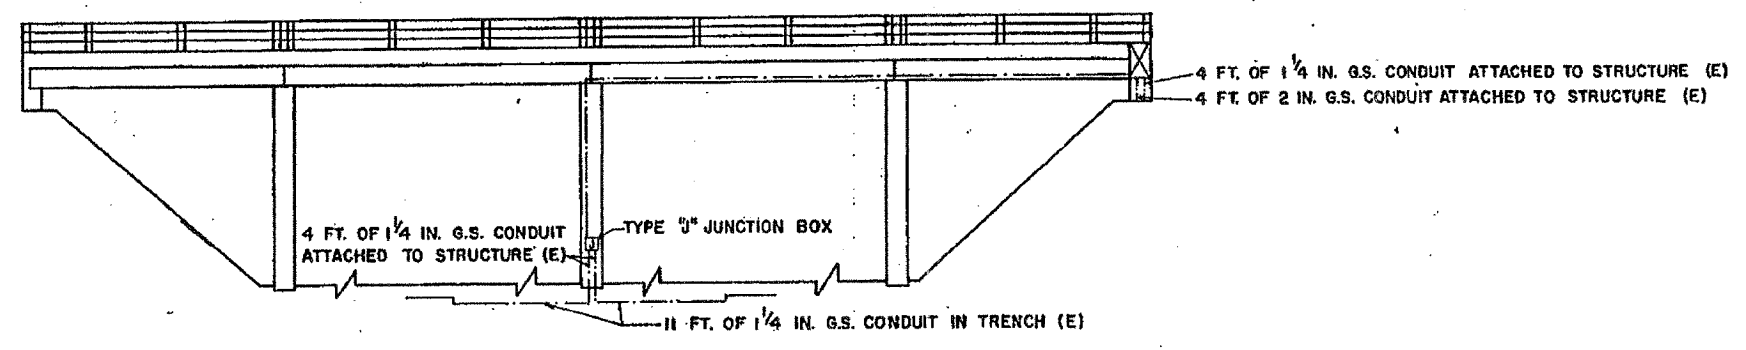

NORTH ELEVATION

LEGEND

- INDUCTION LOOP
- ⊠ CABINET
- ⊞ JUNCTION BOX
- ⊙ PULL POINT
- SERVICE INSTALLATION
- ⊙ HANDHOLE
- ⊙ HEAVYDUTY HANDHOLE
- POLYETHYLENE DUCT
- CONDUIT
- x-x- FENCE
- x-x- GUARDRAIL
- △ FLASHER
- ⊙ METERING SIGNAL LIGHT
- (E) EXISTING FACILITIES

FOR INFORMATION ONLY

REVISIONS	
NAME	DATE

ILLINOIS DEPARTMENT OF TRANSPORTATION

**OAKTON STREET
INSTALLATION**

SCALE: VERT. _____
HORIZ. _____

DATE _____ DRAWN BY _____
CHECKED BY _____