



62747

LEGEND


- INDUCTION LOOP
- ⊠ CABINET
- ⊡ JUNCTION BOX
- ⊙ PULL POINT
- SERVICE INSTALLATION
- ⊕ HANDHOLE
- ⊕ HEAVY DUTY HANDHOLE
- POLYETHYLENE DUCT
- CONDUIT
- FENCE
- GUARDRAIL
- △ FLASHER
- ⊙ METERING SIGNAL LIGHT
- (E) EXISTING FACILITIES
- (R) REMOVE FACILITIES



PLAN

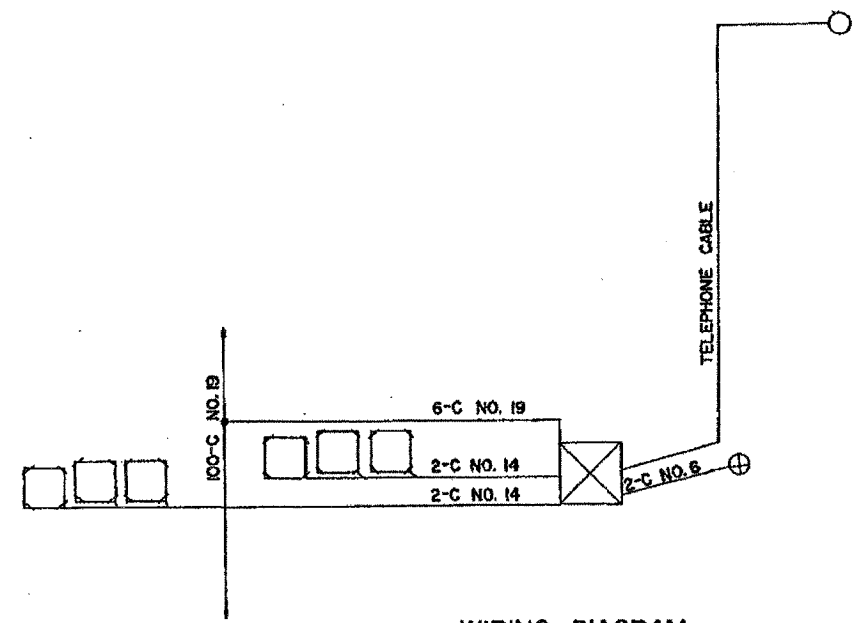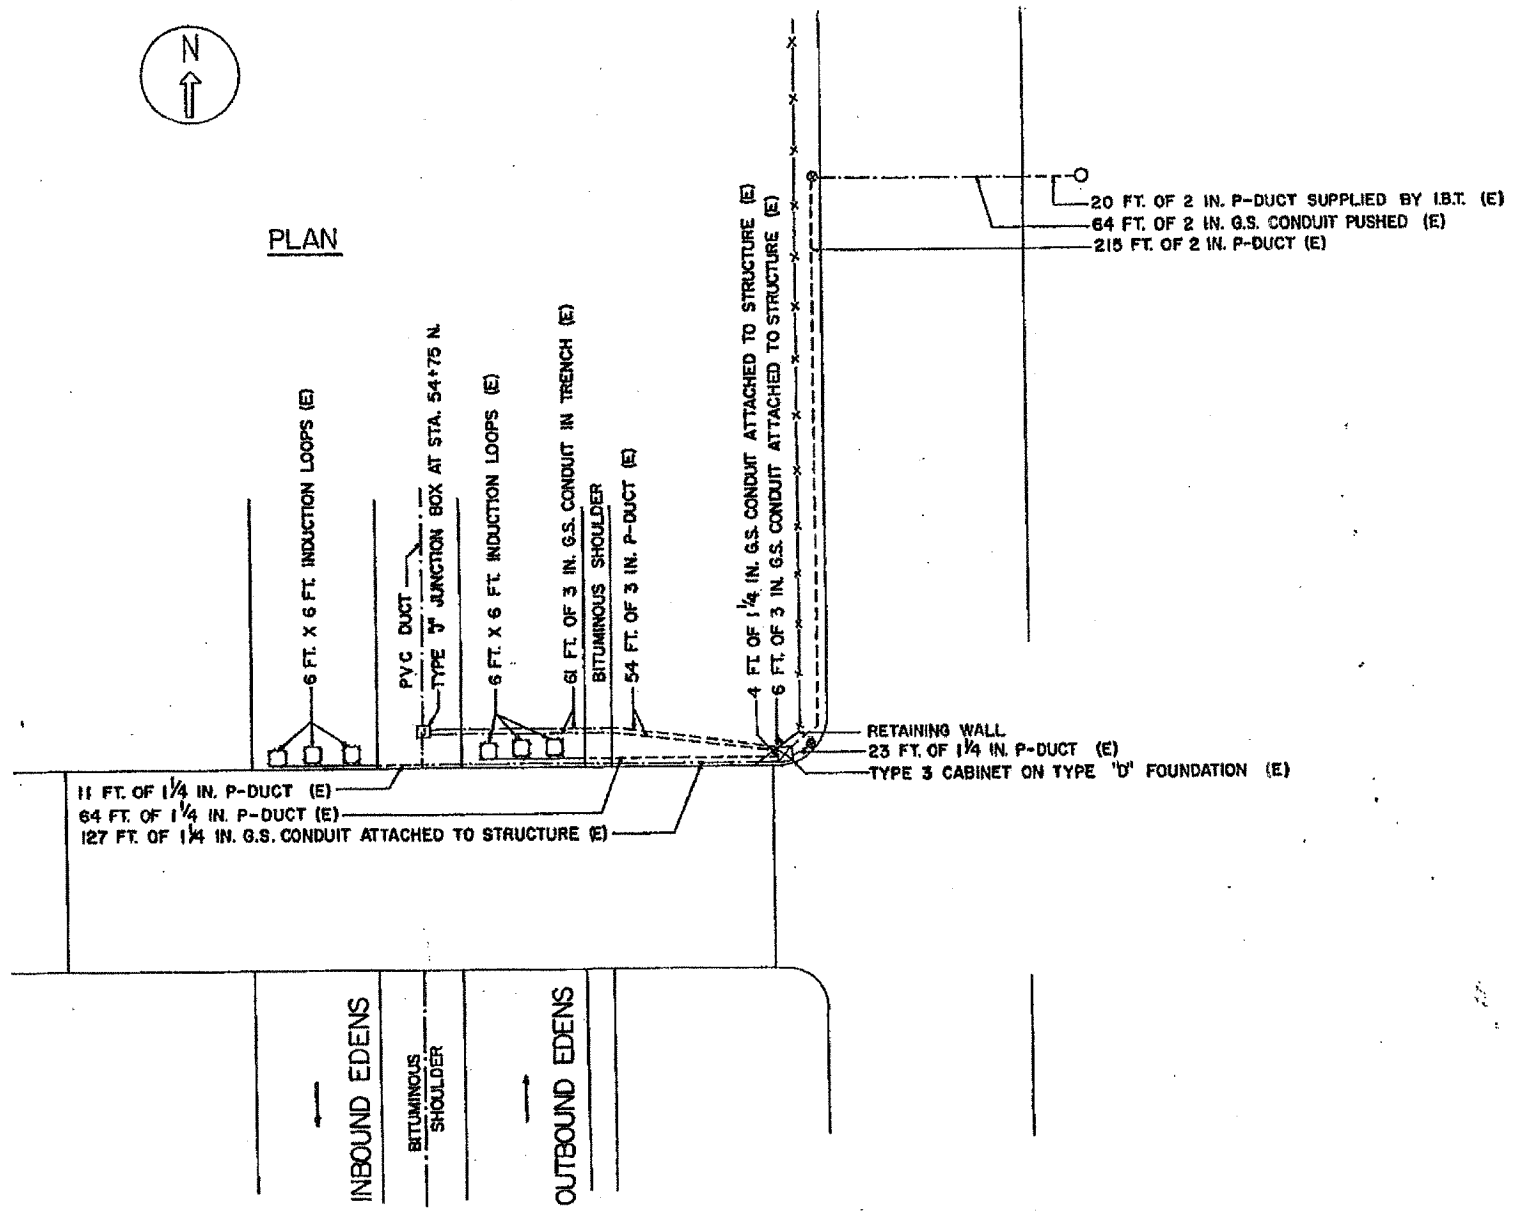

WIRING DIAGRAM

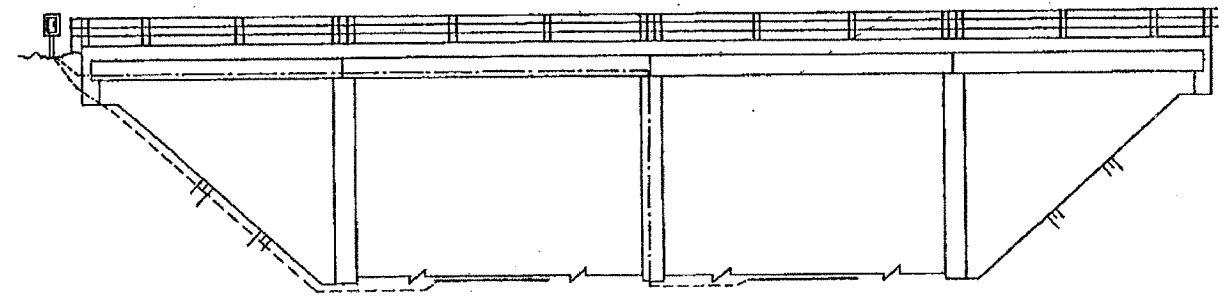

NORTH ELEVATION

FOR INFORMATION ONLY

ILLINOIS DEPARTMENT OF TRANSPORTATION

**PRATT AVENUE
INSTALLATION**

REVISIONS	
NAME	DATE

SCALE: VERT.
HORIZ.
DATE

DRAWN BY
CHECKED BY