


|                                |        |                  |           |
|--------------------------------|--------|------------------|-----------|
| SECTION                        | COUNTY | TOTAL SHEETS     | SHEET NO. |
|                                |        | 135              | 87        |
| STA. TO STA.                   |        | FED. AID PROJECT |           |
| FED. ROAD DIST. NO. 7 ILLINOIS |        | 62747            |           |

62747

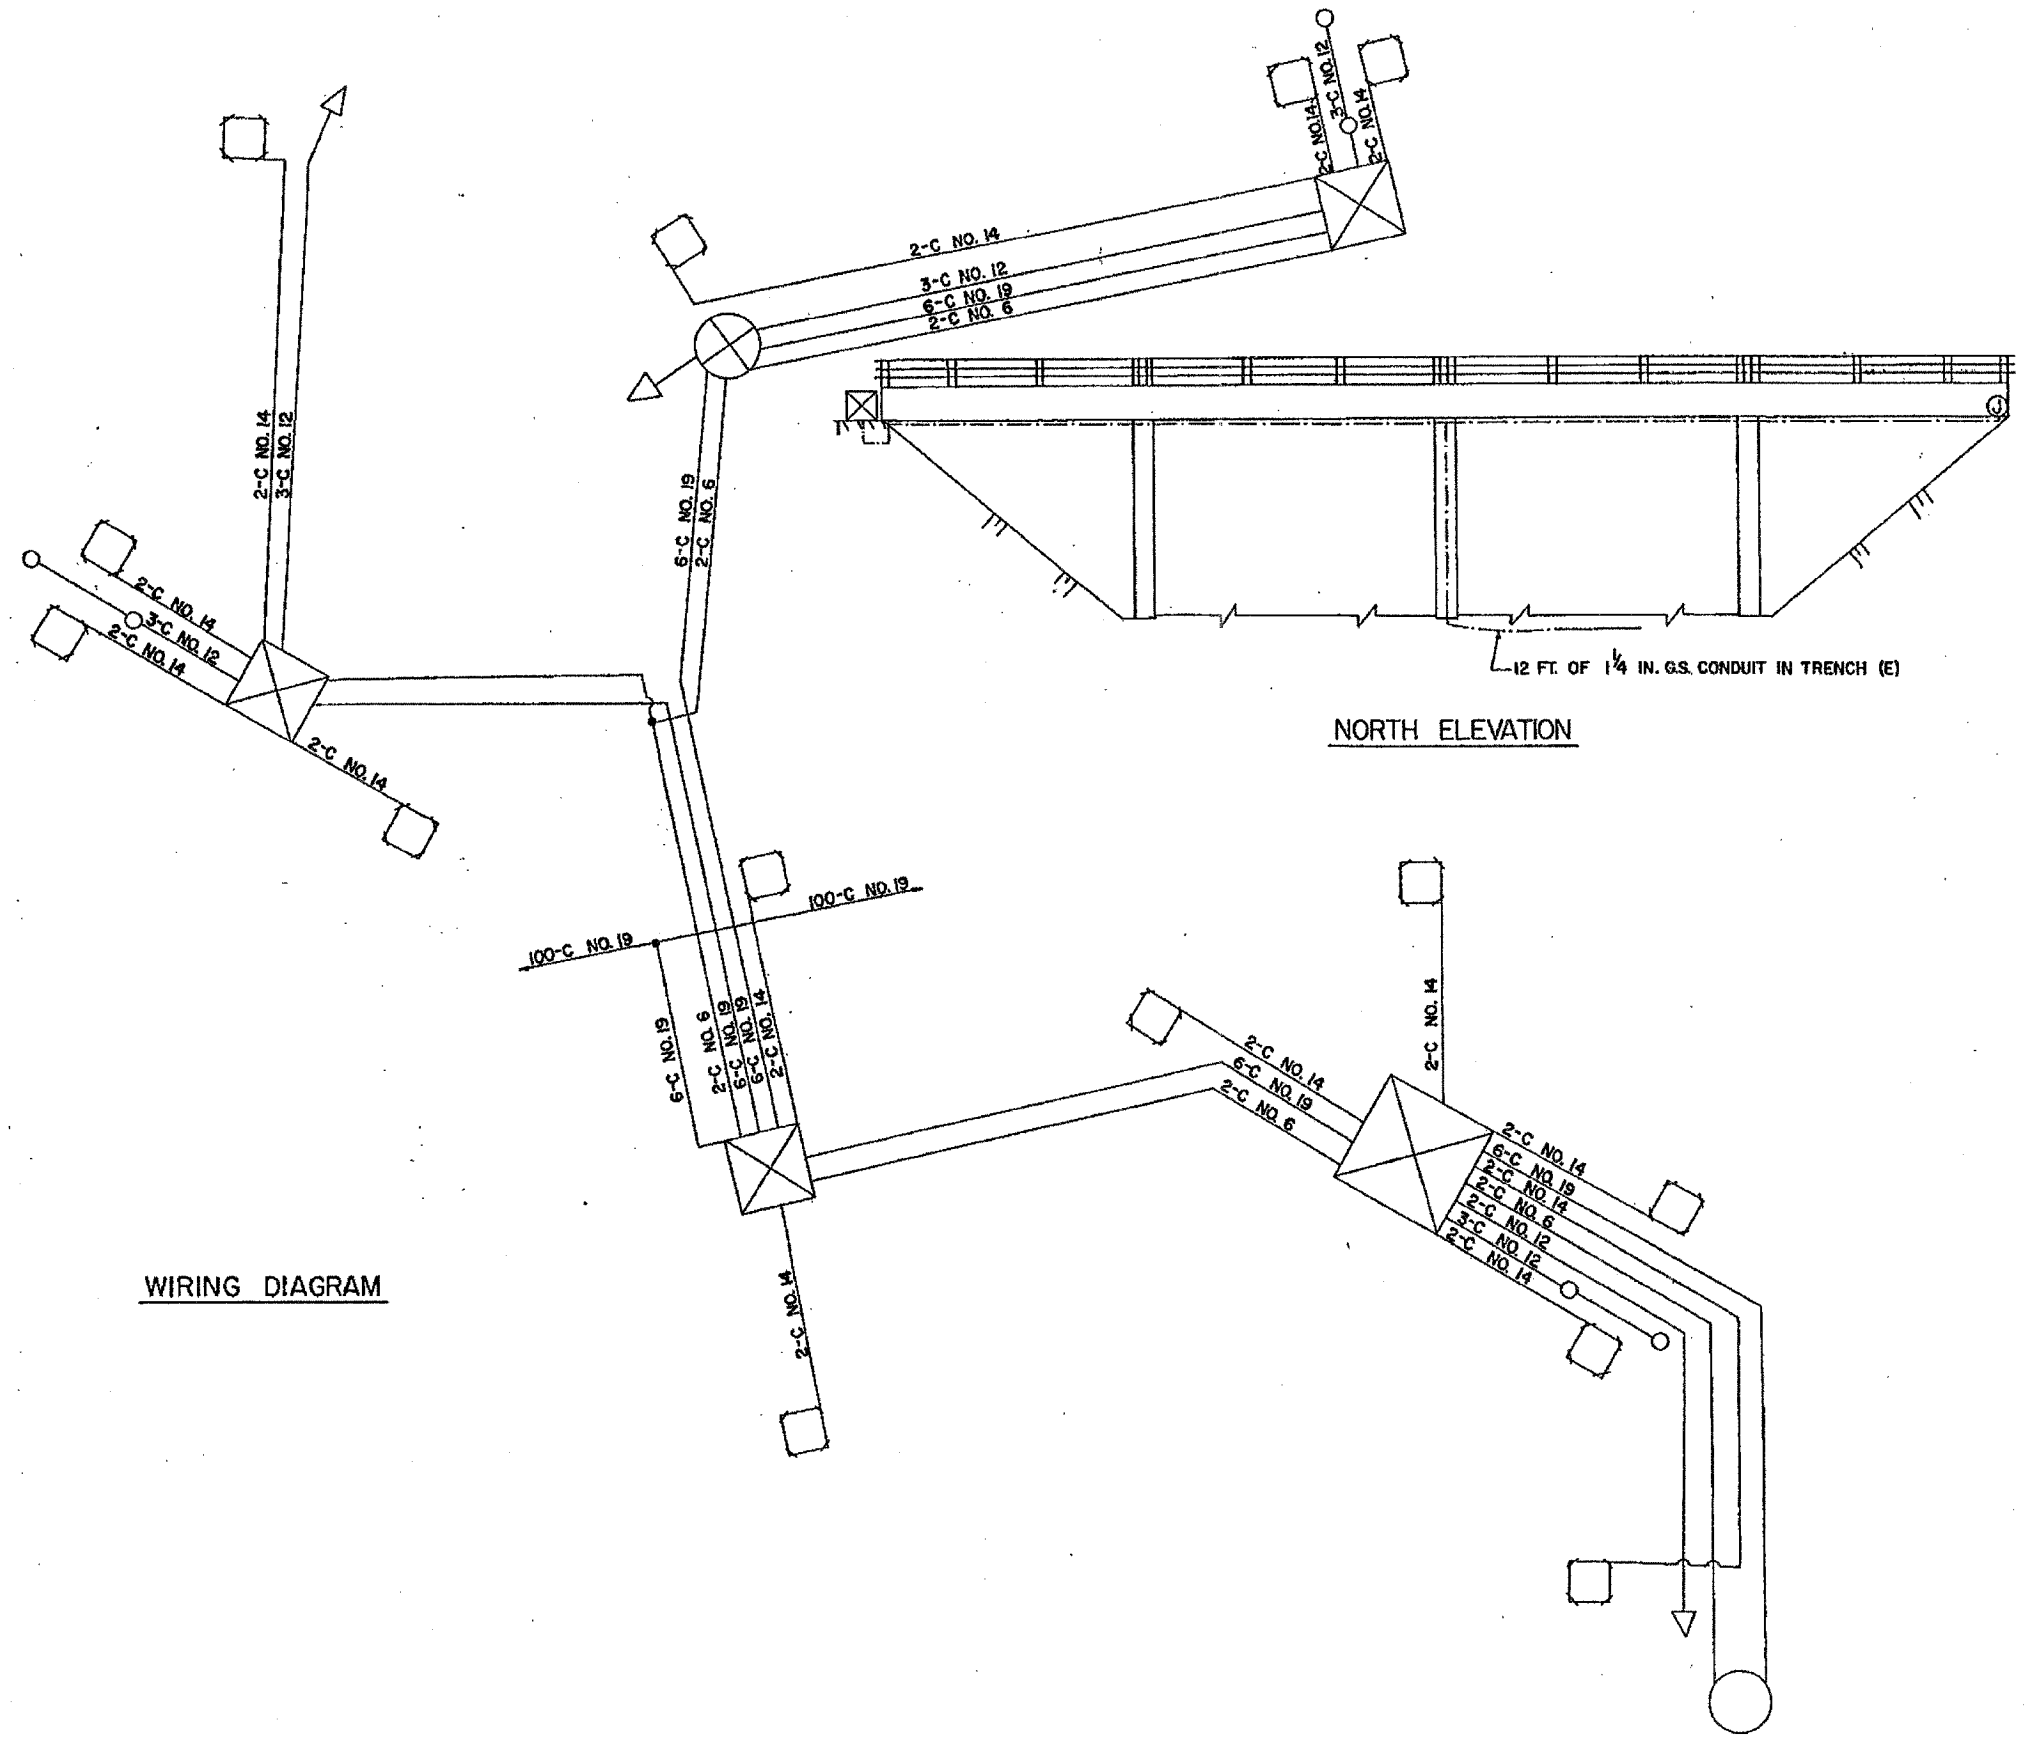

WIRING DIAGRAM

NORTH ELEVATION

12 FT. OF 1/4 IN. G.S. CONDUIT IN TRENCH (E)

LEGEND

- INDUCTION LOOP
- ⊠ CABINET
- ⊞ JUNCTION BOX
- ⊙ PULL POINT
- SERVICE INSTALLATION
- ⊗ HANDHOLE
- ⊕ HEAVY DUTY HANDHOLE
- POLYETHYLENE DUCT
- CONDUIT
- FENCE
- GUARDRAIL
- △ FLASHER
- ⊙ METERING SIGNAL LIGHT
- (E) EXISTING FACILITIES
- (R) REMOVE FACILITIES

FOR INFORMATION ONLY

| REVISIONS |      |
|-----------|------|
| NAME      | DATE |
|           |      |
|           |      |
|           |      |
|           |      |
|           |      |

ILLINOIS DEPARTMENT OF TRANSPORTATION

PETERSON AVENUE  
METERING INSTALLATION

page 2 of 2

SCALE: VERT.      DRAWN BY  
 HORIZ.              CHECKED BY  
 DATE