
 
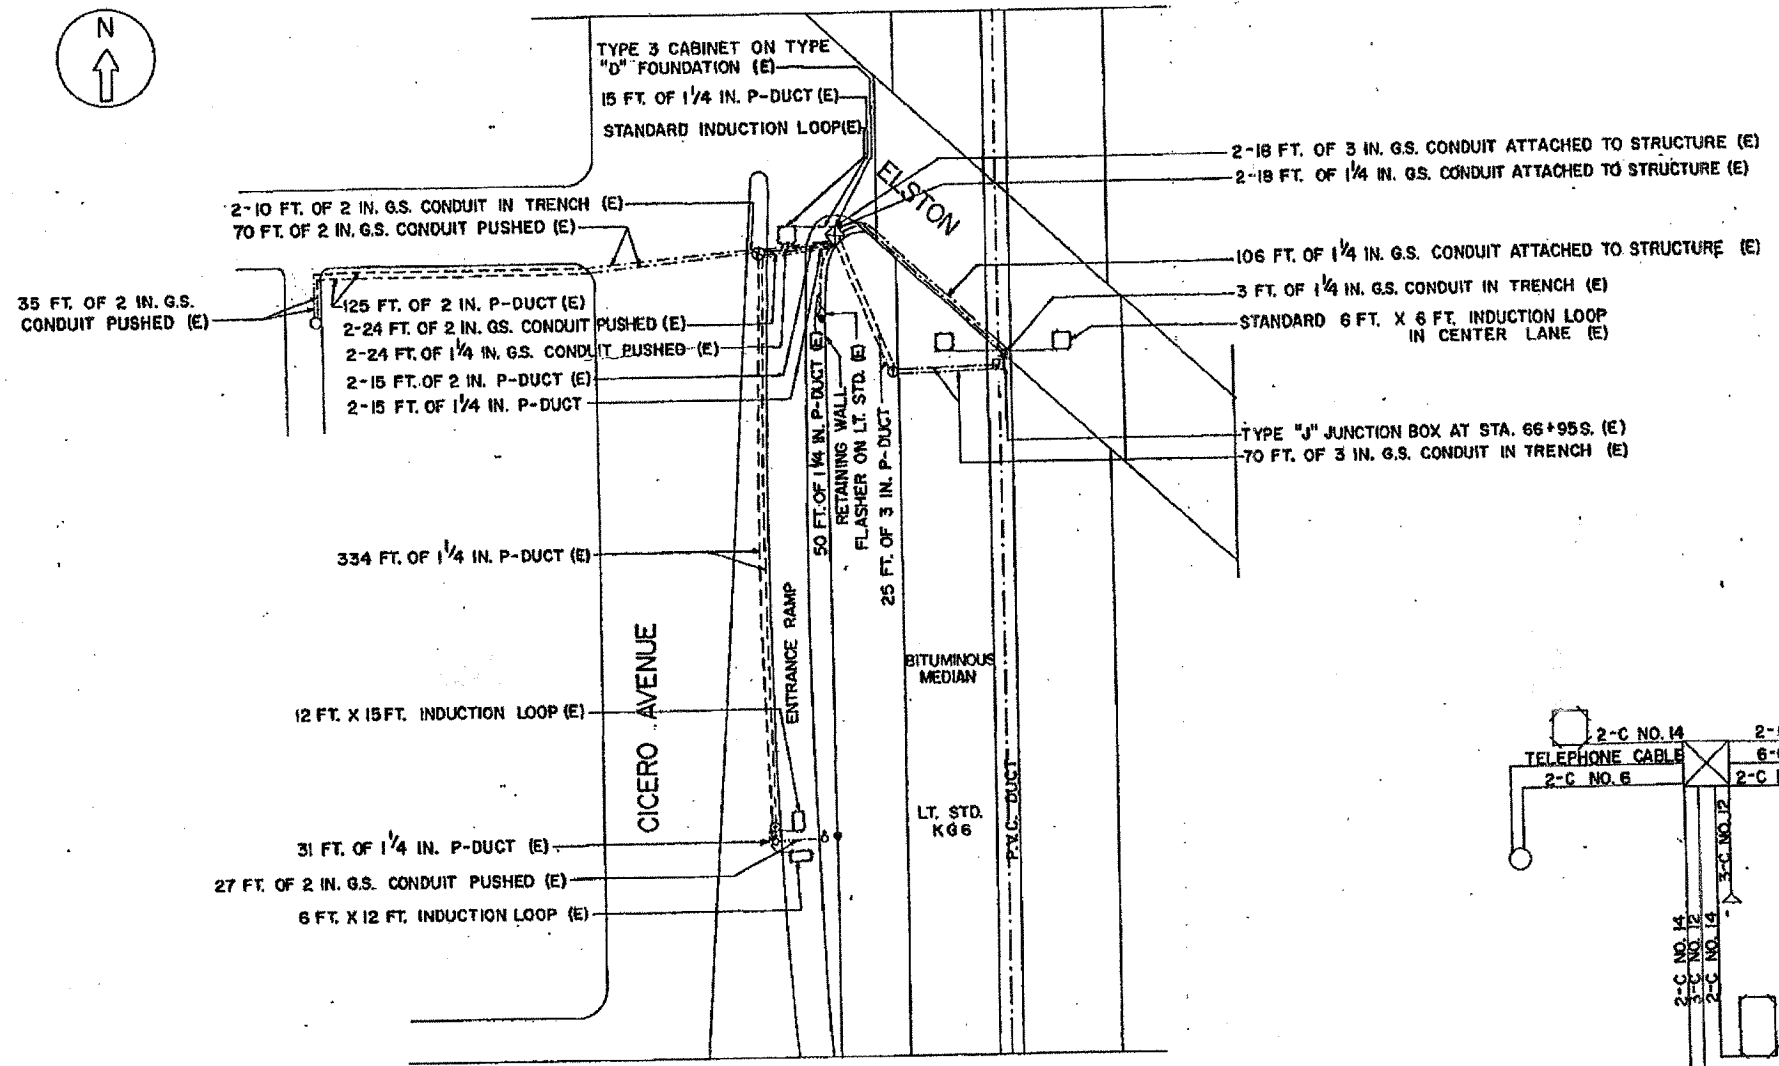



62747



PLAN

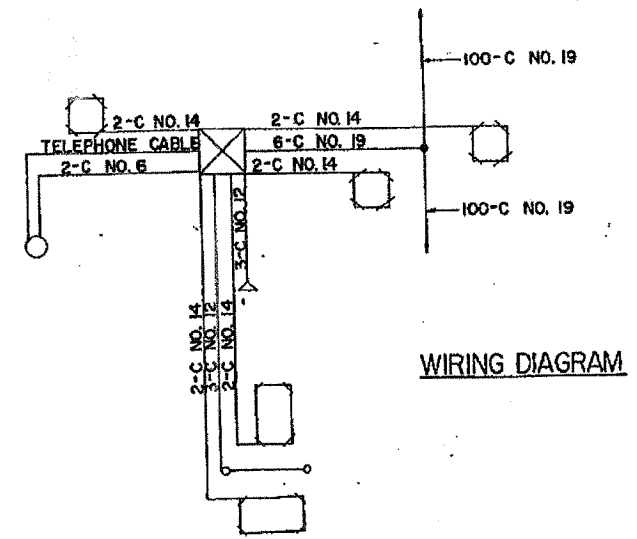

WIRING DIAGRAM

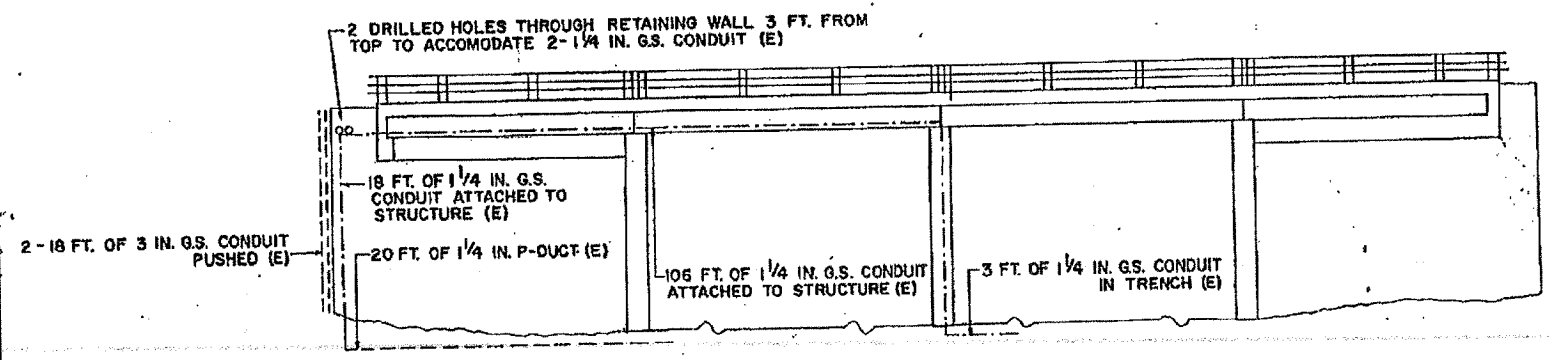

SOUTH ELEVATION

LEGEND

- ☒ CABINET
- LOOP
- SERVICE INSTALLATION
- DUCT
- CONDUIT
- ⊗ HANDHOLE
- (E) EXISTING FACILITIES
- △ FLASHER
- ⊙ SIGNAL

FOR INFORMATION ONLY

ILLINOIS DEPARTMENT OF TRANSPORTATION
**ELSTON AVENUE
 INSTALLATION**

REVISIONS	
NAME	DATE

SCALE: VERT. _____
 HORIZ. _____
 DATE _____ DRAWN BY _____
 CHECKED BY _____