
 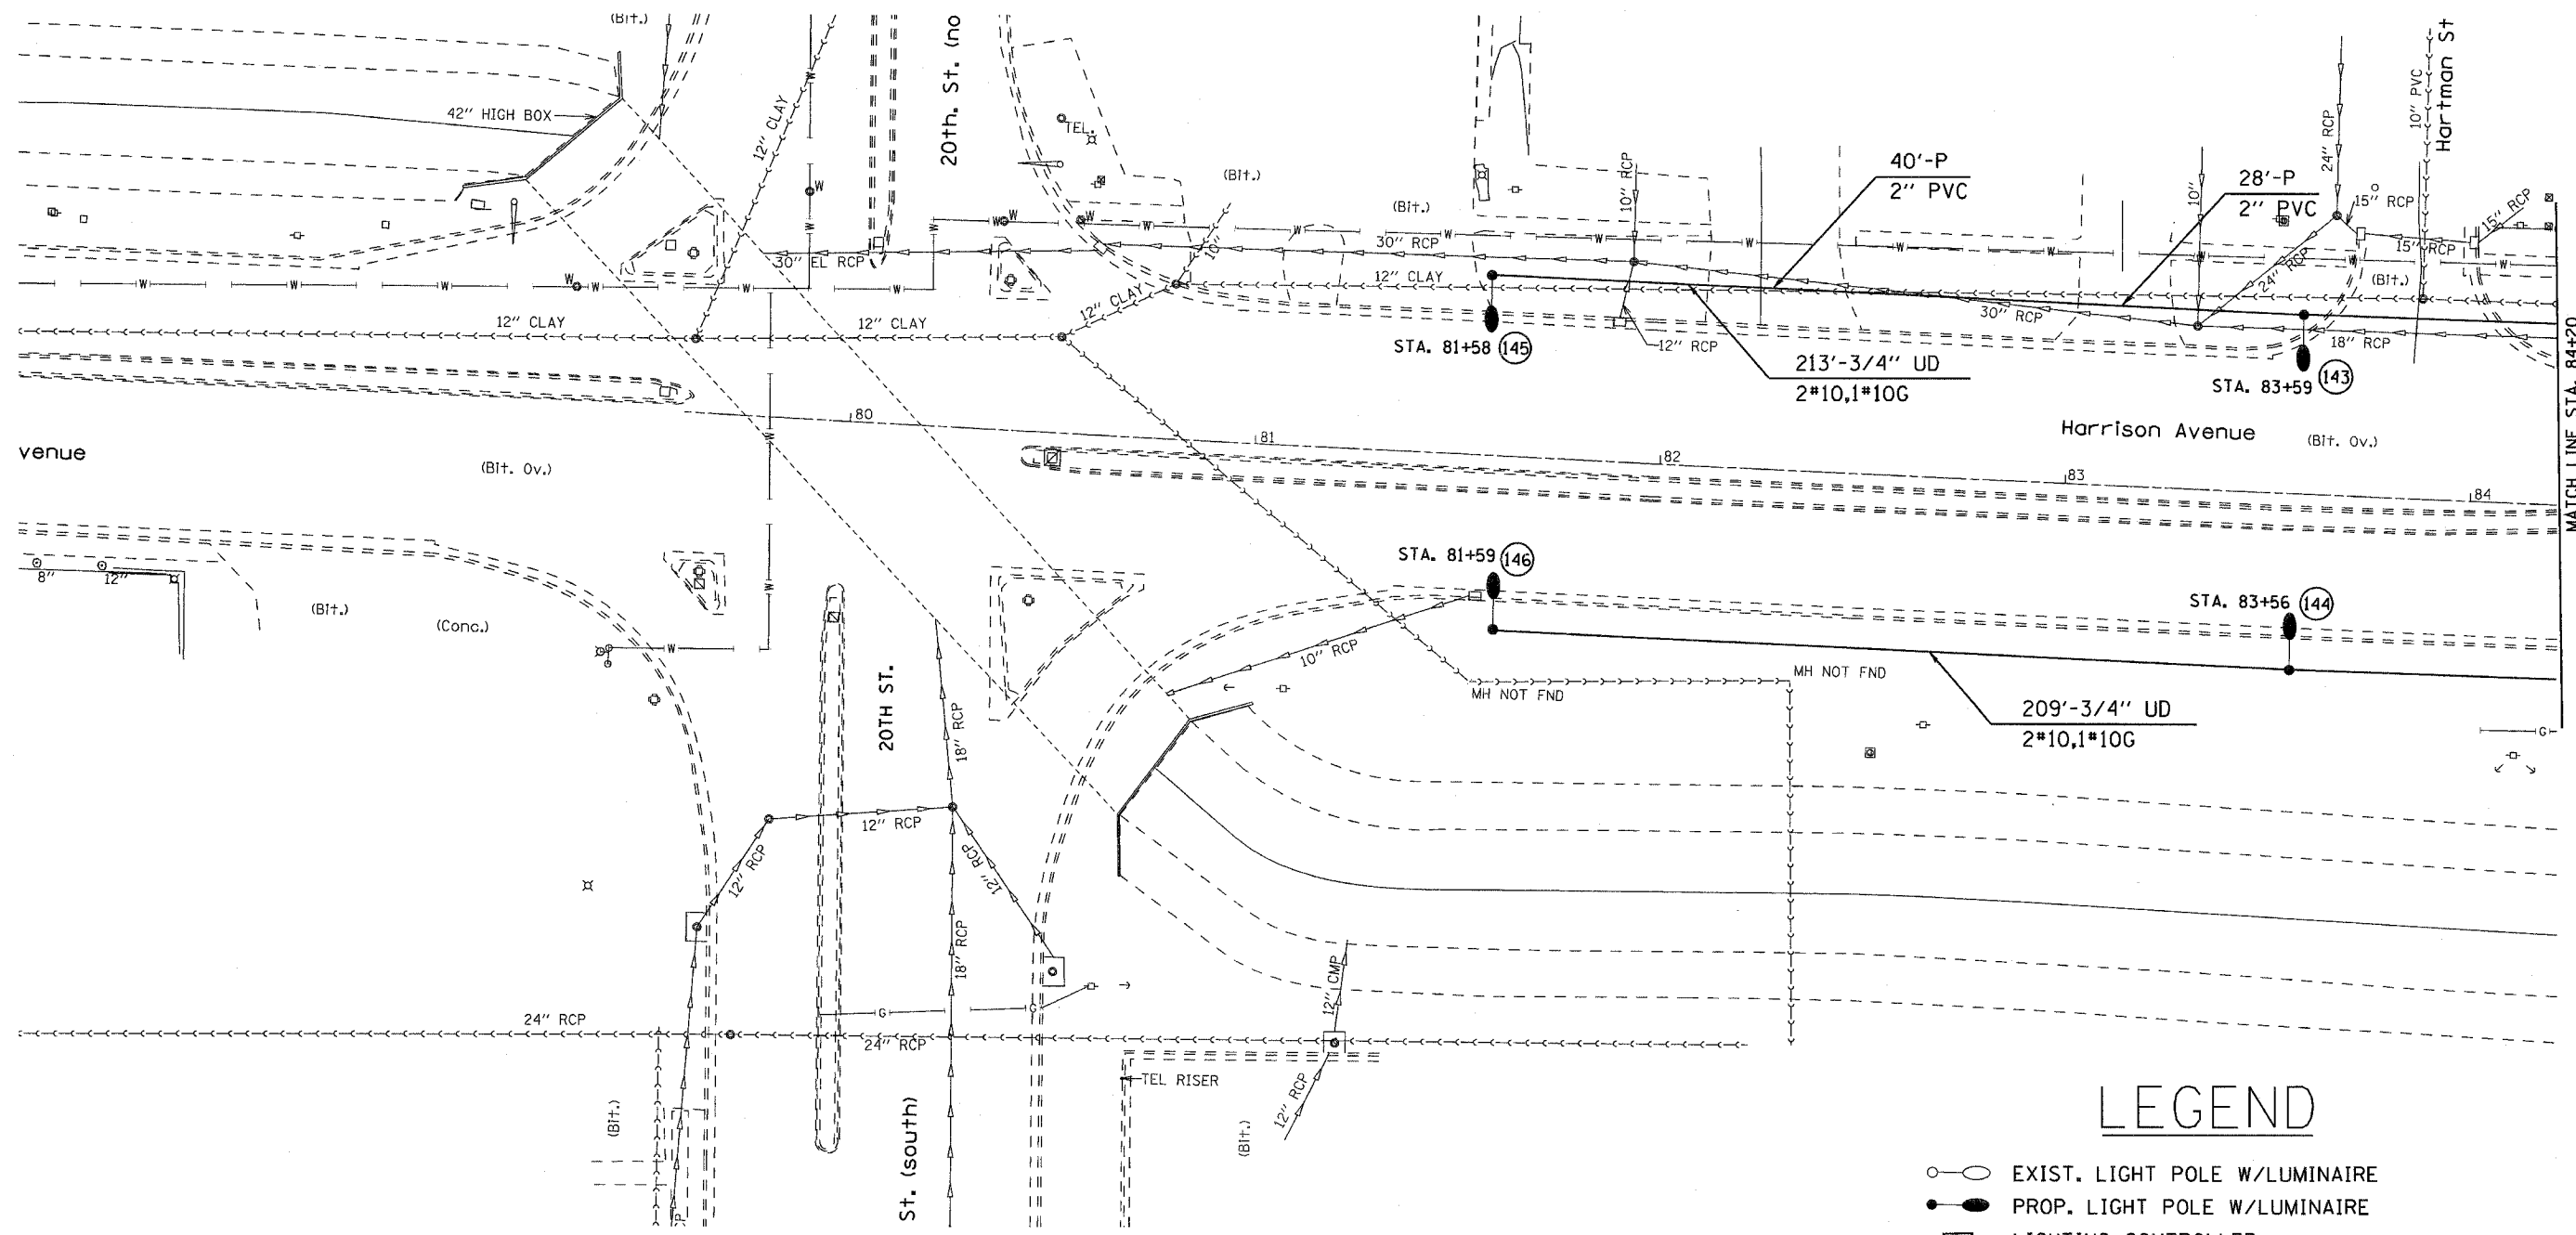



E.A. RTE.	SECTION	COUNTY	TOTAL SHEETS	SHEET NO.
525	06-00520-01-LT	WINNEBAGO	41	6
STA. 50+00		TO STA. 84+20		
FED. ROAD DIST. NO.		ILLINOIS FED. AID PROJECT		

LIGHTING PLANS

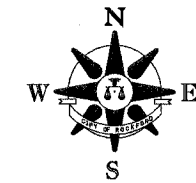

LEGEND

- EXIST. LIGHT POLE W/LUMINAIRE
- PROP. LIGHT POLE W/LUMINAIRE
- ◻ LIGHTING CONTROLLER
- ◻ HANDHOLE
- PROP. LIGHT POLE W/DUAL LUMINAIRE
- EXIST. CONDUIT BY OTHERS