
 
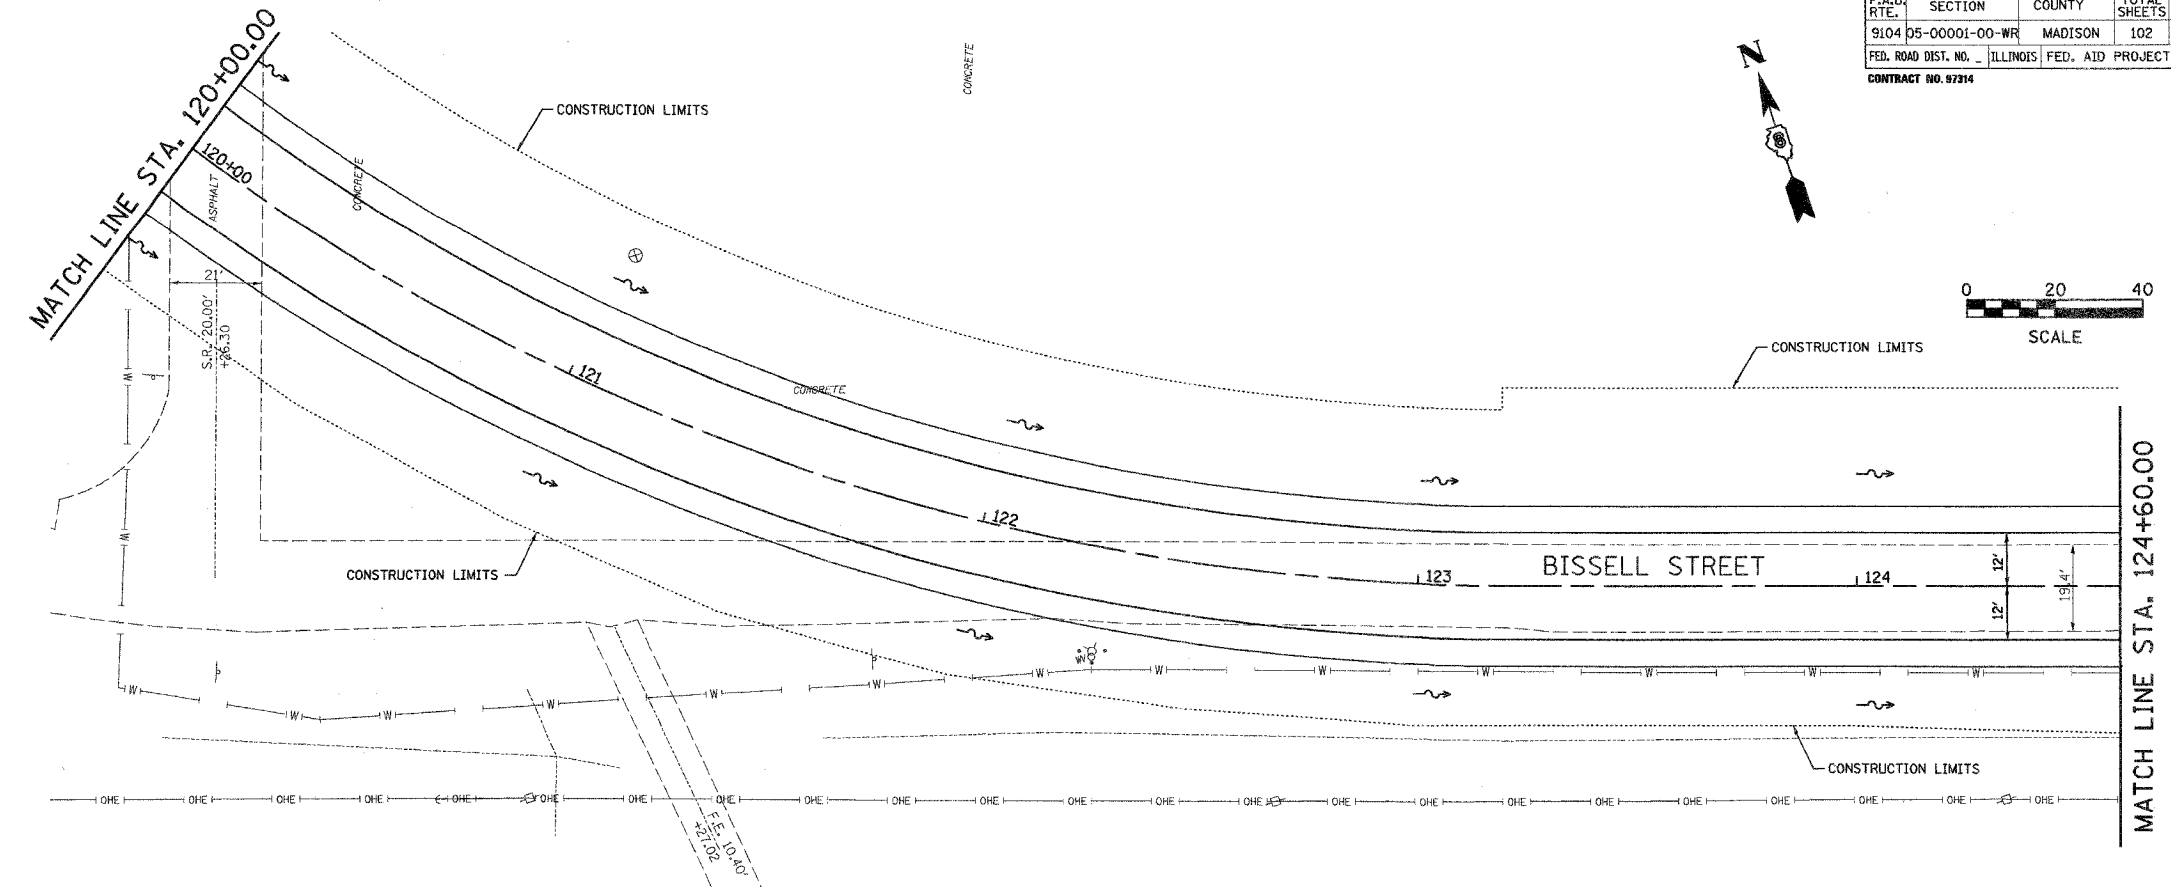


F.A.U. RTE.	SECTION	COUNTY	TOTAL SHEETS	SHEET NO.
9104 D5-00001-00-WR	MADISON	ILLINOIS	102	44
FED. ROAD DIST. NO. - ILLINOIS FED. AID PROJECT				
CONTRACT NO. 97314				



FINAL SURVEYED	BY	DATE
SURVEY PLOTTED		
NOTE BOOK TEMPLATE		
AREAS CHECKED		
NO.		

ORIGINAL SURVEYED	BY	DATE
SURVEY PLOTTED		
NOTE BOOK TEMPLATE		
AREAS CHECKED		
NO.		

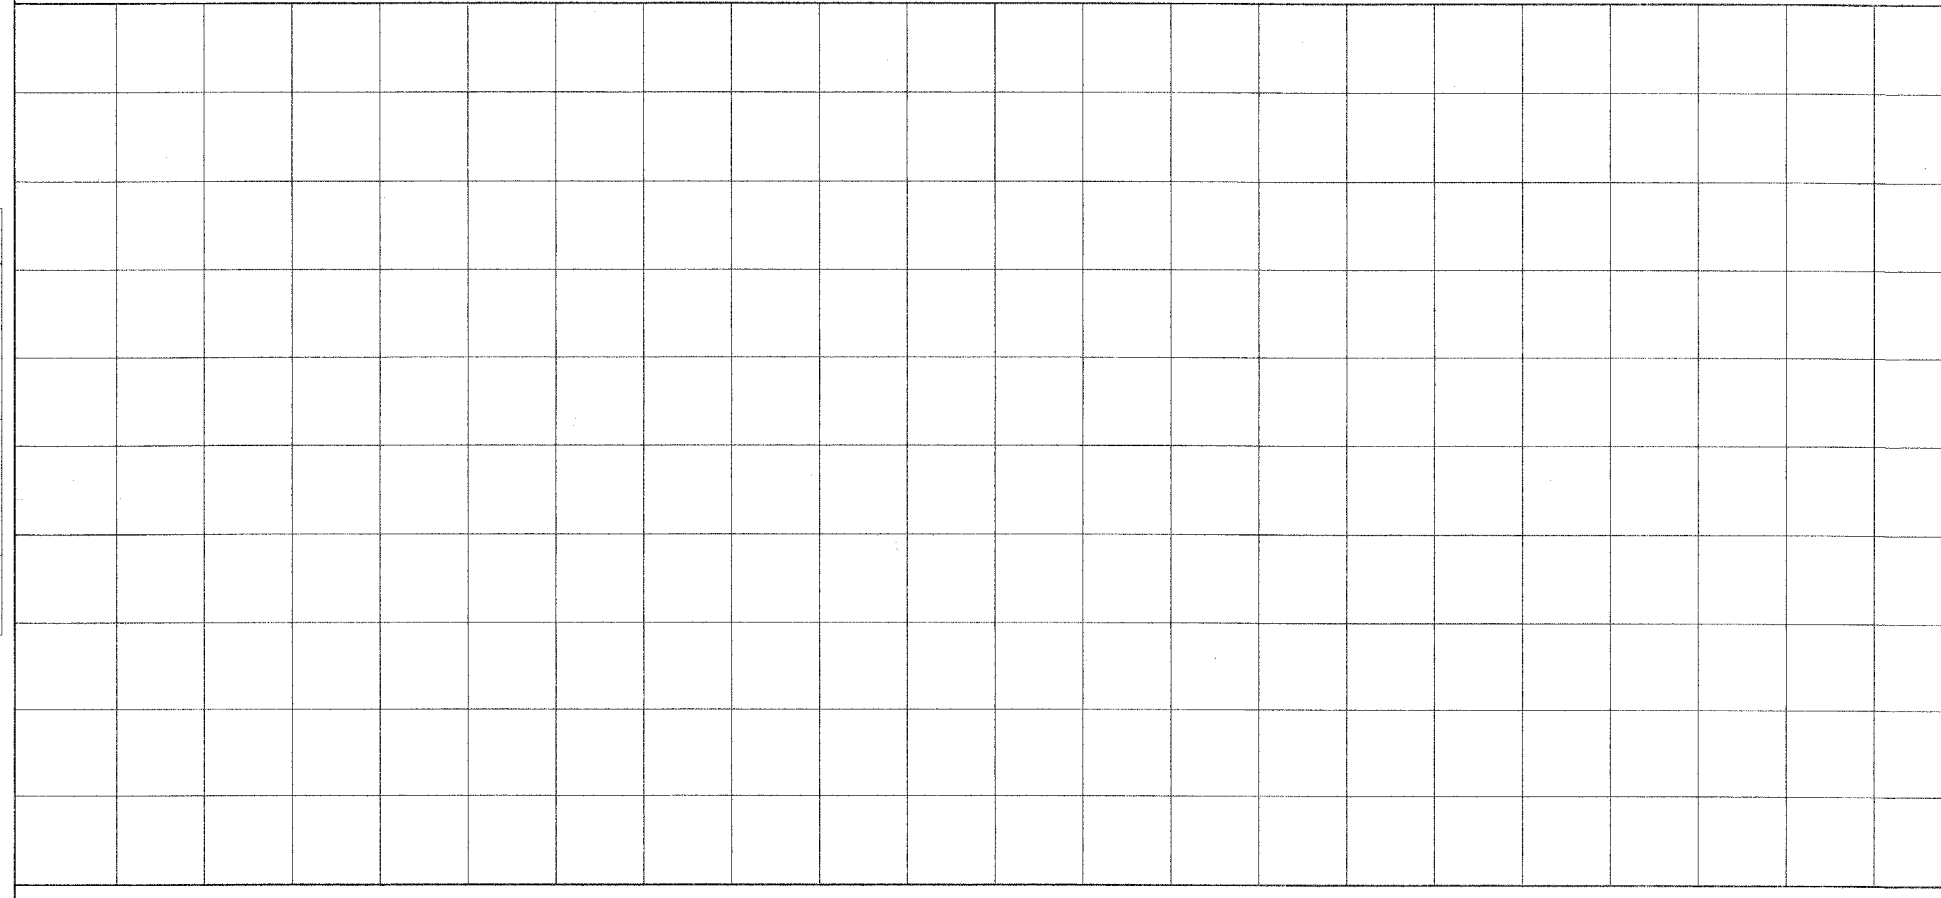

Juneau Associates, Inc. P.C.
 CONSULTING ENGINEERS AND LAND SURVEYORS
 2200 State Street, P.O. Box 1200 / 100 North Hennepin Drive
 Granite City, Illinois 62040 / Deerfield, Illinois 60015
 Phone: (618) 271-1400 / (618) 482-3372 / Phone: (847) 480-4000 / (618) 429-0990
 Fax: (618) 242-5241 / Fax: (847) 489-0941

DRAINAGE PLAN
BISSELL STREET
MADISON, ILLINOIS
SECTION No. 05-00001-00-WR

REVISIONS			
NO.	DATE	BY	REMARKS
DWG. NO.			

SCALE: 1 inch = 20 feet			
DSN. BY:	BFK	DATE:	1/19/07
DWN. BY:	JDH	DATE:	1/19/07
CHKD:	BFK	DATE:	1/19/07
JOB NO.	E061300	DGN. NAME:	DRAIN02
		OF 102	SHTS

MATCH LINE STA. 124+60.00