


BY	DATE
SURVEYED	
PLOTTED	
NOTE BOOK	
TEMPLATE	
AREAS CHECKED	
NO.	

BY	DATE
ORIGINAL SURVEYED	
PLOTTED	
NOTE BOOK	
TEMPLATE	
AREAS CHECKED	
NO.	

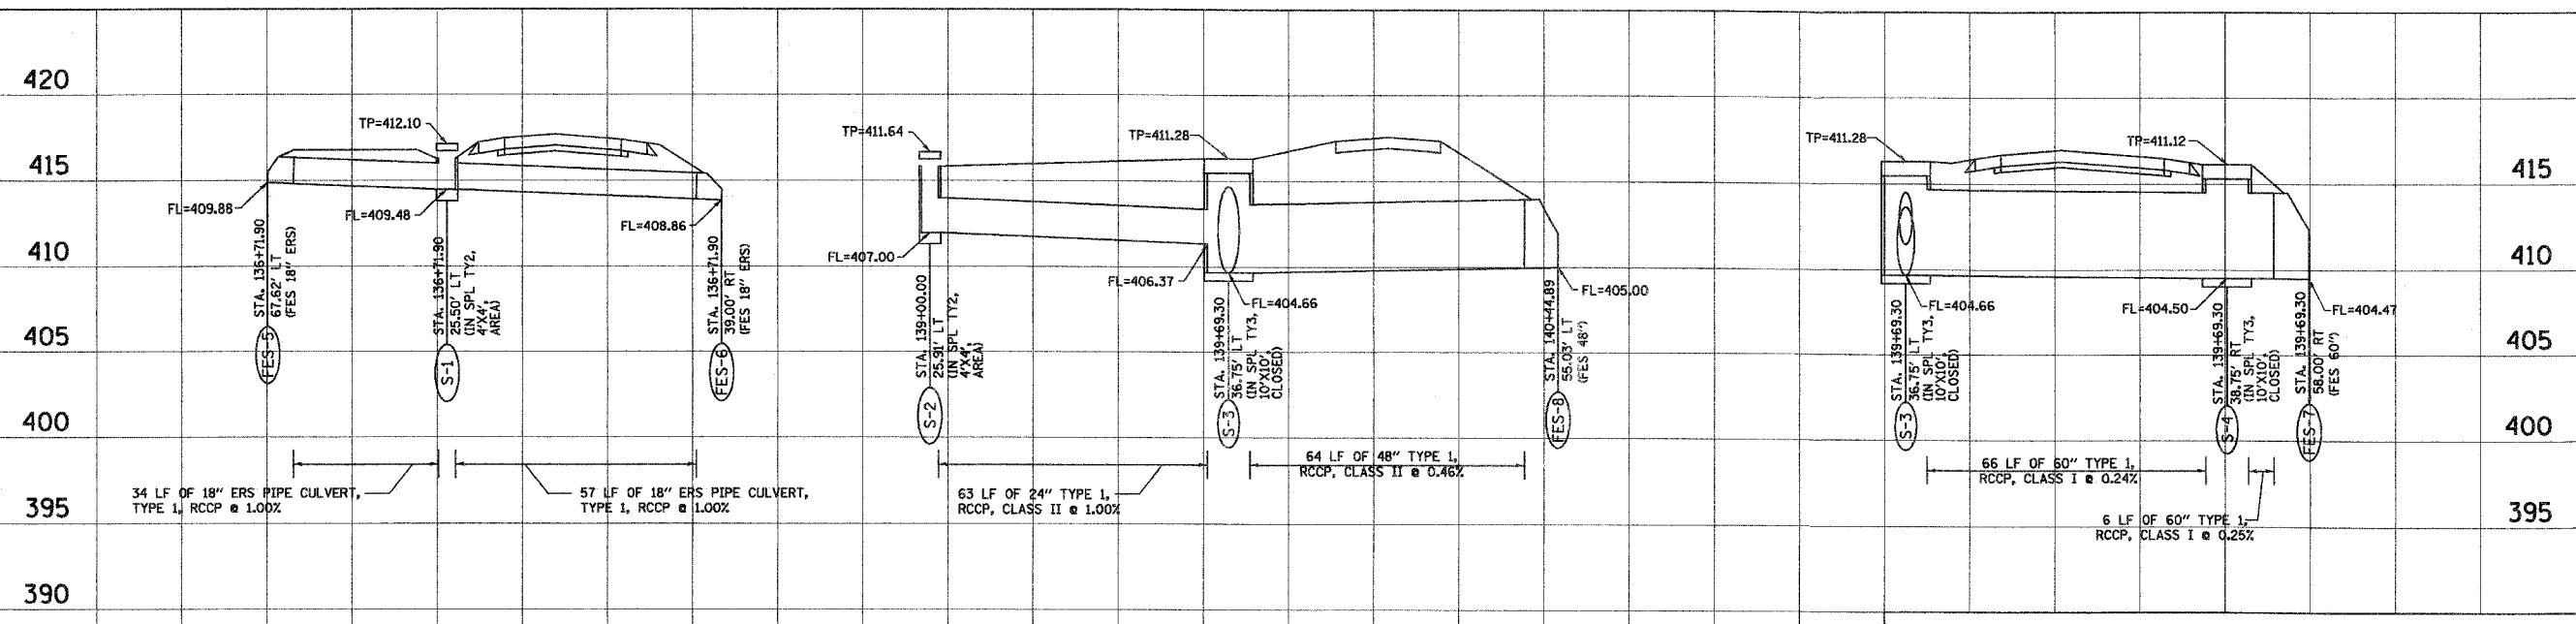

Jureau Associates, Inc. P.C.
CONSULTING ENGINEERS AND LAND SURVEYORS
2100 State Street, P.O. Box 1326
Granite City, Illinois 62040
Phone: (618) 938-4000 / (618) 938-4001
Fax: (618) 938-4001

DRAINAGE PLAN AND PROFILE
BISSELL STREET
MADISON, ILLINOIS
SECTION No. 05-00001-06-WR

REVISIONS			
NO.	DATE	BY	REMARKS

SCALE:
1 inch = 20 feet

DSN. BY: BFK	DATE: 1/19/07	SHEET 50
DWN. BY: JDH	DATE: 1/19/07	
CHK'D: BFK	DATE: 1/19/07	

DWG. NO. JOB NO. E061300 DGN. NAME: DRANOS OF 102 SHTS