

F.A. RTE.	SECTION	COUNTY	TOTAL SHEETS	SHEET NO.
9127	06-00081-02-LS	MADISON	45	1
FED ROAD DIST. NO.		ILLINOIS	FED. AID PROJECT	

STATE OF ILLINOIS
DEPARTMENT OF TRANSPORTATION
PLANS FOR PROPOSED
CITY OF COLLINSVILLE

DOWNTOWN COLLINSVILLE STREETScape PH 2

SECTION 06-00081-02-LS

MADISON COUNTY
PROJECT NO. TE-00D8 (114)
JOB NO. C-98-304-07

INDEX OF SHEETS


SHEET NO.	ITEM
1	COVER SHEET
2	GENERAL NOTES
3	SUMMARY OF QUANTITIES
4-5	TYPICAL SECTIONS
6-10	PLAN & PROFILE SHEETS
11-14	STORMWATER PREVENTION PLANS
15-16	INTERSECTION DETAIL SHEETS
17	ENTRANCE DETAILS
18	SIDEWALK AND CURB DETAILS
19	DRAINAGE DETAILS
20	TREE GRATE AND PLANTING DETAILS
21	SIGN SCHEDULE
22-24	SIGN PLAN SHEETS
25	COAL CHUTE DETAILS
26-27	ELECTRICAL PLAN SHEET
28	ELECTRICAL DETAILS
29-30	MISCELLANEOUS DETAILS
31-45	CROSS SECTIONS

SCALE IN FEET
PLAN 1"=20'
CROSS SECTION (HORIZ) 1"=10'
(VERT) 1"=5'



STANDARDS

000001-04	701601-04
280001-03	701701-04
424001-04	701801-03
602301-01	720001
602701-01	720006-01
604006-02	720011
604041-01	729001
606001-03	780001-01
606301-03	702001-06

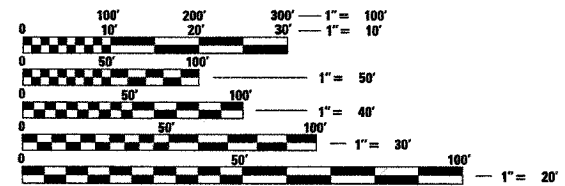


FULL SIZE PLANS HAVE BEEN PREPARED USING STANDARD ENGINEERING SCALES. REDUCED SIZED PLANS WILL NOT CONFORM TO STANDARD SCALES. IN MAKING MEASUREMENTS ON REDUCED PLANS, THE ABOVE SCALES MAY BE USED.

J.U.L.I.E.
JOINT UTILITY LOCATION INFORMATION FOR EXCAVATION
1-800-892-0123

SECTION ENDS @ STA. 29+06
SEMINARY STREET

SECTION BEGINS @ STA. 10+00
COMBS STREET

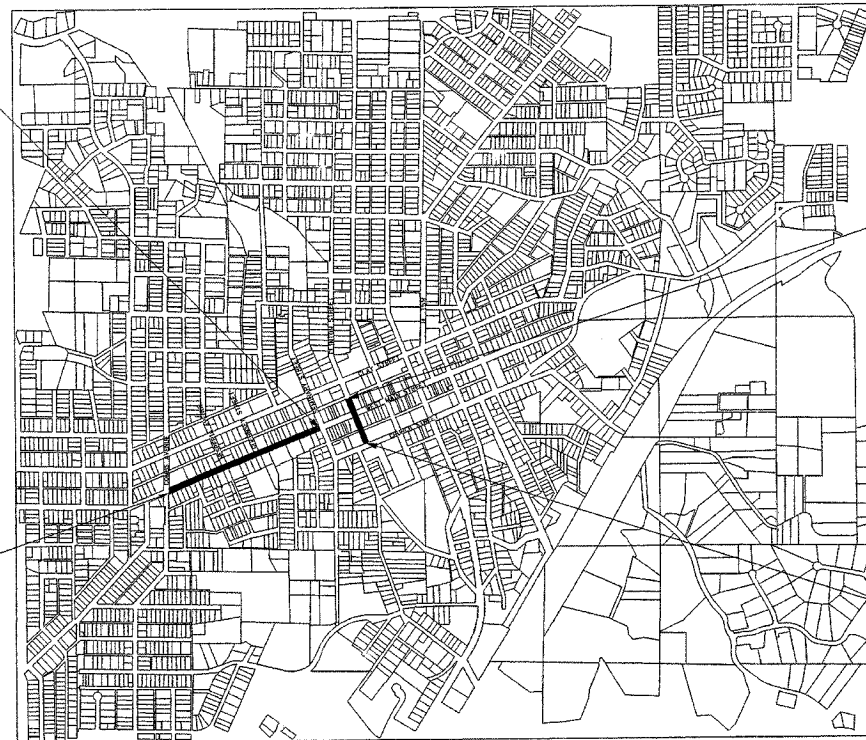

SECTION ENDS @ STA. 55+93
ALLEY NORTH OF MAIN STREET

SECTION BEGINS @ STA. 50+00
CHURCH STREET



LOCATION MAP
SCALE 1"=1,000'

LENGTH OF MAIN STREET IMPROVEMENTS = 1,906 FT (0.361 MILES)
LENGTH OF CLINTON STREET IMPROVEMENTS = 593 FT (0.112 MILES)
TOTAL LENGTH OF IMPROVEMENTS = 2,499 FT (0.473 MILES)

ILLINOIS DEPARTMENT OF TRANSPORTATION

APPROVED 06/07/07 2007
Stan Schaeffer Mayor
STAN SCHAEFFER MAYOR OF COLLINSVILLE

PASSED June 11 2007
[Signature]
DISTRICT 8 ENGINEER OF LOCAL ROADS & STREETS

RELEASED FOR BID
BASED ON LIMITED
REVIEW June 11 2007
Way C. Daniel, Jr.
DEPUTY DIRECTOR OF HIGHWAYS, REGION 5 ENGINEER



EXPIRES 11-30-2007

Philip A. Murphy
PHILIP A. MURPHY, P.E.

DATE: 06/07/07

