
 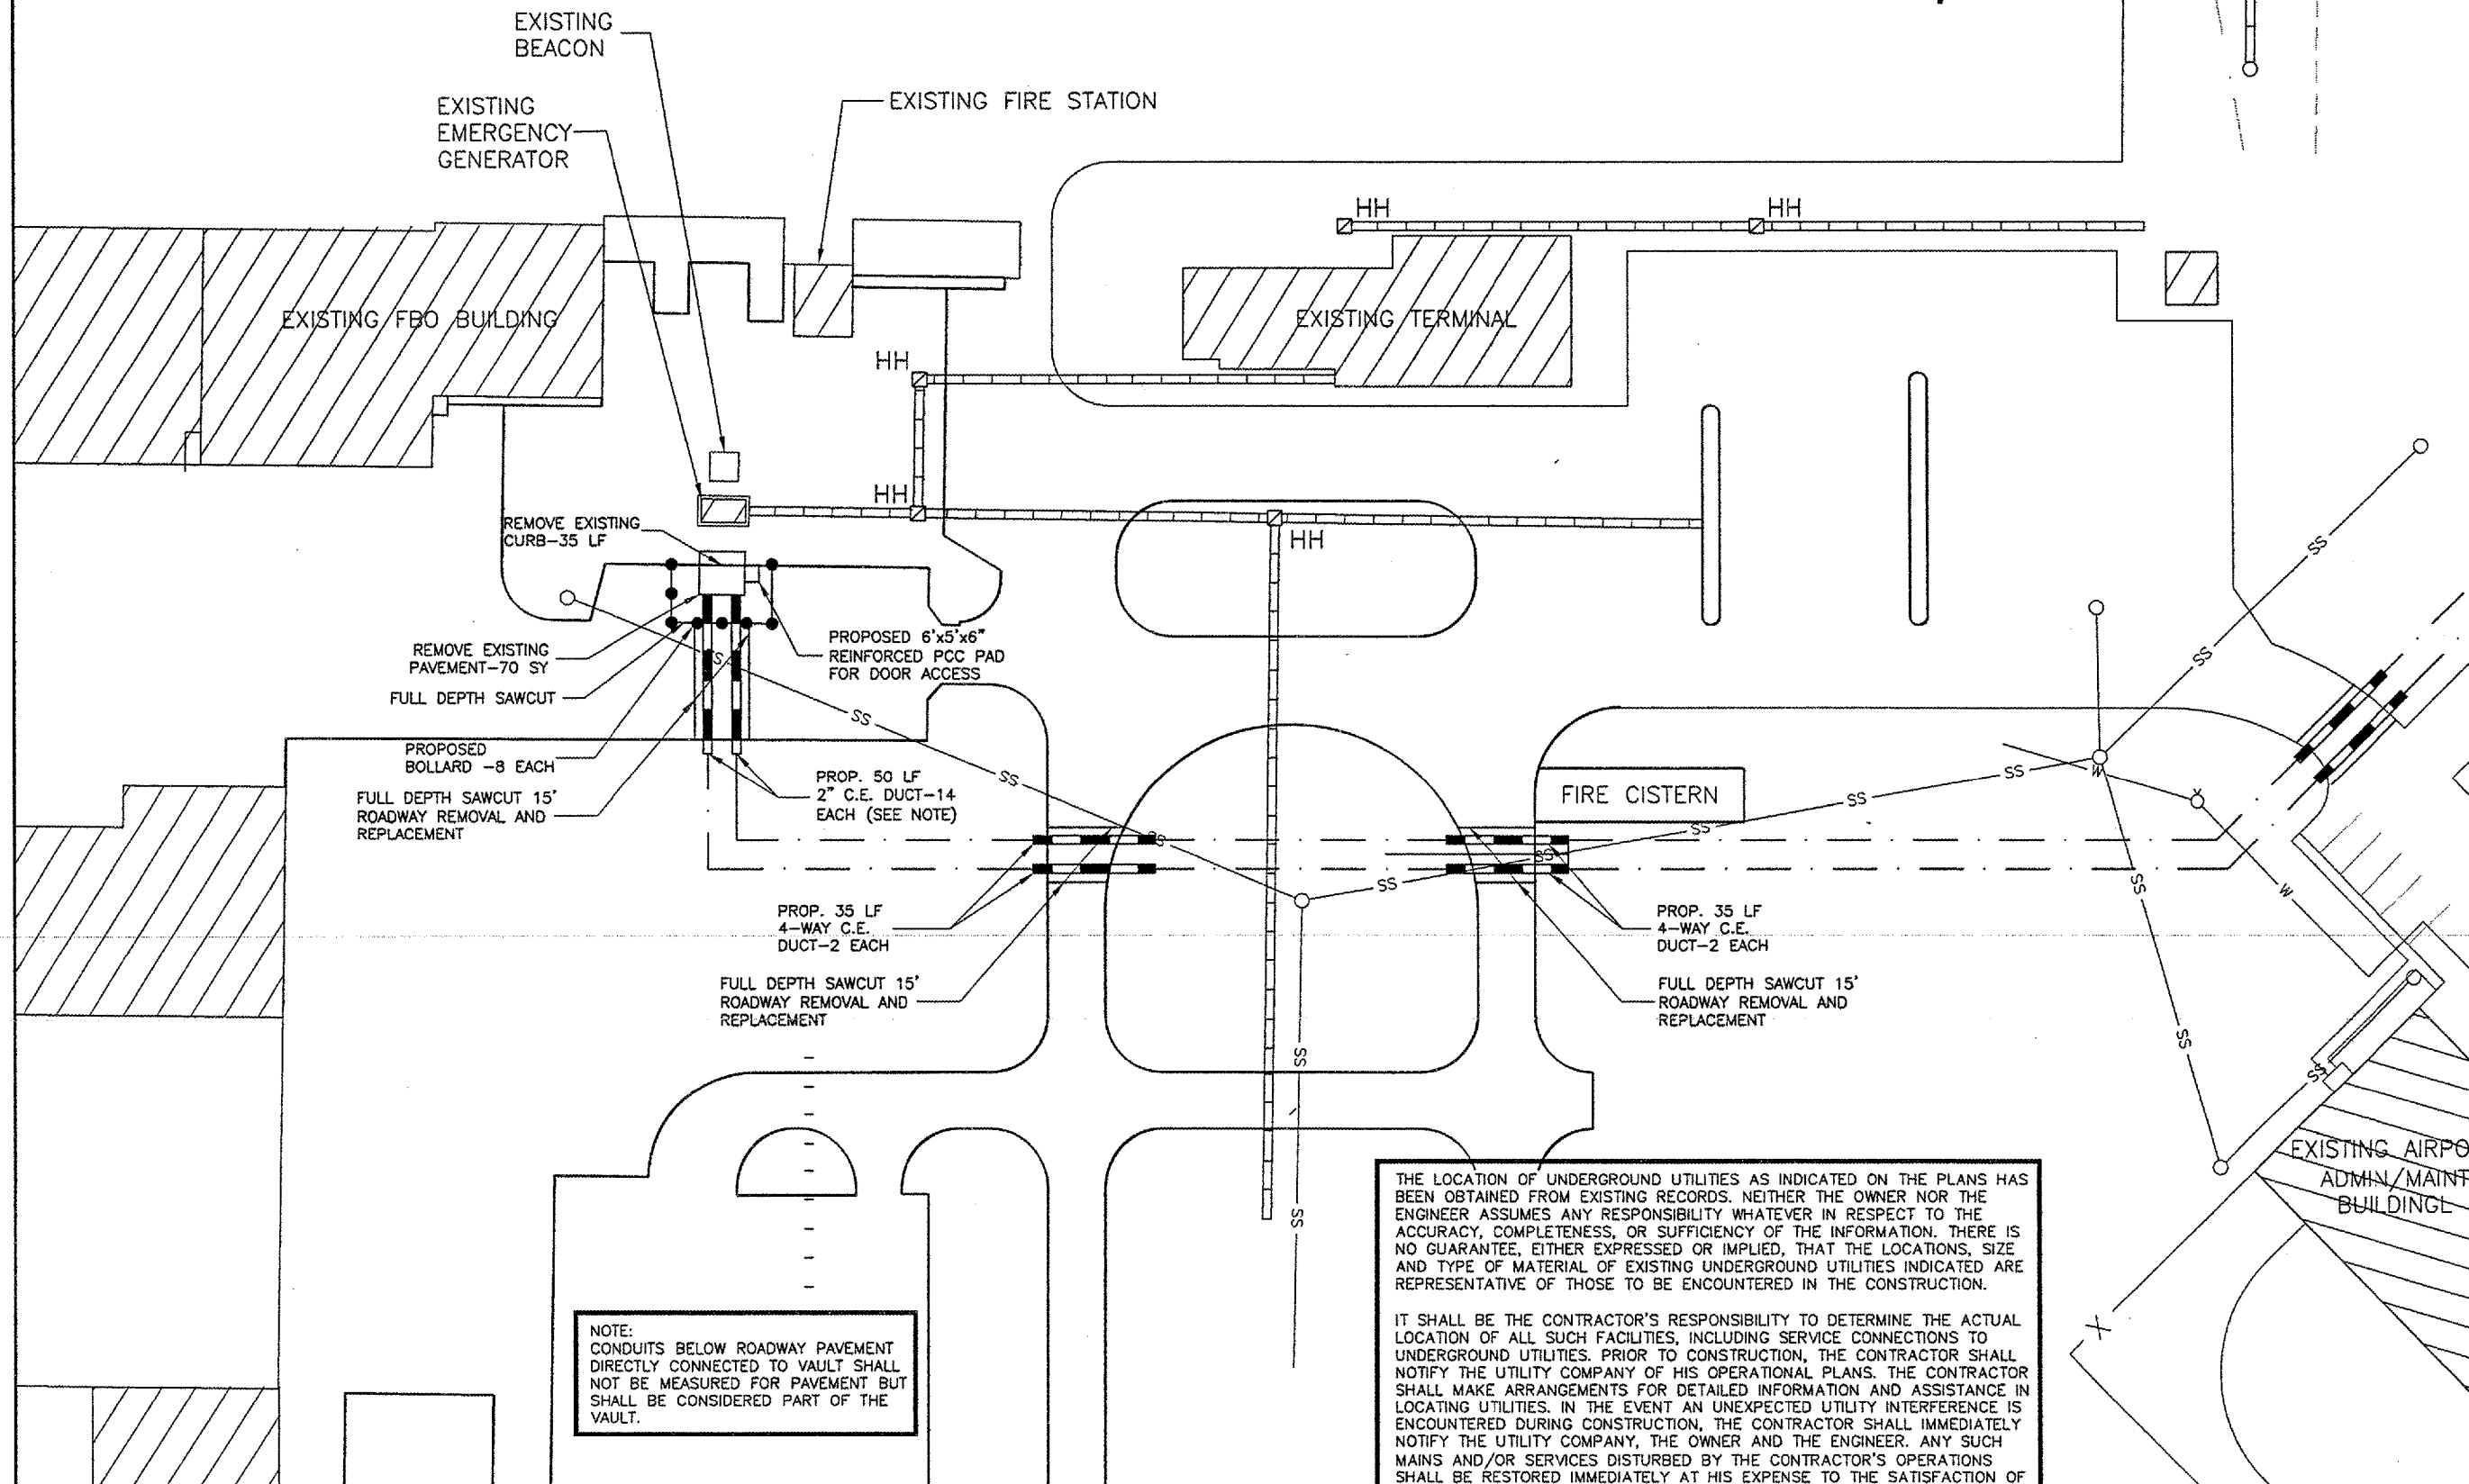


REVISIONS		
NUMBER	BY	DATE



NOTE:  
 CONDUITS BELOW ROADWAY PAVEMENT DIRECTLY CONNECTED TO VAULT SHALL NOT BE MEASURED FOR PAVEMENT BUT SHALL BE CONSIDERED PART OF THE VAULT.

THE LOCATION OF UNDERGROUND UTILITIES AS INDICATED ON THE PLANS HAS BEEN OBTAINED FROM EXISTING RECORDS. NEITHER THE OWNER NOR THE ENGINEER ASSUMES ANY RESPONSIBILITY WHATEVER IN RESPECT TO THE ACCURACY, COMPLETENESS, OR SUFFICIENCY OF THE INFORMATION. THERE IS NO GUARANTEE, EITHER EXPRESSED OR IMPLIED, THAT THE LOCATIONS, SIZE AND TYPE OF MATERIAL OF EXISTING UNDERGROUND UTILITIES INDICATED ARE REPRESENTATIVE OF THOSE TO BE ENCOUNTERED IN THE CONSTRUCTION.

IT SHALL BE THE CONTRACTOR'S RESPONSIBILITY TO DETERMINE THE ACTUAL LOCATION OF ALL SUCH FACILITIES, INCLUDING SERVICE CONNECTIONS TO UNDERGROUND UTILITIES. PRIOR TO CONSTRUCTION, THE CONTRACTOR SHALL NOTIFY THE UTILITY COMPANY OF HIS OPERATIONAL PLANS. THE CONTRACTOR SHALL MAKE ARRANGEMENTS FOR DETAILED INFORMATION AND ASSISTANCE IN LOCATING UTILITIES. IN THE EVENT AN UNEXPECTED UTILITY INTERFERENCE IS ENCOUNTERED DURING CONSTRUCTION, THE CONTRACTOR SHALL IMMEDIATELY NOTIFY THE UTILITY COMPANY, THE OWNER AND THE ENGINEER. ANY SUCH MAINS AND/OR SERVICES DISTURBED BY THE CONTRACTOR'S OPERATIONS SHALL BE RESTORED IMMEDIATELY AT HIS EXPENSE TO THE SATISFACTION OF THE OWNER AND THE ENGINEER.

VERMILION COUNTY AIRPORT  
 DANVILLE, ILLINOIS

RELOCATE AIRFIELD ELECTRICAL VAULT

ELECTRICAL PLAN 1

© Copyright CMT, Inc.  
 CMT  
 CRAWFORD, MURPHY & TILLY, INC.  
 CONSULTING ENGINEERS  
 License No. BR-000513

DESIGN BY:	CMT
DRAWN BY:	CMT
CHECKED BY:	
APPROVED BY:	
DATE:	06-22-2007
JOB No:	0704202
ILLINOIS PROJECT DNV-3684 A.I.P. PROJECT 3-17-0032-811	
SHEET 4 OF 16 SHEETS	