


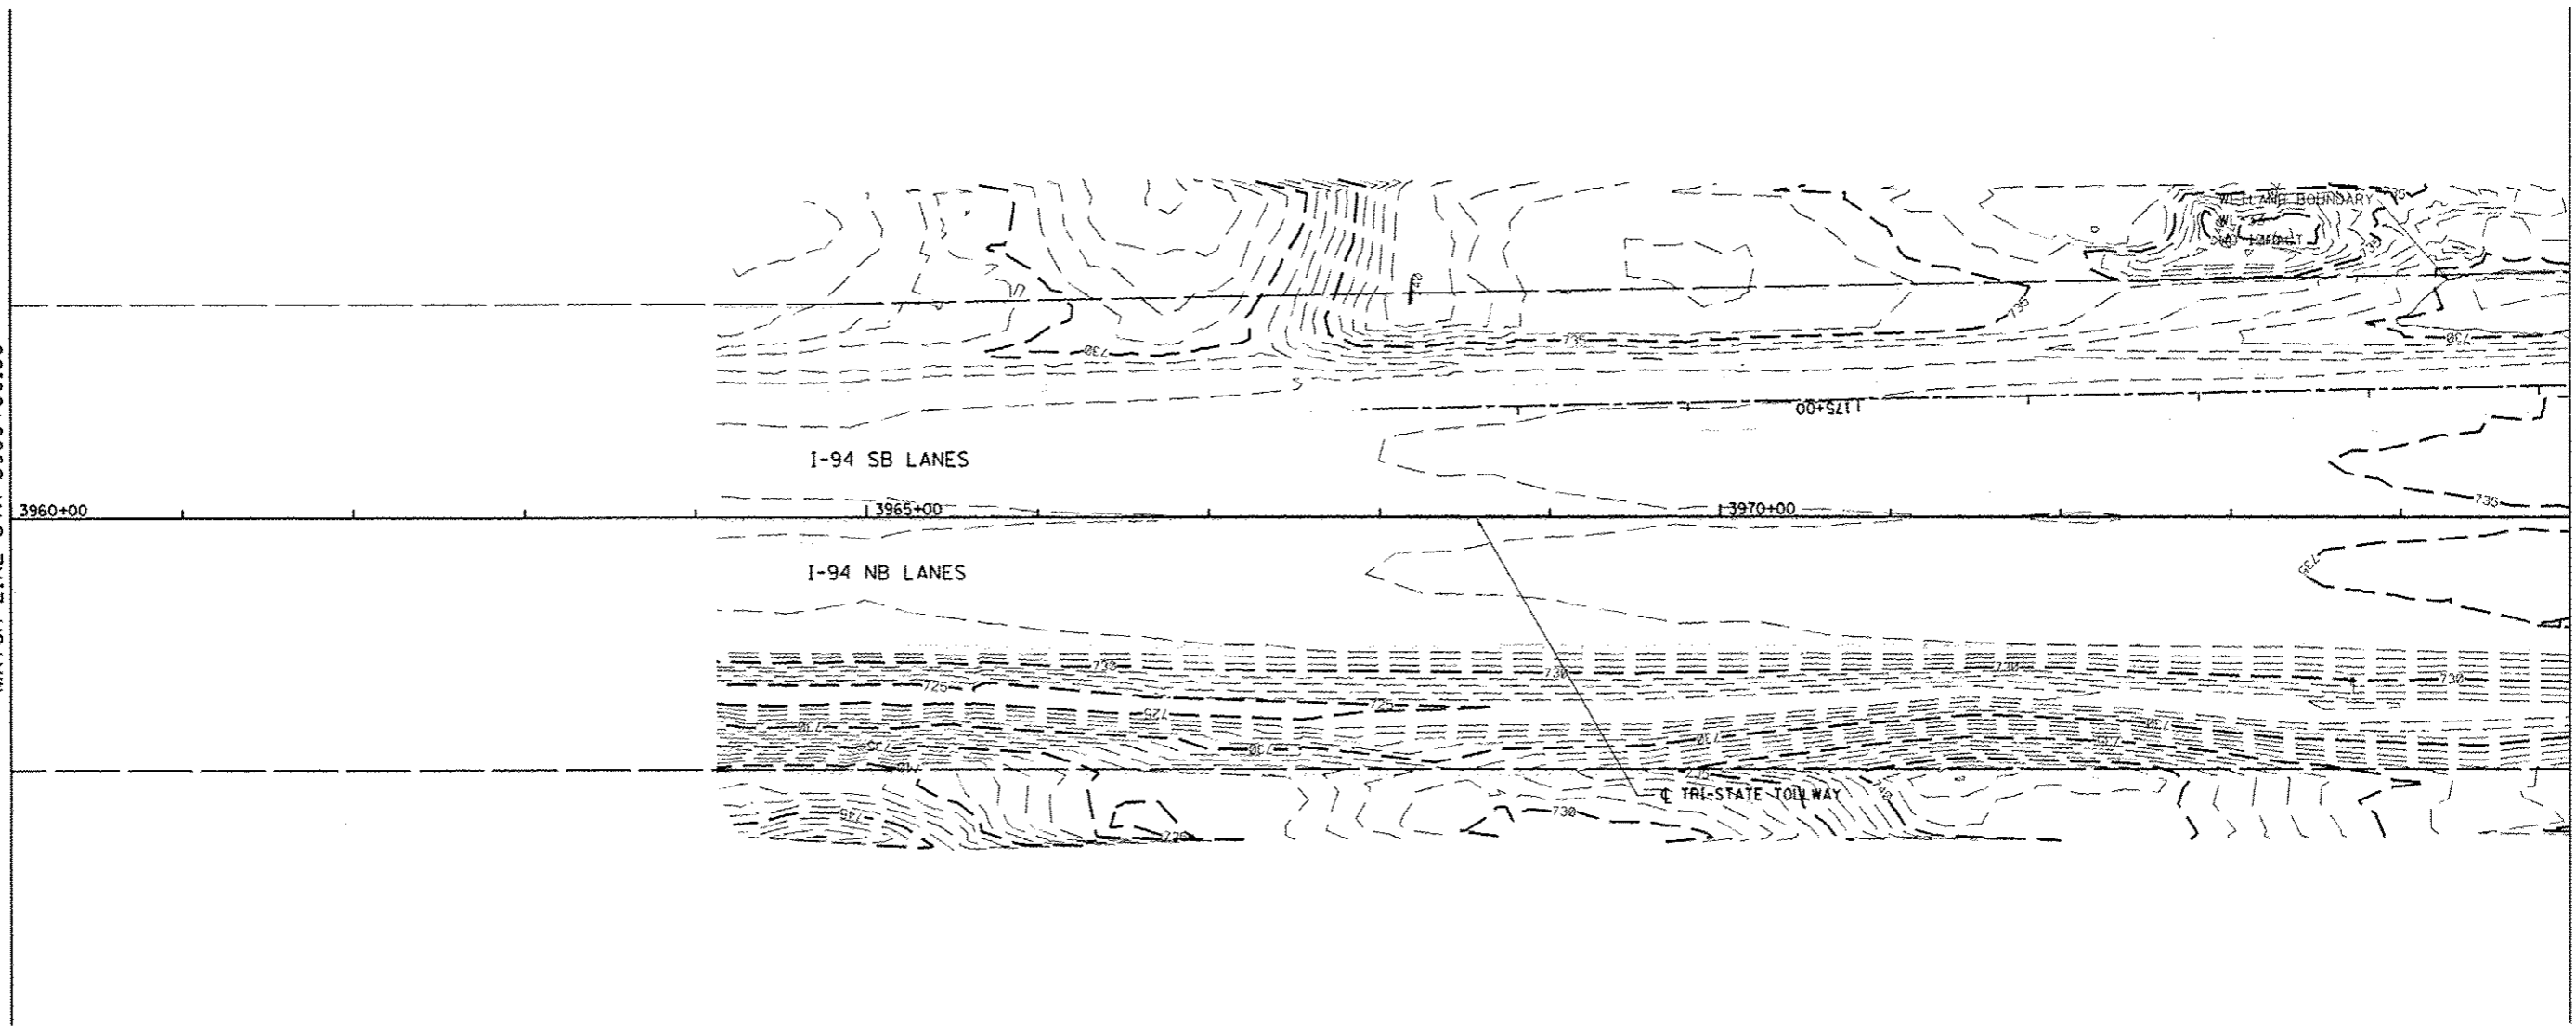

MATCH LINE STA 3960+00.00

MATCH LINE STA 3975+00.00



BOWMAN, BARRETT & ASSOCIATES INC.
 CONSULTING ENGINEERS
 Chicago, Illinois
 312.228.0100
 www.bbandinc.com



FILE NAME - #FILES#	USER NAME - default	DESIGNED - PTC	REVISED Δ 7/17/12 RGR
		DRAWN - PTC	REVISED -
	PLOT SCALE = 1/4"=10' 1/8"=10'	CHECKED - RGR	REVISED -
	PLOT DATE = 7/17/2012	DATE - 6/19/2012	REVISED -

STATE OF ILLINOIS
DEPARTMENT OF TRANSPORTATION

PROPOSED GRADING PLAN
 SCALE: 1"=50' SHEET NO. 1 OF 15 SHEETS STA. 3960+00 TO STA. 3975+00

P.A. RTE.	SECTION	COUNTY	TOTAL SHEETS	SHEET NO.
94	49-1-R-1	LAKE	677	320
			CONTRACT NO. 60L77	
ILLINOIS FED. AID PROJECT				

S:\18105-CAD\00\18105-01-17-12-01-27-Sheet\18105-01-17-12-01-27-01.dwg