


TOLLWAY CONDUIT TAGS:

TAG	DESCRIPTION
(A)	2" DIA. UNIT DUCT WITH 4-1/C NO. 4, 1-1/C NO. 6 GND
(B)	2" DIA. UNIT DUCT WITH 2-1/C NO. 4, 1-1/C NO. 6 GND
(C)	2" DIA. UNIT DUCT WITH 4-1/C NO. 2, 1-1/C NO. 4 GND

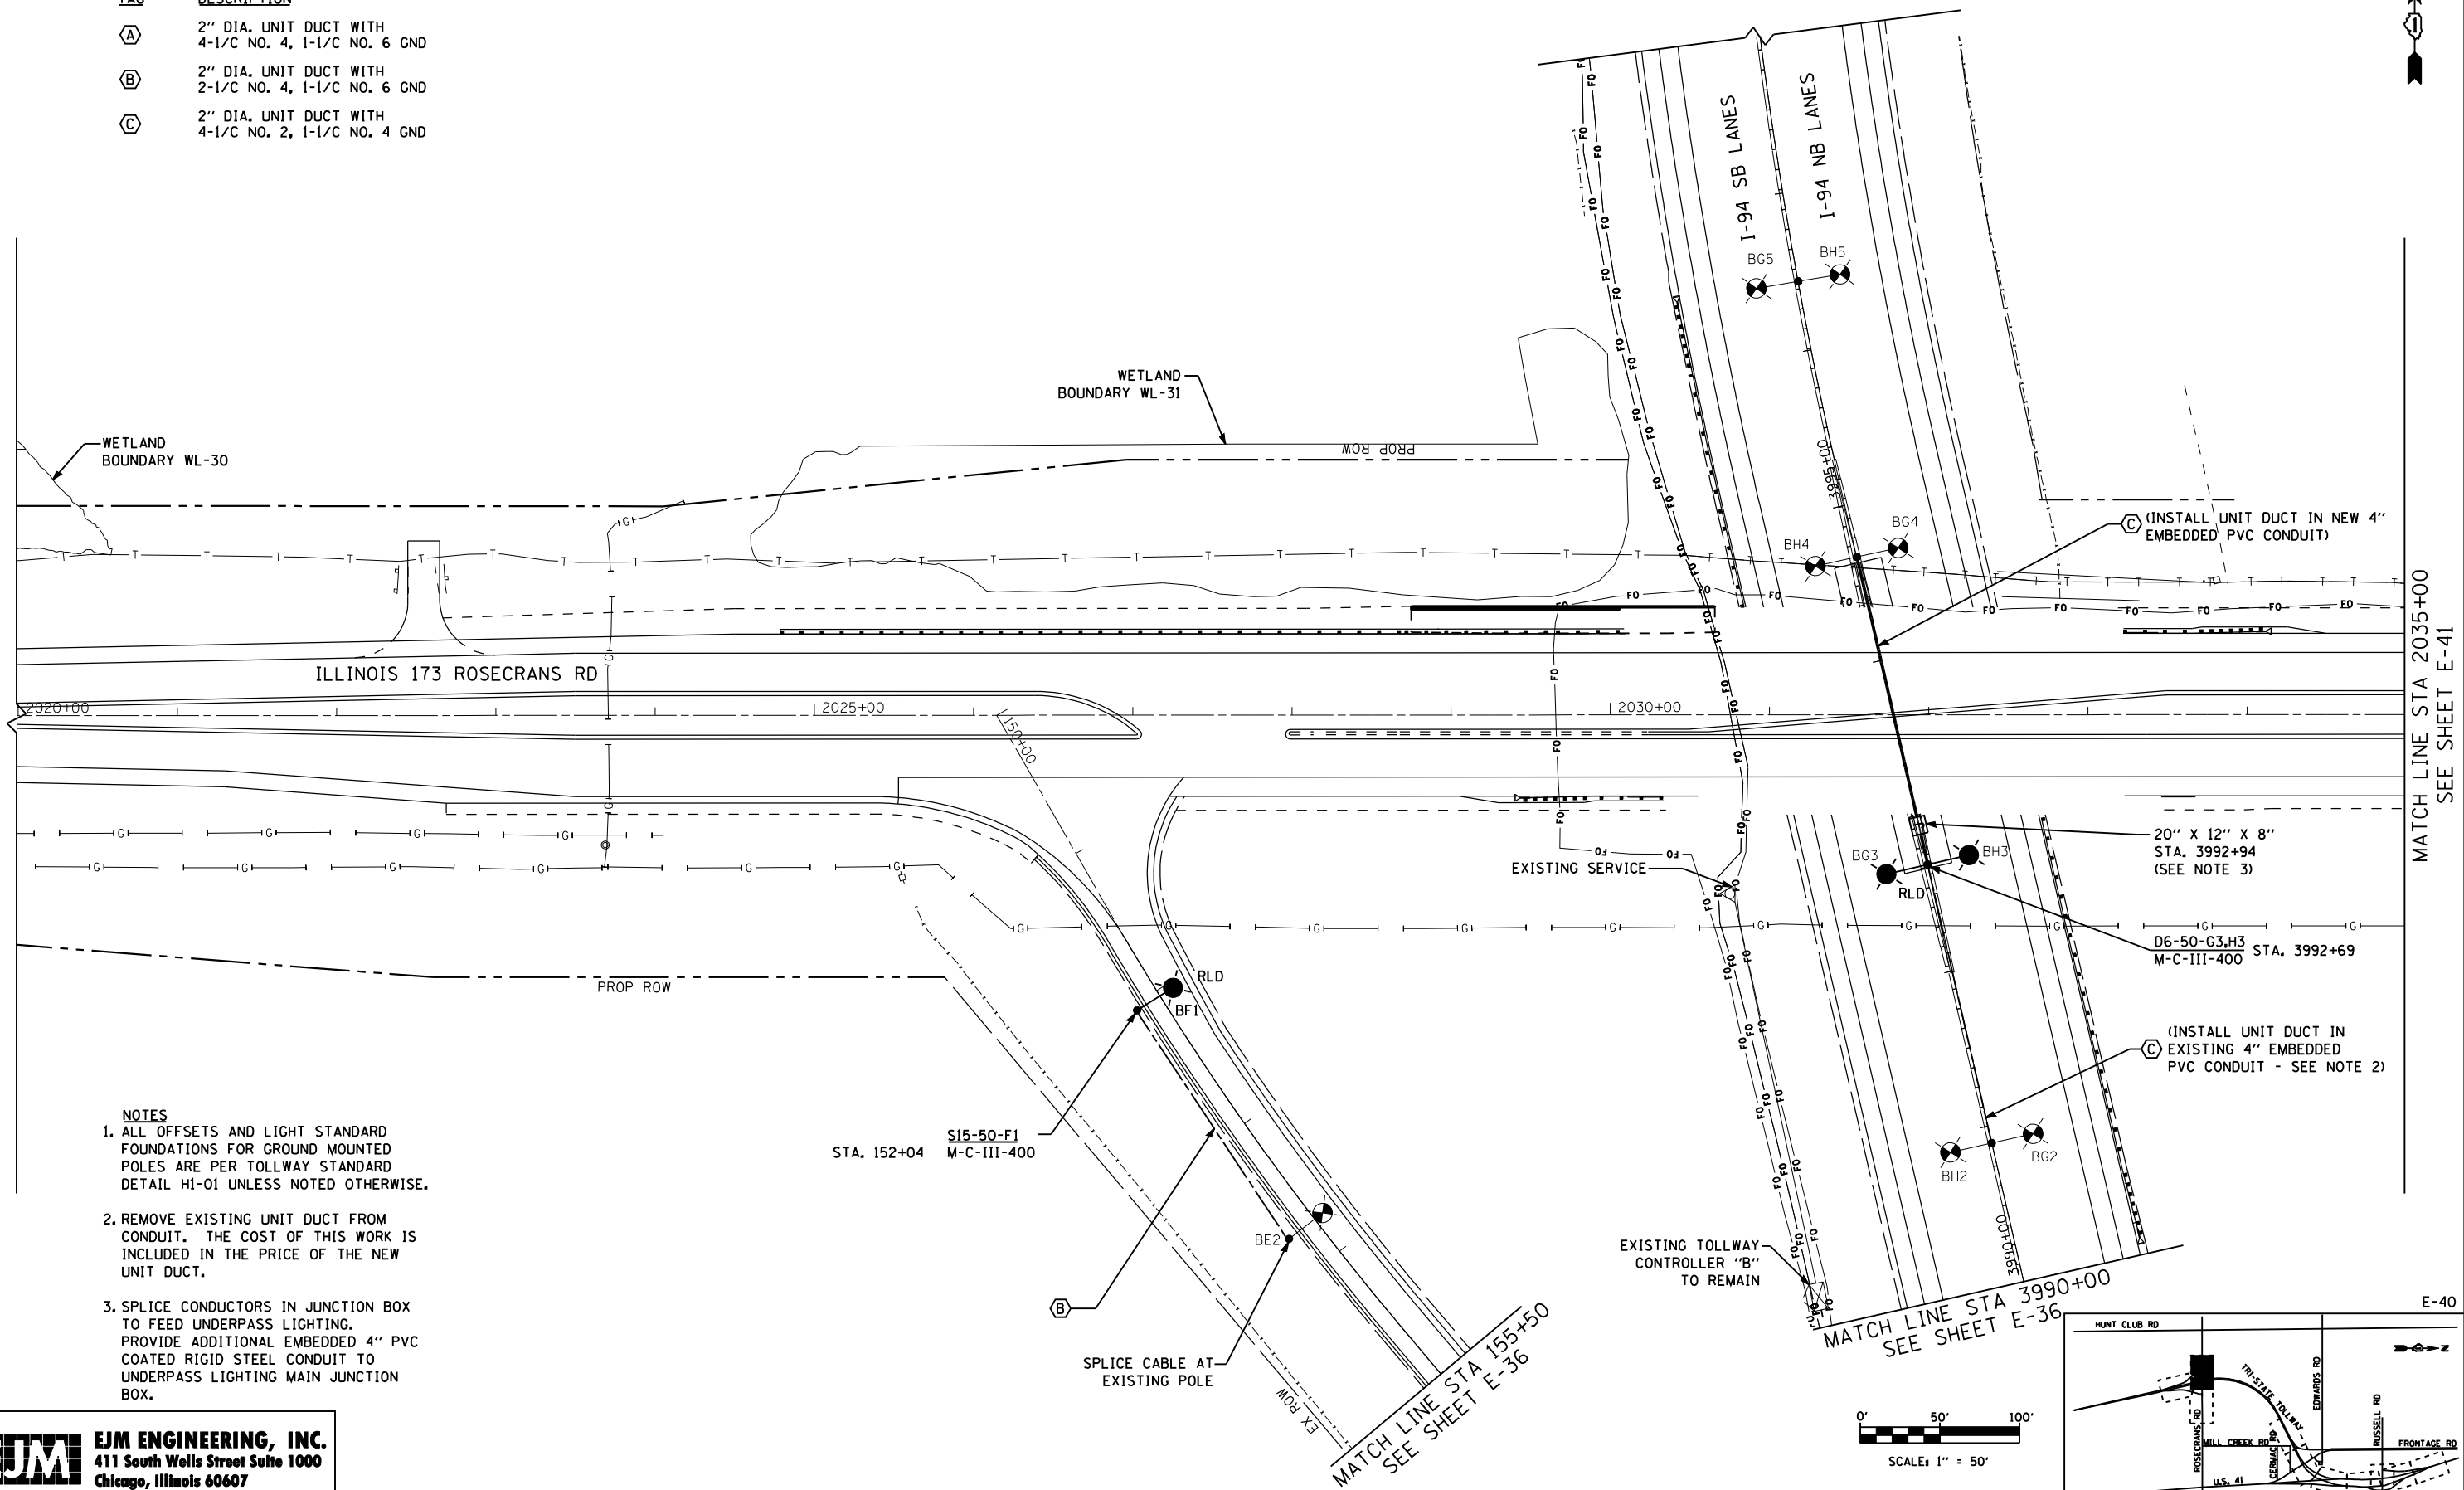

- NOTES**
1. ALL OFFSETS AND LIGHT STANDARD FOUNDATIONS FOR GROUND MOUNTED POLES ARE PER TOLLWAY STANDARD DETAIL HI-01 UNLESS NOTED OTHERWISE.
 2. REMOVE EXISTING UNIT DUCT FROM CONDUIT. THE COST OF THIS WORK IS INCLUDED IN THE PRICE OF THE NEW UNIT DUCT.
 3. SPLICE CONDUCTORS IN JUNCTION BOX TO FEED UNDERPASS LIGHTING. PROVIDE ADDITIONAL EMBEDDED 4" PVC COATED RIGID STEEL CONDUIT TO UNDERPASS LIGHTING MAIN JUNCTION BOX.

s:\projects\2012\11-173-rosecrans\11-173-rosecrans\electrical\sheet\11-173-light-40.dwg

EJM ENGINEERING, INC.
 411 South Wells Street Suite 1000
 Chicago, Illinois 60607

FILE NAME	USER NAME = rsonson	DESIGNED - RAS	REVISED -
		DRAWN - BHH	REVISED -
		CHECKED - MKR	REVISED -
		DATE - 6/19/2012	REVISED -

**STATE OF ILLINOIS
 DEPARTMENT OF TRANSPORTATION**

**PROPOSED TOLLWAY LIGHTING PLAN
 ILLINOIS 173 ROSECRANS RD**

SCALE: 1"=50' SHEET NO. 40 OF 53 SHEETS STA. 2020+00 TO STA. 2035+00

F.A. RTE.	SECTION	COUNTY	TOTAL SHEETS	SHEET NO.
94	49-1-R-1	LAKE	677	400
CONTRACT NO. 60L77				
ILLINOIS FED. AID PROJECT				