


D:\p40468\ch\118-entrs\18 & 19\sh\citr\18schedule\cas\003\02.sht

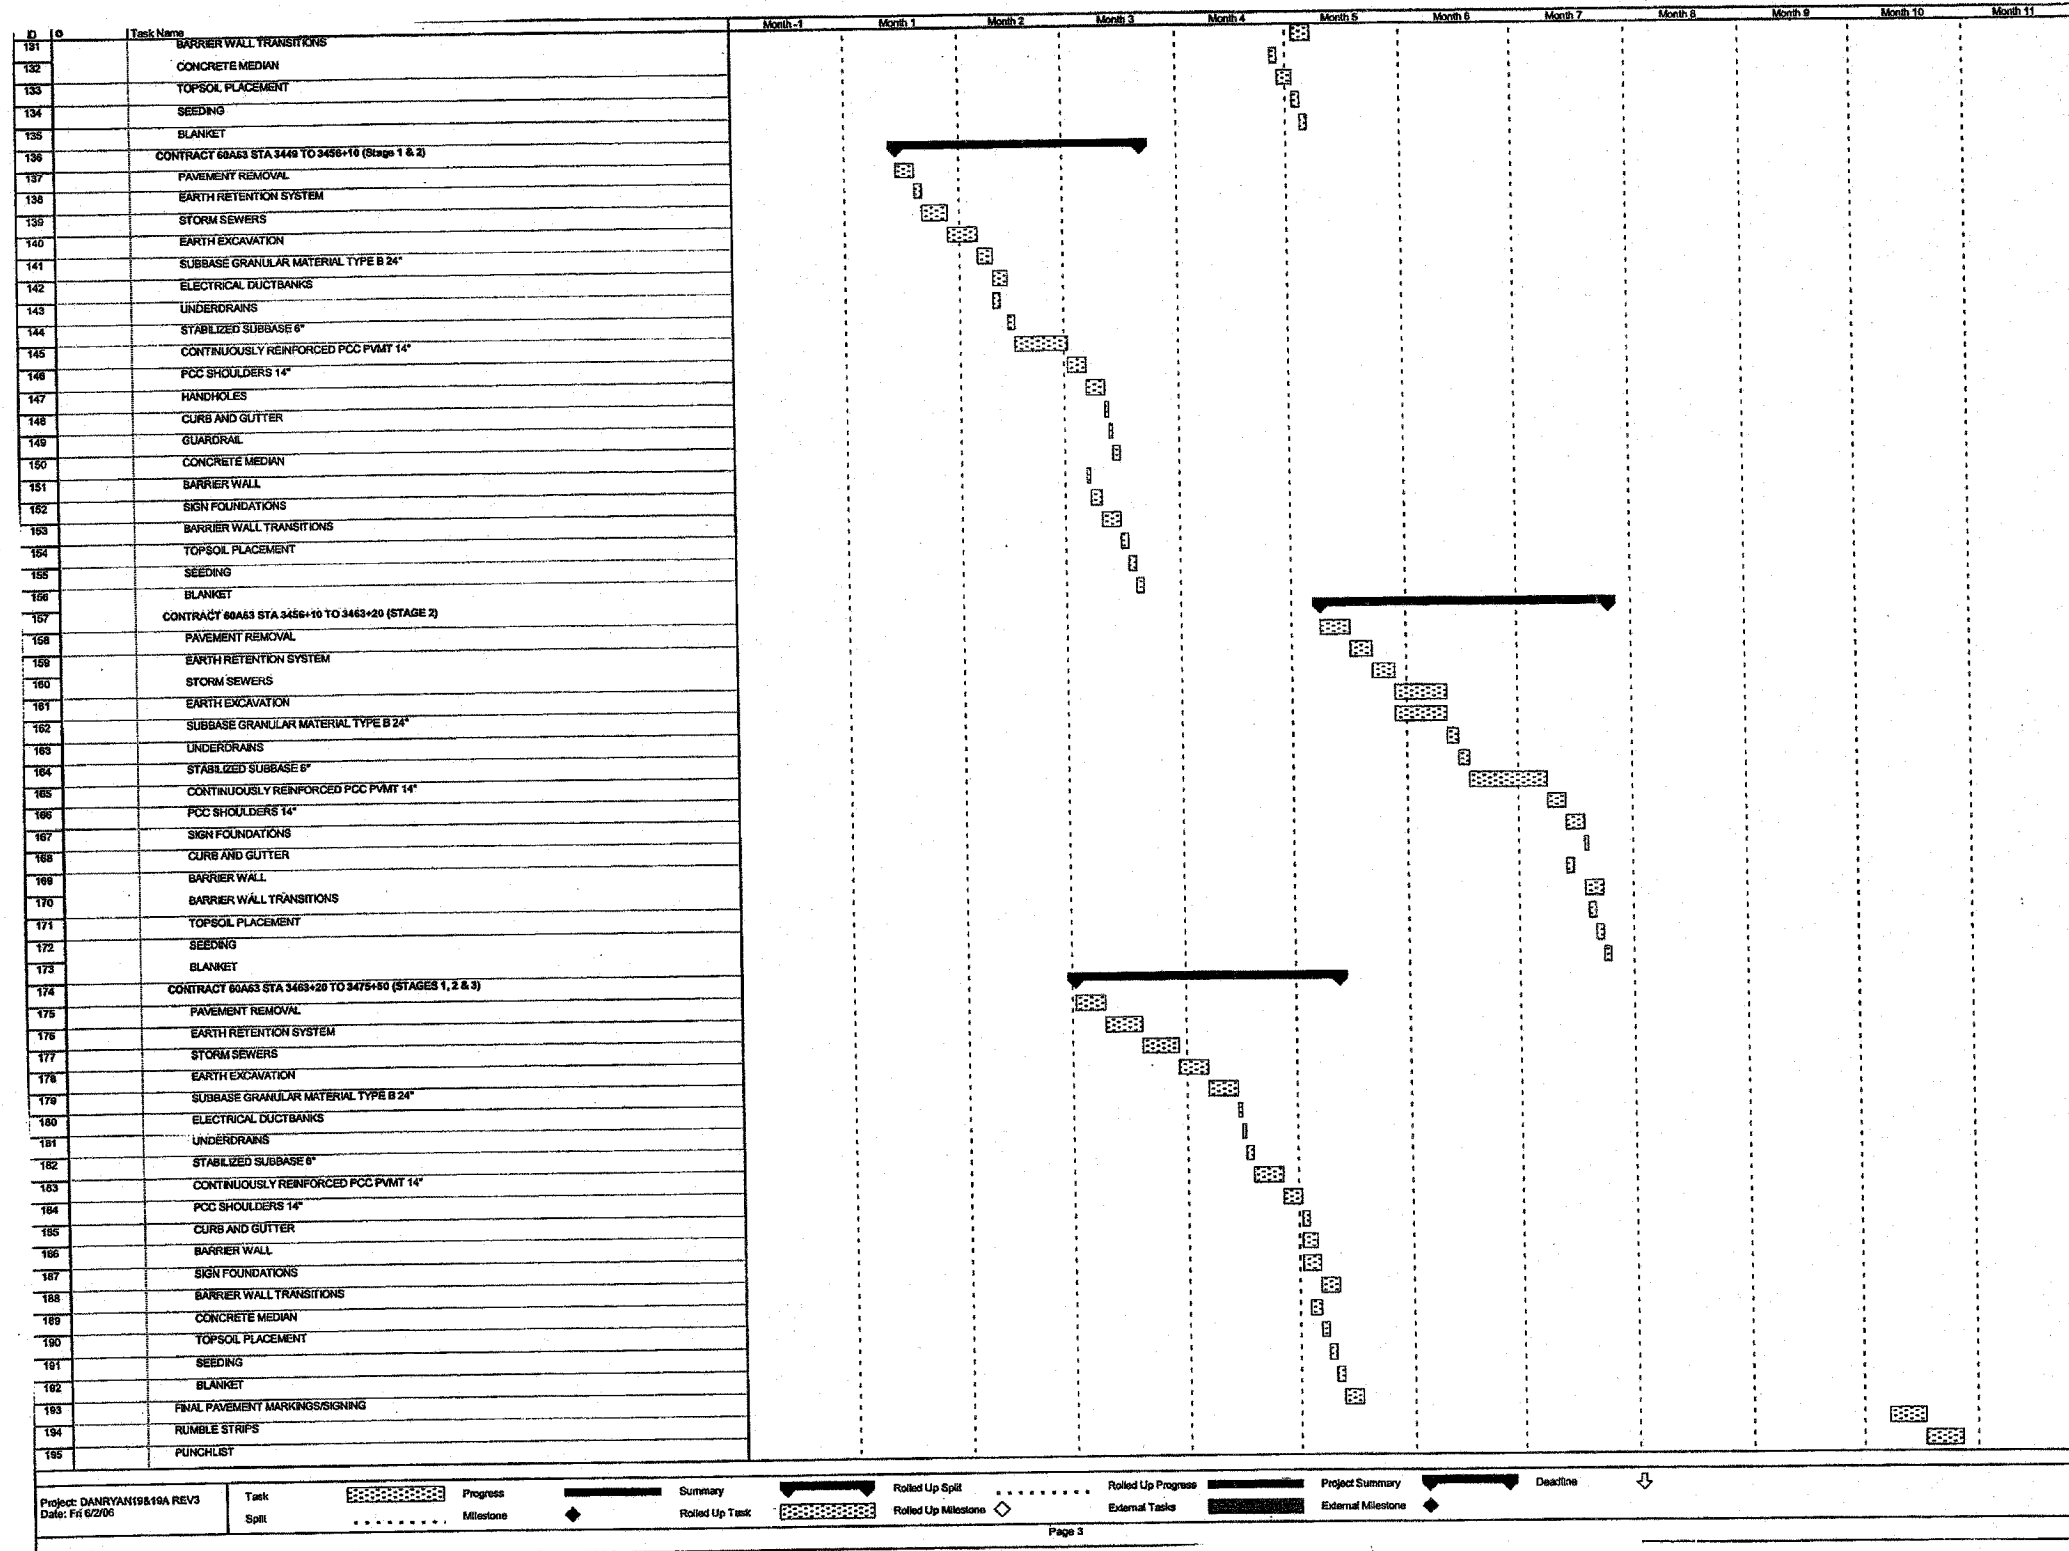

Project: DANRYAN198.19A REV3 Date: Fri 6/2/06

Task Split

Progress Milestone

Summary Rolled Up Task

Rolled Up Split Rolled Up Milestone

Rolled Up Progress External Tasks

Project Summary External Milestone

Deadline

Page 3

REVISIONS	
NAME	DATE

CS-3

ILLINOIS DEPARTMENT OF TRANSPORTATION
F.A.I. 90/94 (DAN RYAN EXPRESSWAY)
GARFIELD BLVD TO 31ST STREET (SB LOCAL LANES)

SUGGESTED SEQUENCE OF OPERATION

SCALE: NONE
DATE: June 9, 2006

DRAWN BY: NJH
CHECKED BY: RMC



7/3/06 PM