
 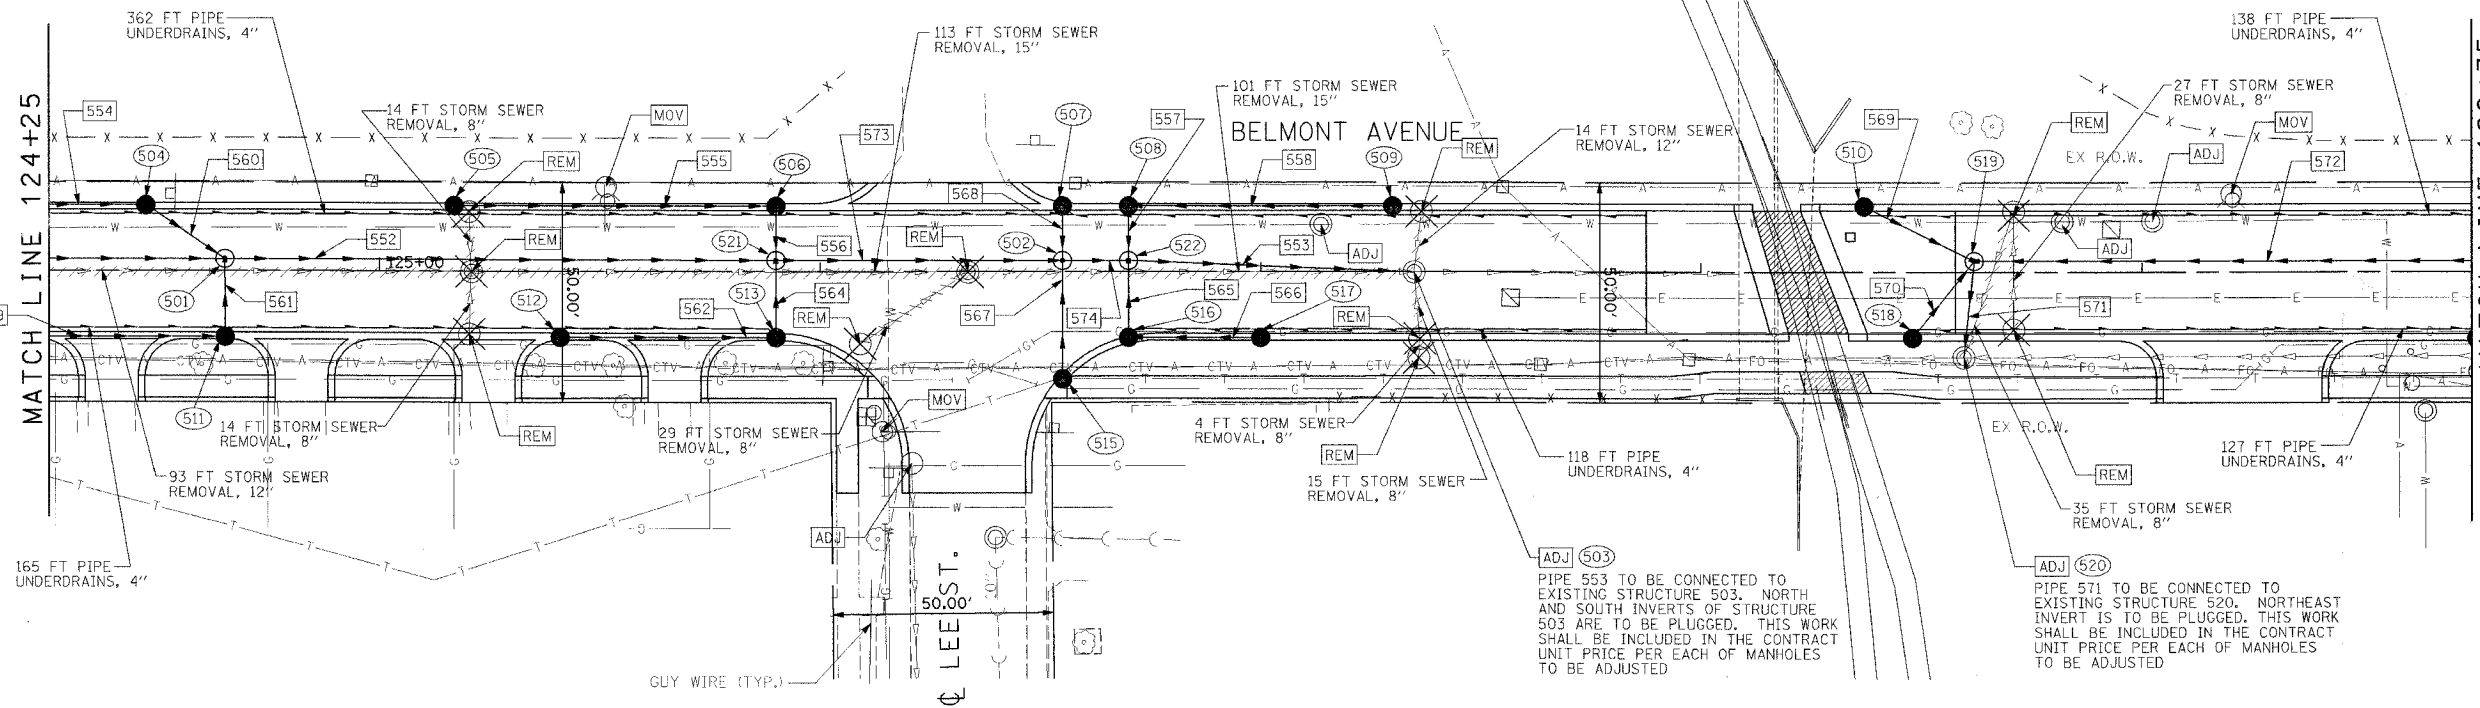



F.A. RTE.	SECTION	COUNTY	TOTAL SHEETS	SHEET NO.
1373 00-00058-00-RS		COOK	113	38
STA. 124+25	TO STA. 129+75			
FED. ROAD DIST. NO.	ILLINOIS FED. AID PROJECT			
CONTRACT NO.	83861			



- NOTE
- SEE SHEET 34 FOR DRAINAGE LEGEND.
 - CONTRACTOR TO CONNECT PIPE UNDERDRAINS TO CATCH BASINS AND GROUT IN PLACE. THIS WORK SHALL BE INCLUDED IN THE CONTRACT UNIT PRICE PER FOOT OF PIPE UNDERDRAINS, 4".
 - SEE "LEYDEN TOWNSHIP UTILITY RELOCATION PLAN AND PROFILE" FOR DETAILED INFORMATION ON THE SANITARY SEWER AND WATER MAIN RELOCATIONS AND SANITARY AND WATER SERVICE ADJUSTMENTS.


PLAN

 SCALE: 1"=20'



DATE	BY
DESIGNED	
PLOTTED	
ALIGNMENT CHECKED	
NOTE BOOK	
NO.	
DATE	
FILE NAME	

DATE	BY
DESIGNED	
PLOTTED	
ALIGNMENT CHECKED	
NOTE BOOK	
NO.	
DATE	
FILE NAME	

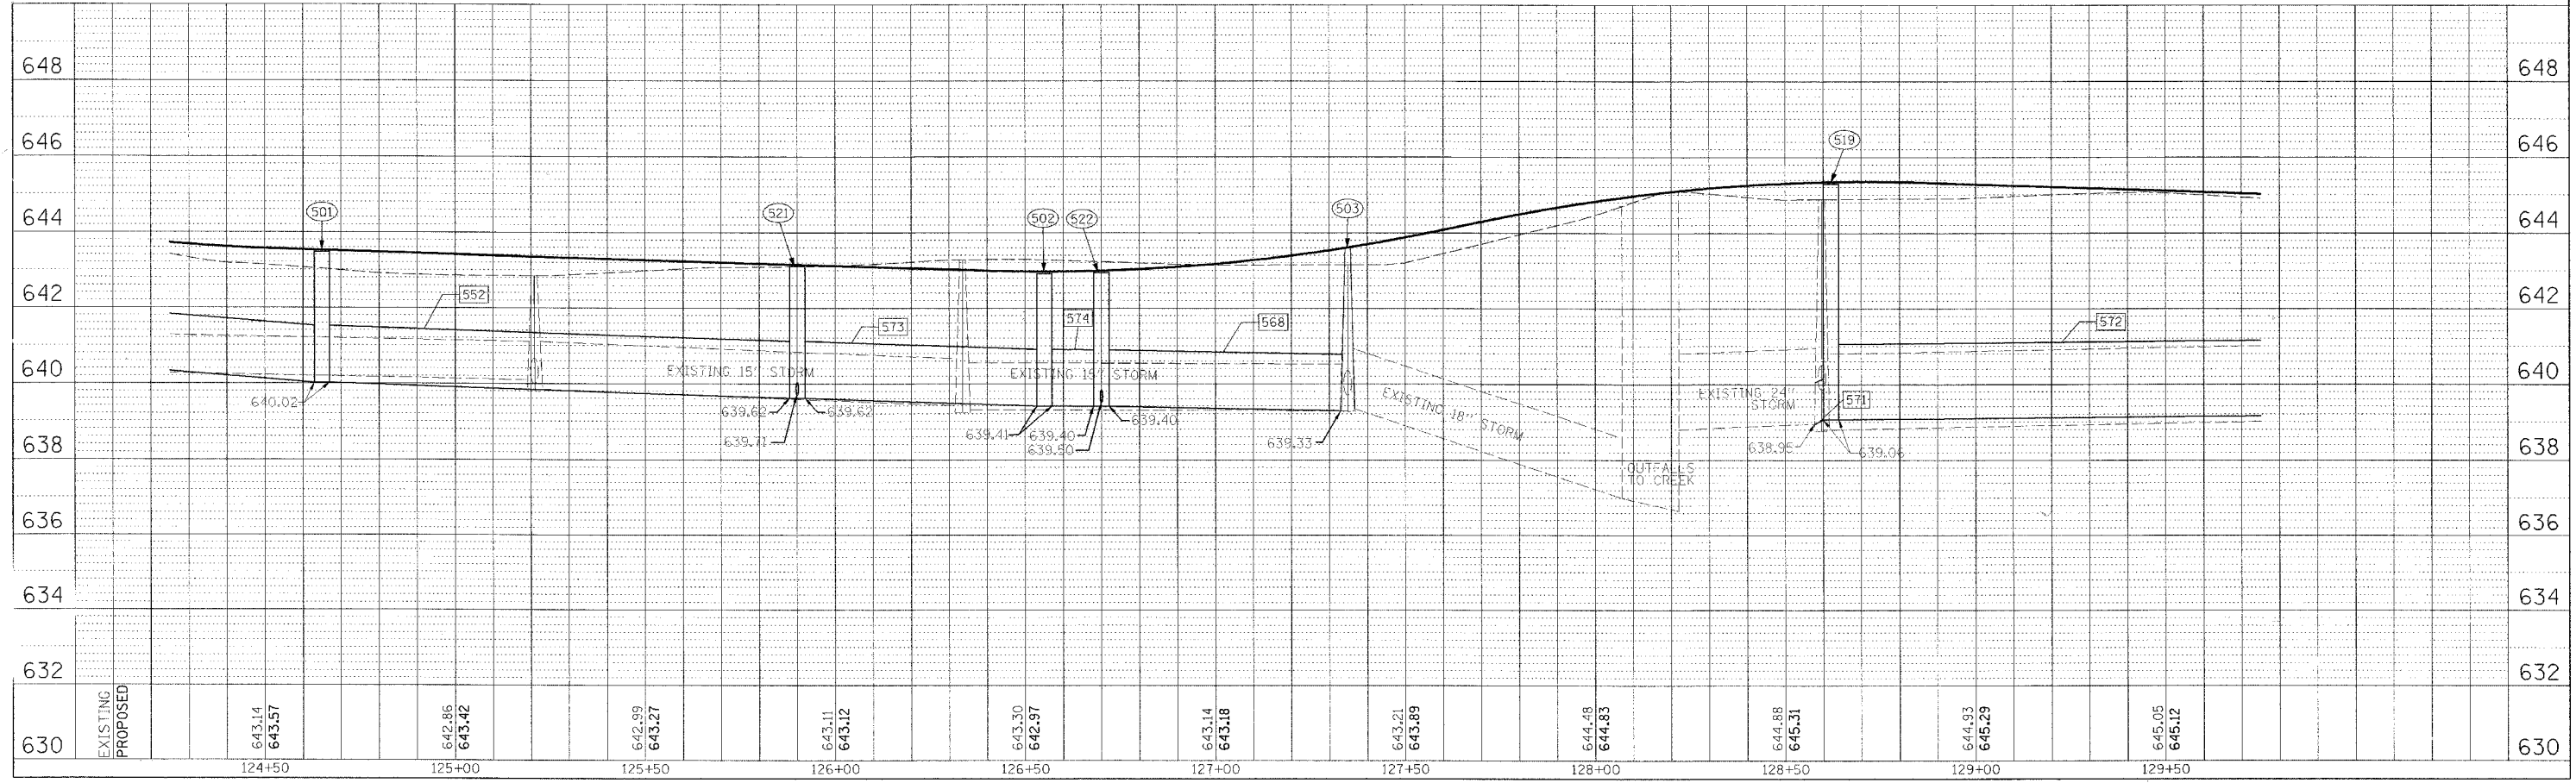

DRAINAGE PLAN AND PROFILE STA. 124+25 TO STA. 129+75

p:\14300\plans\sheets\F14300-rpl0105.dgn
3/25/2006
3:11:46 PM